


SPRINKLER FLOOR CONTROL VALVE DETAIL  
NO SCALE

PARTIAL SPRINKLER PLAN - LOBBY / MEZZANINE LEVEL  
SCALE: 1/8" = 1'-0"


**REVISIONS**  
 ▲ 7-27-83  
 GENERAL REVISION; ADDED HEADS FOR WATER WALL AT ATRIUM & POOL ENTRANCE; ADDED FIRE HOSE VALVES.

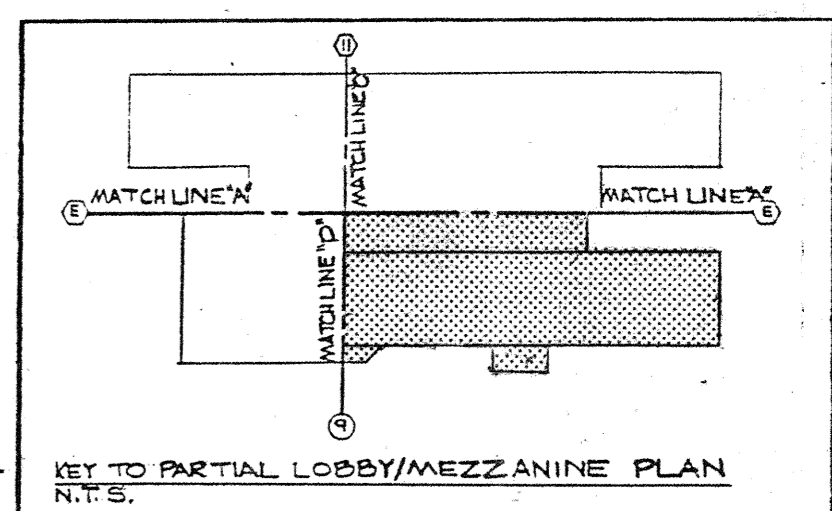

Consulting Engineers  
 3257 Lochness Drive  
 Lexington, Kentucky

CARTER - FOSTER INC.

**CAPITOL PLAZA HOTEL**  
 FRANKFORT / KENTUCKY

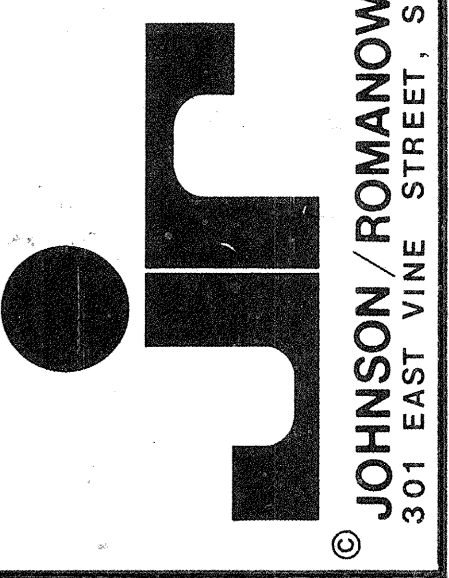


DRAWN B.H.	PROJECT
CHECKED	DATE 5-10-83


**SPRINKLER**  
 PARTIAL SPRINKLER PLAN - LOBBY / MEZZANINE LEVEL  
 REISSUED 8-2-83

**DRAWING**  
**SP-1**

JOHNSON / ROMANOWITZ ARCHITECTS / LEXINGTON / KENTUCKY  
 301 EAST VINE STREET, SUITE A  
 TELEPHONE 1808/252-6781

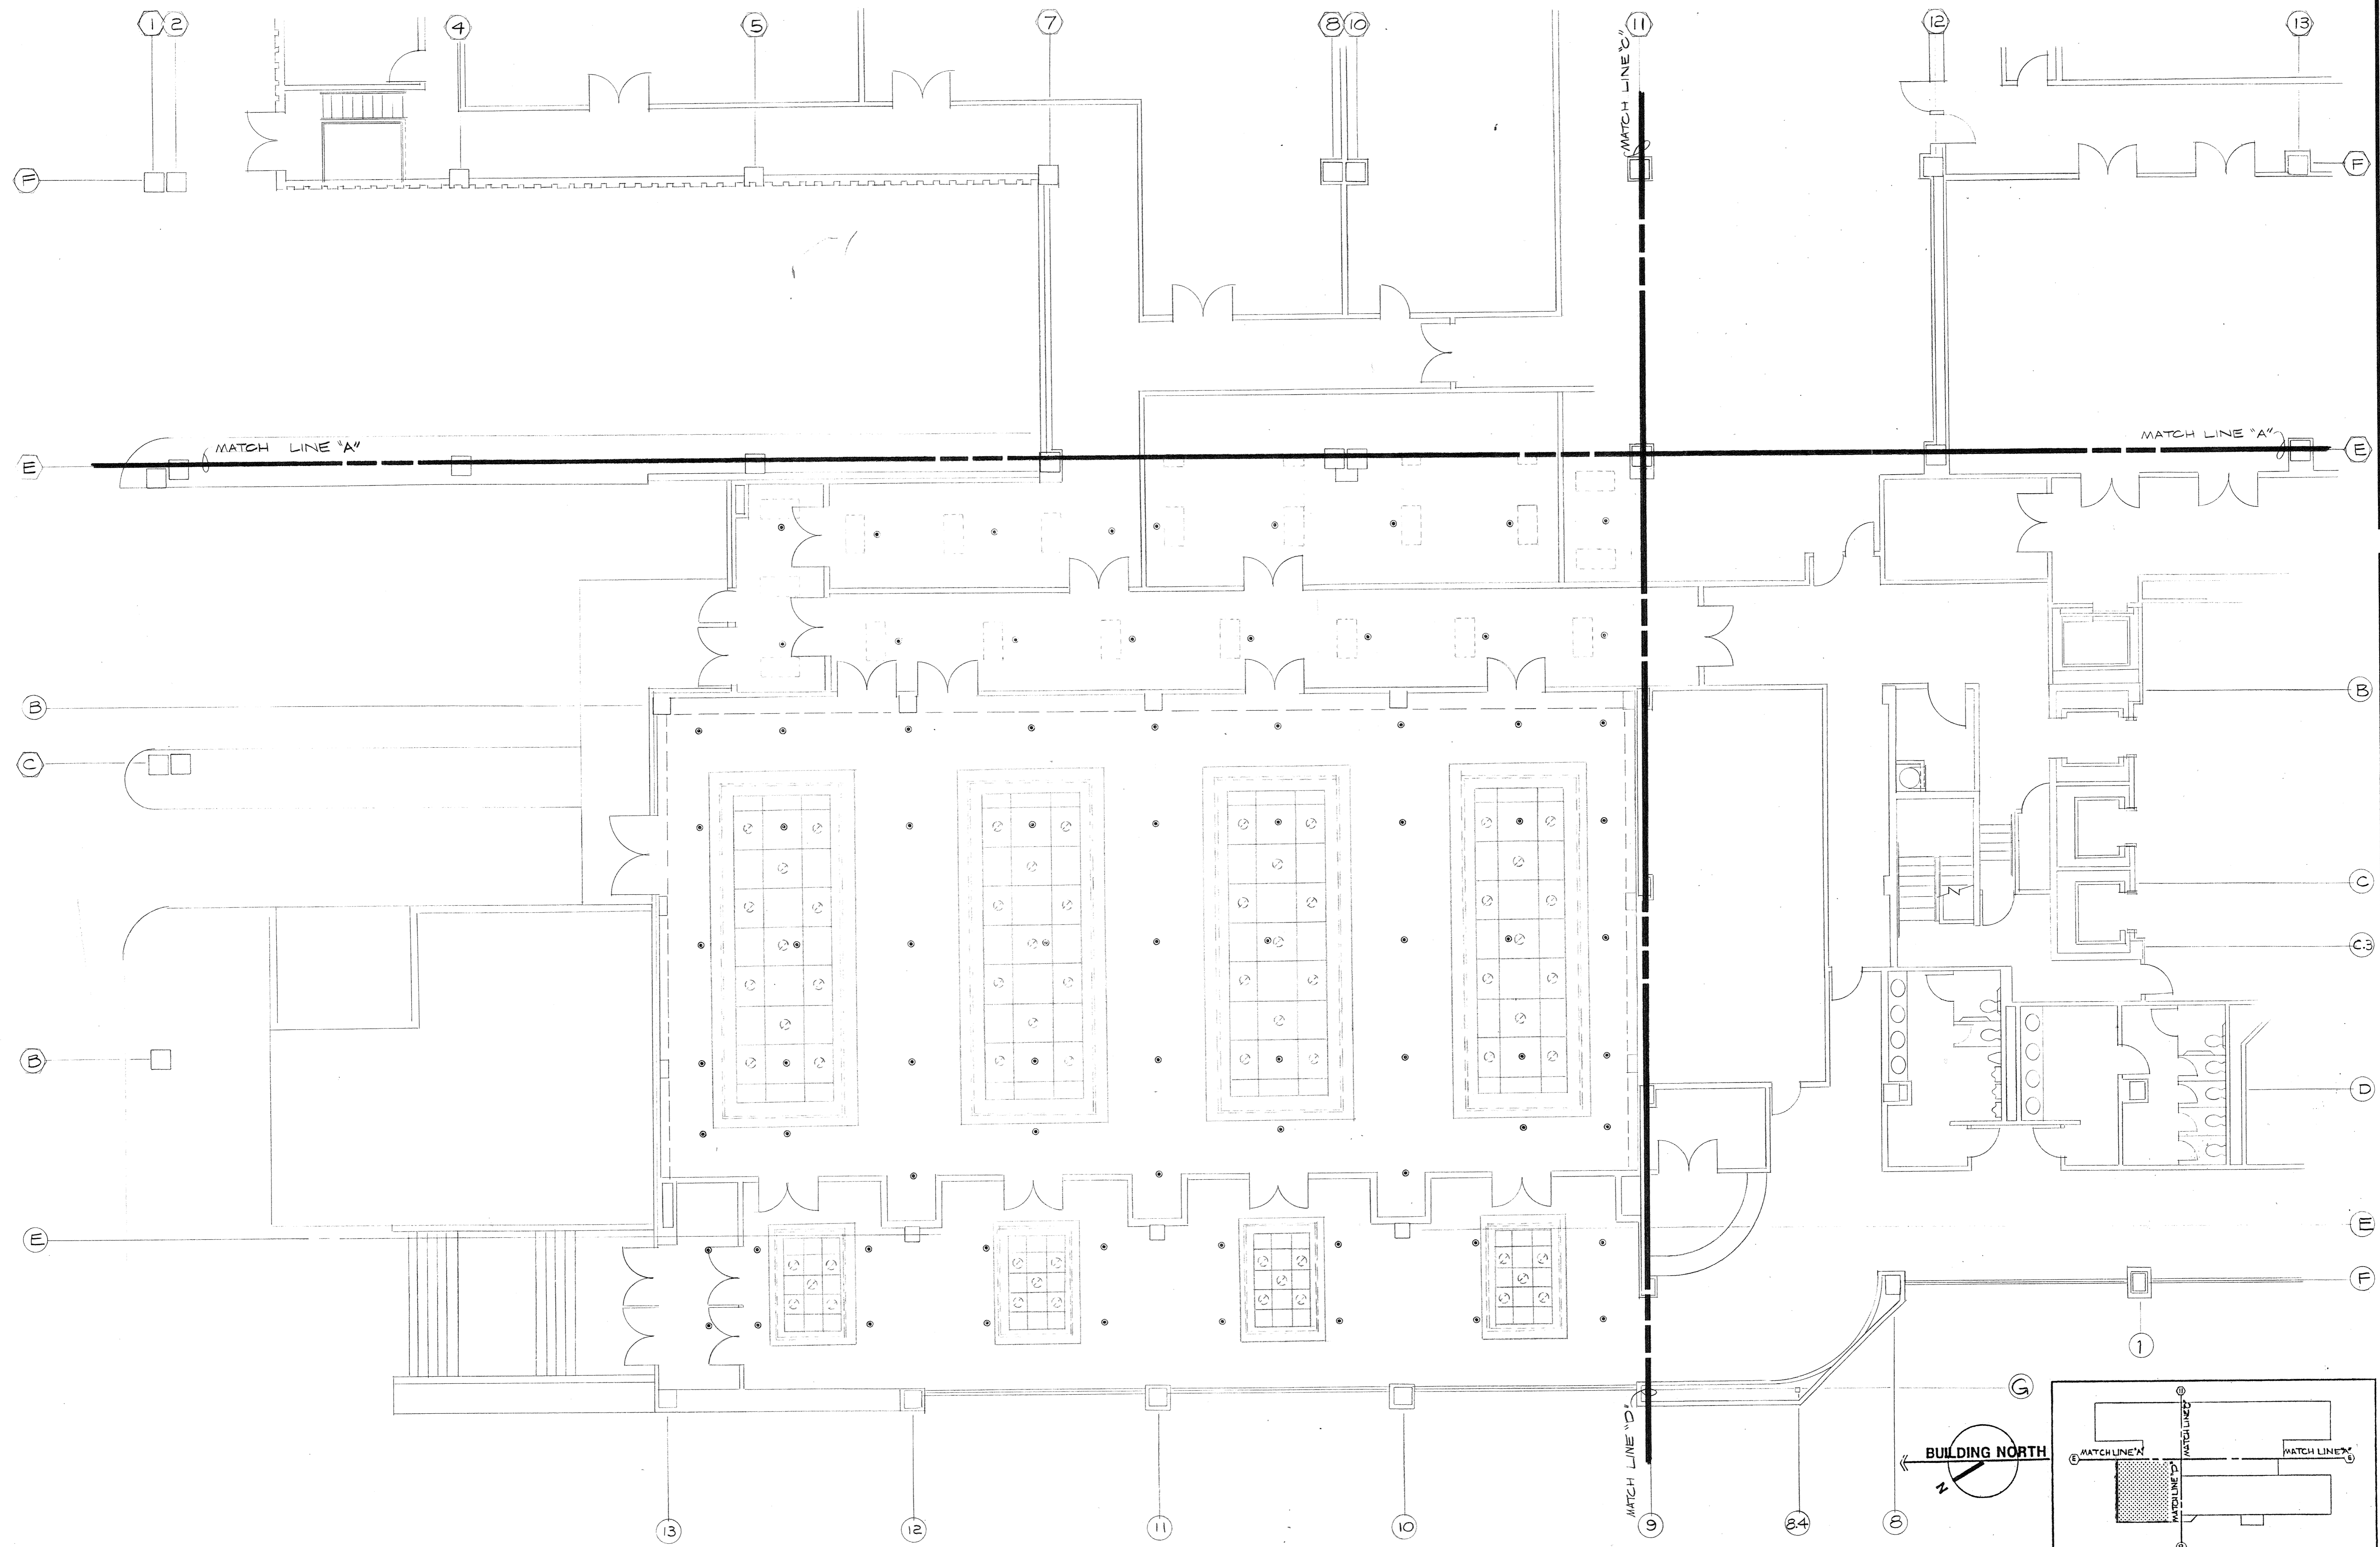

PARTIAL SPRINKLER PLAN - LOBBY/MEZZANINE LEVEL  
 SCALE: 1/8" = 1'-0"

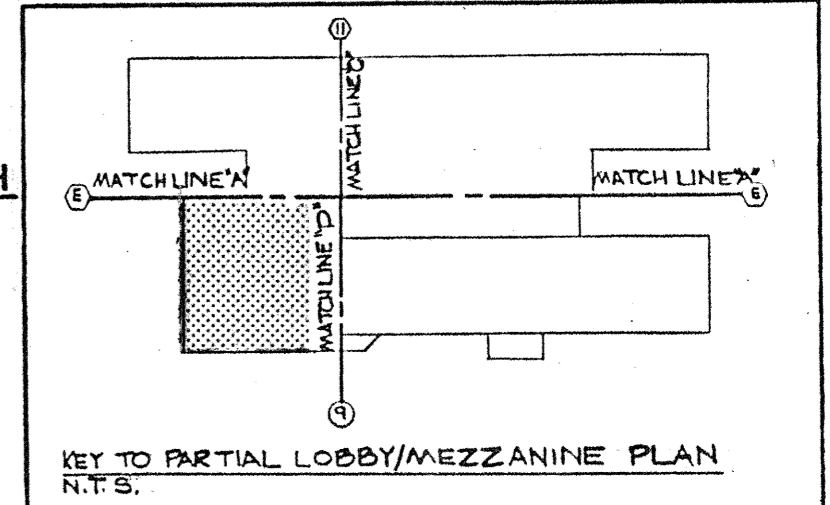


Consulting Engineers  
 3257 Lochness Drive  
 Lexington, Kentucky

**CARTER - FOSTER INC.**


**CAPITOL PLAZA HOTEL**  
 FRANKFORT / KENTUCKY

JOHNSON / ROMANOWITZ / ARCHITECTS / LEXINGTON / KENTUCKY

DRAWN K.P. E.D.H.	PROJECT
CHECKED	DATE 5-10-83
<b>SPRINKLER</b>	
PARTIAL SPRINKLER PLAN - LOBBY/ MEZZANINE LEVEL	
<b>DRAWING SP-2</b>	

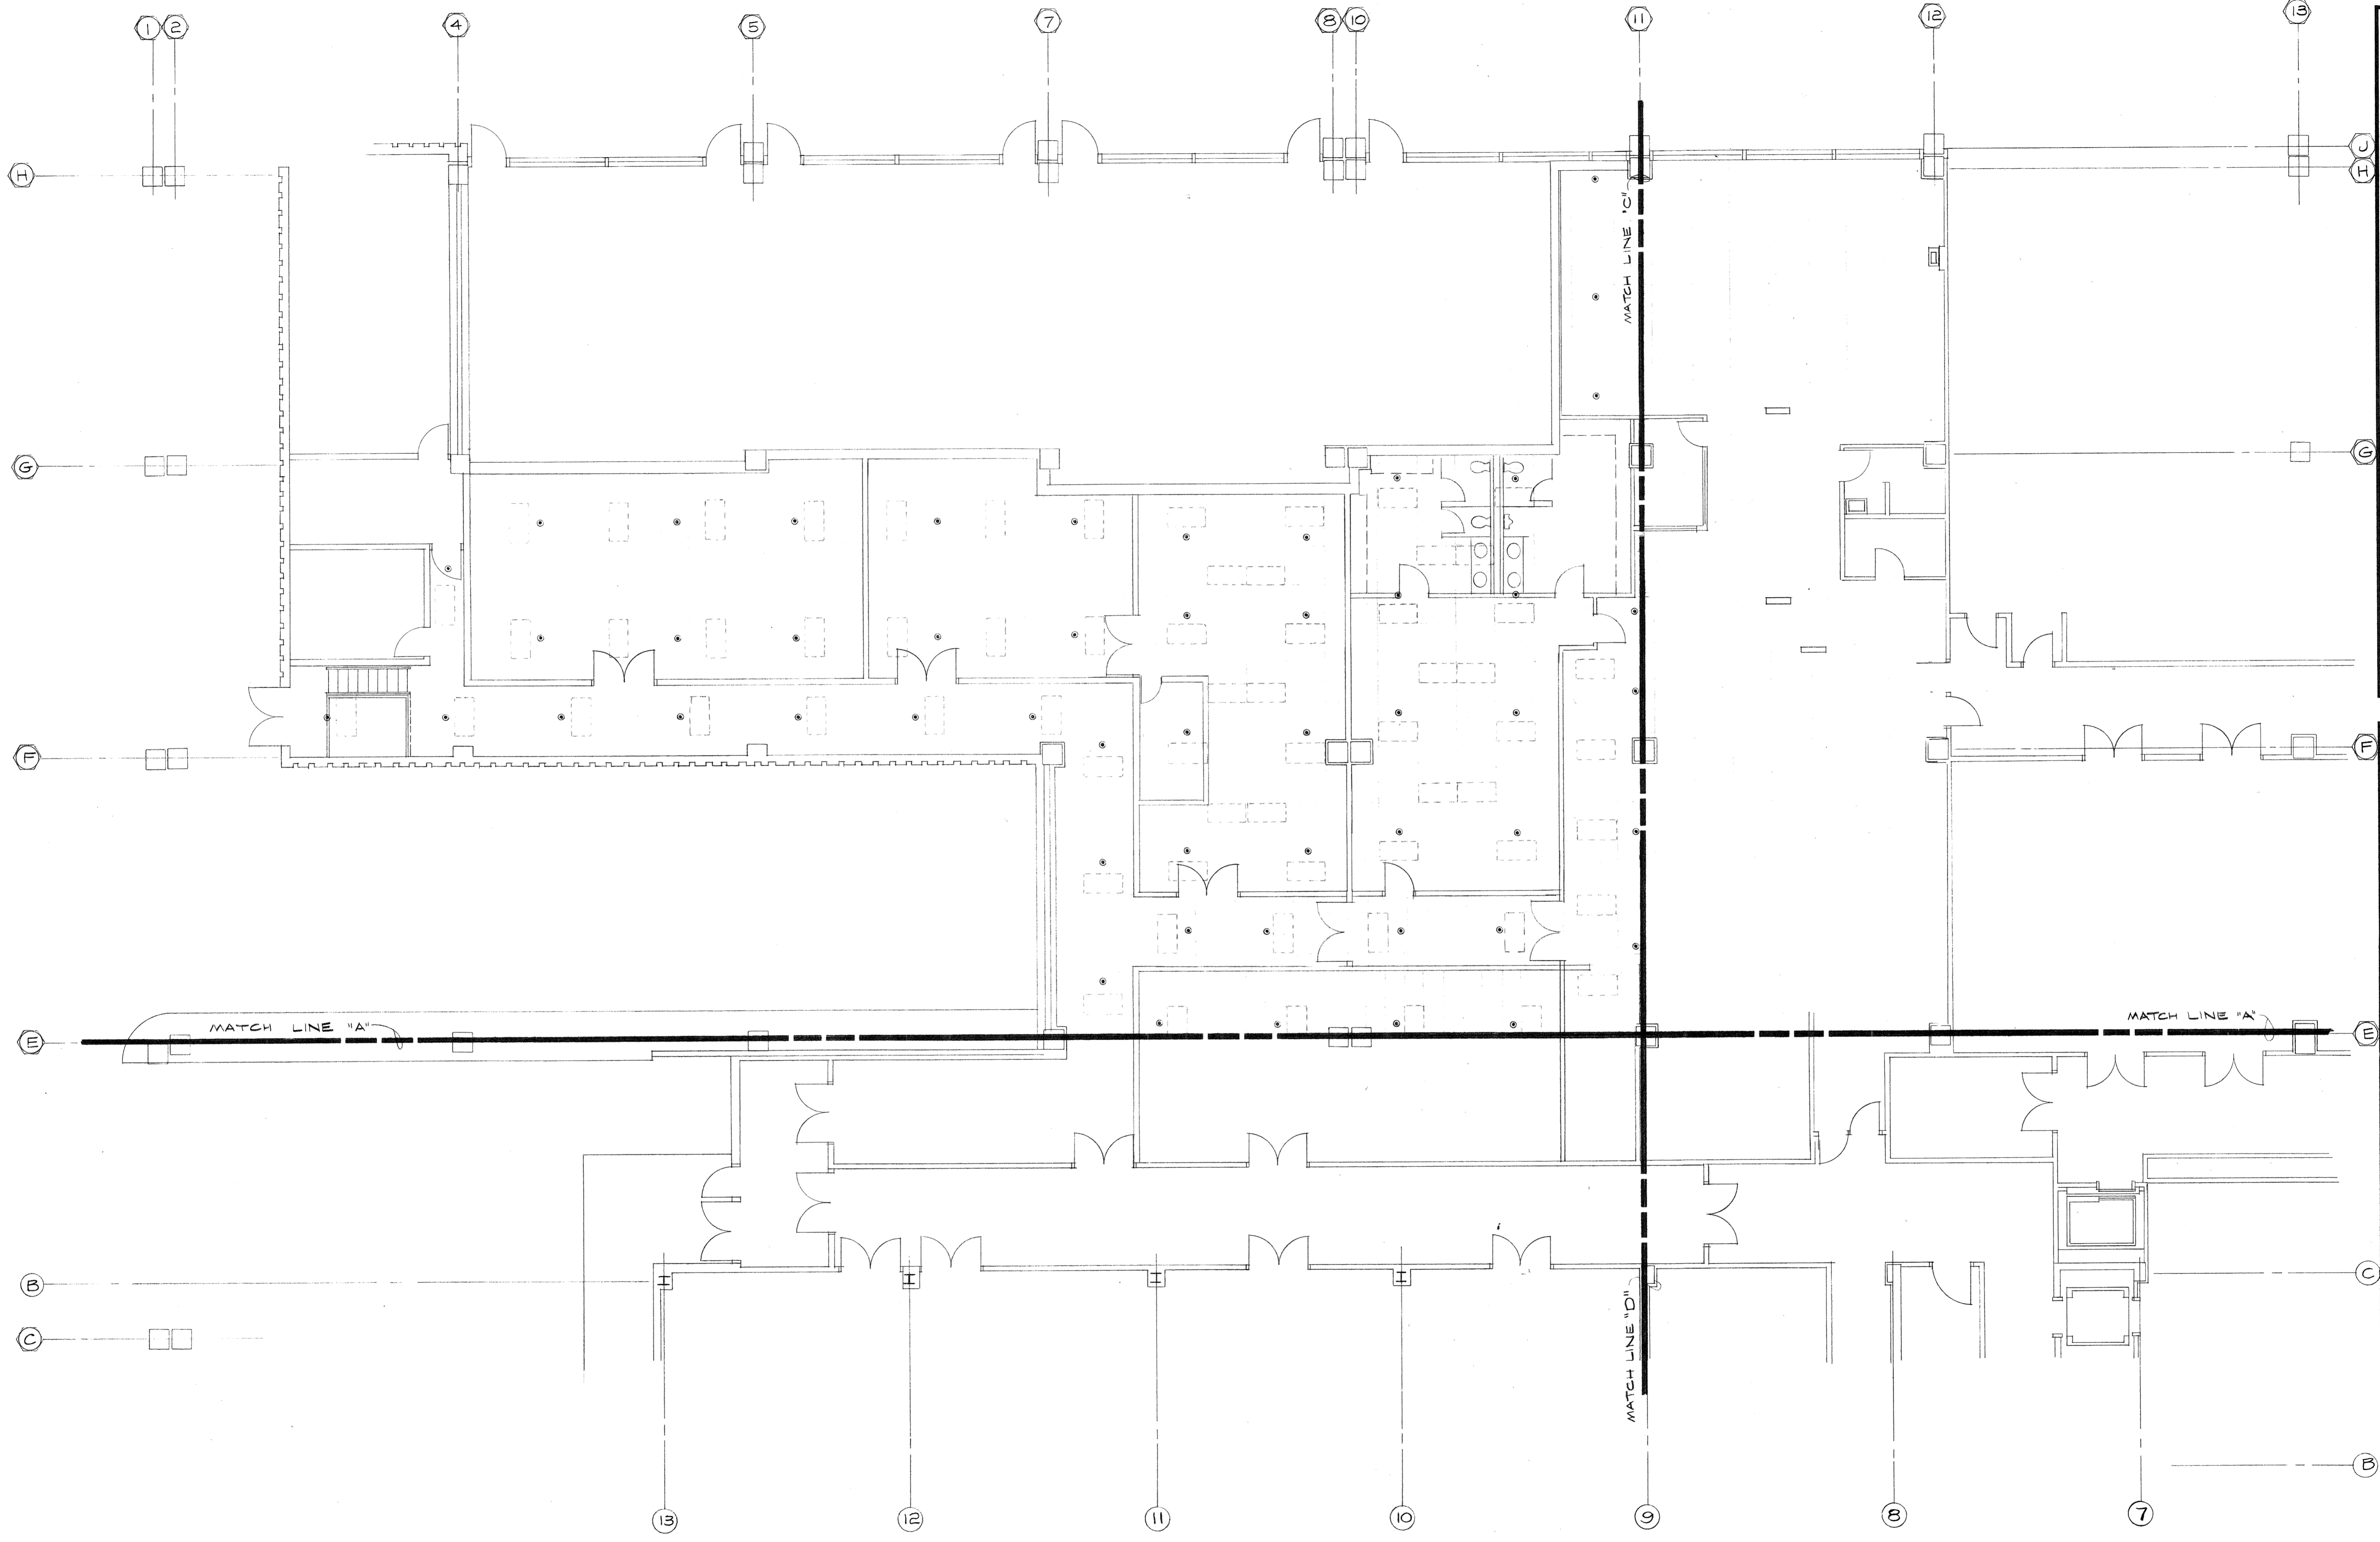

PARTIAL SPRINKLER PLAN - LOBBY/MEZZANINE LEVEL  
 SCALE: 1/8" = 1'-0"

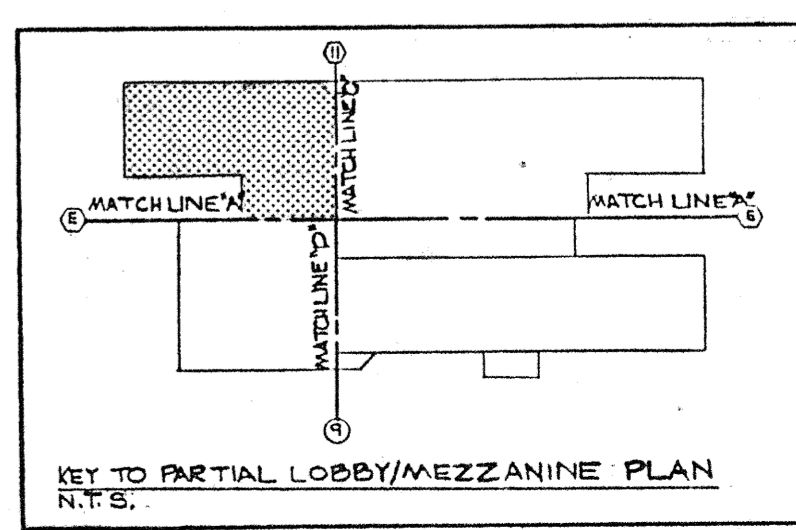


**CARTER - FOSTER INC.**  
 Consulting Engineers  
 3257 Lochness Drive  
 Lexington, Kentucky


**CAPITOL PLAZA HOTEL**  
 FRANKFORT / KENTUCKY

JOHNSON / ROMANOWITZ / ARCHITECTS / LEXINGTON / KENTUCKY

DRAWN B. H.	PROJECT
CHECKED	DATE 5-10-83
<b>SPRINKLER</b>	
PARTIAL SPRINKLER PLAN - LOBBY/ MEZZANINE LEVEL	
<b>DRAWING SP-3</b>	

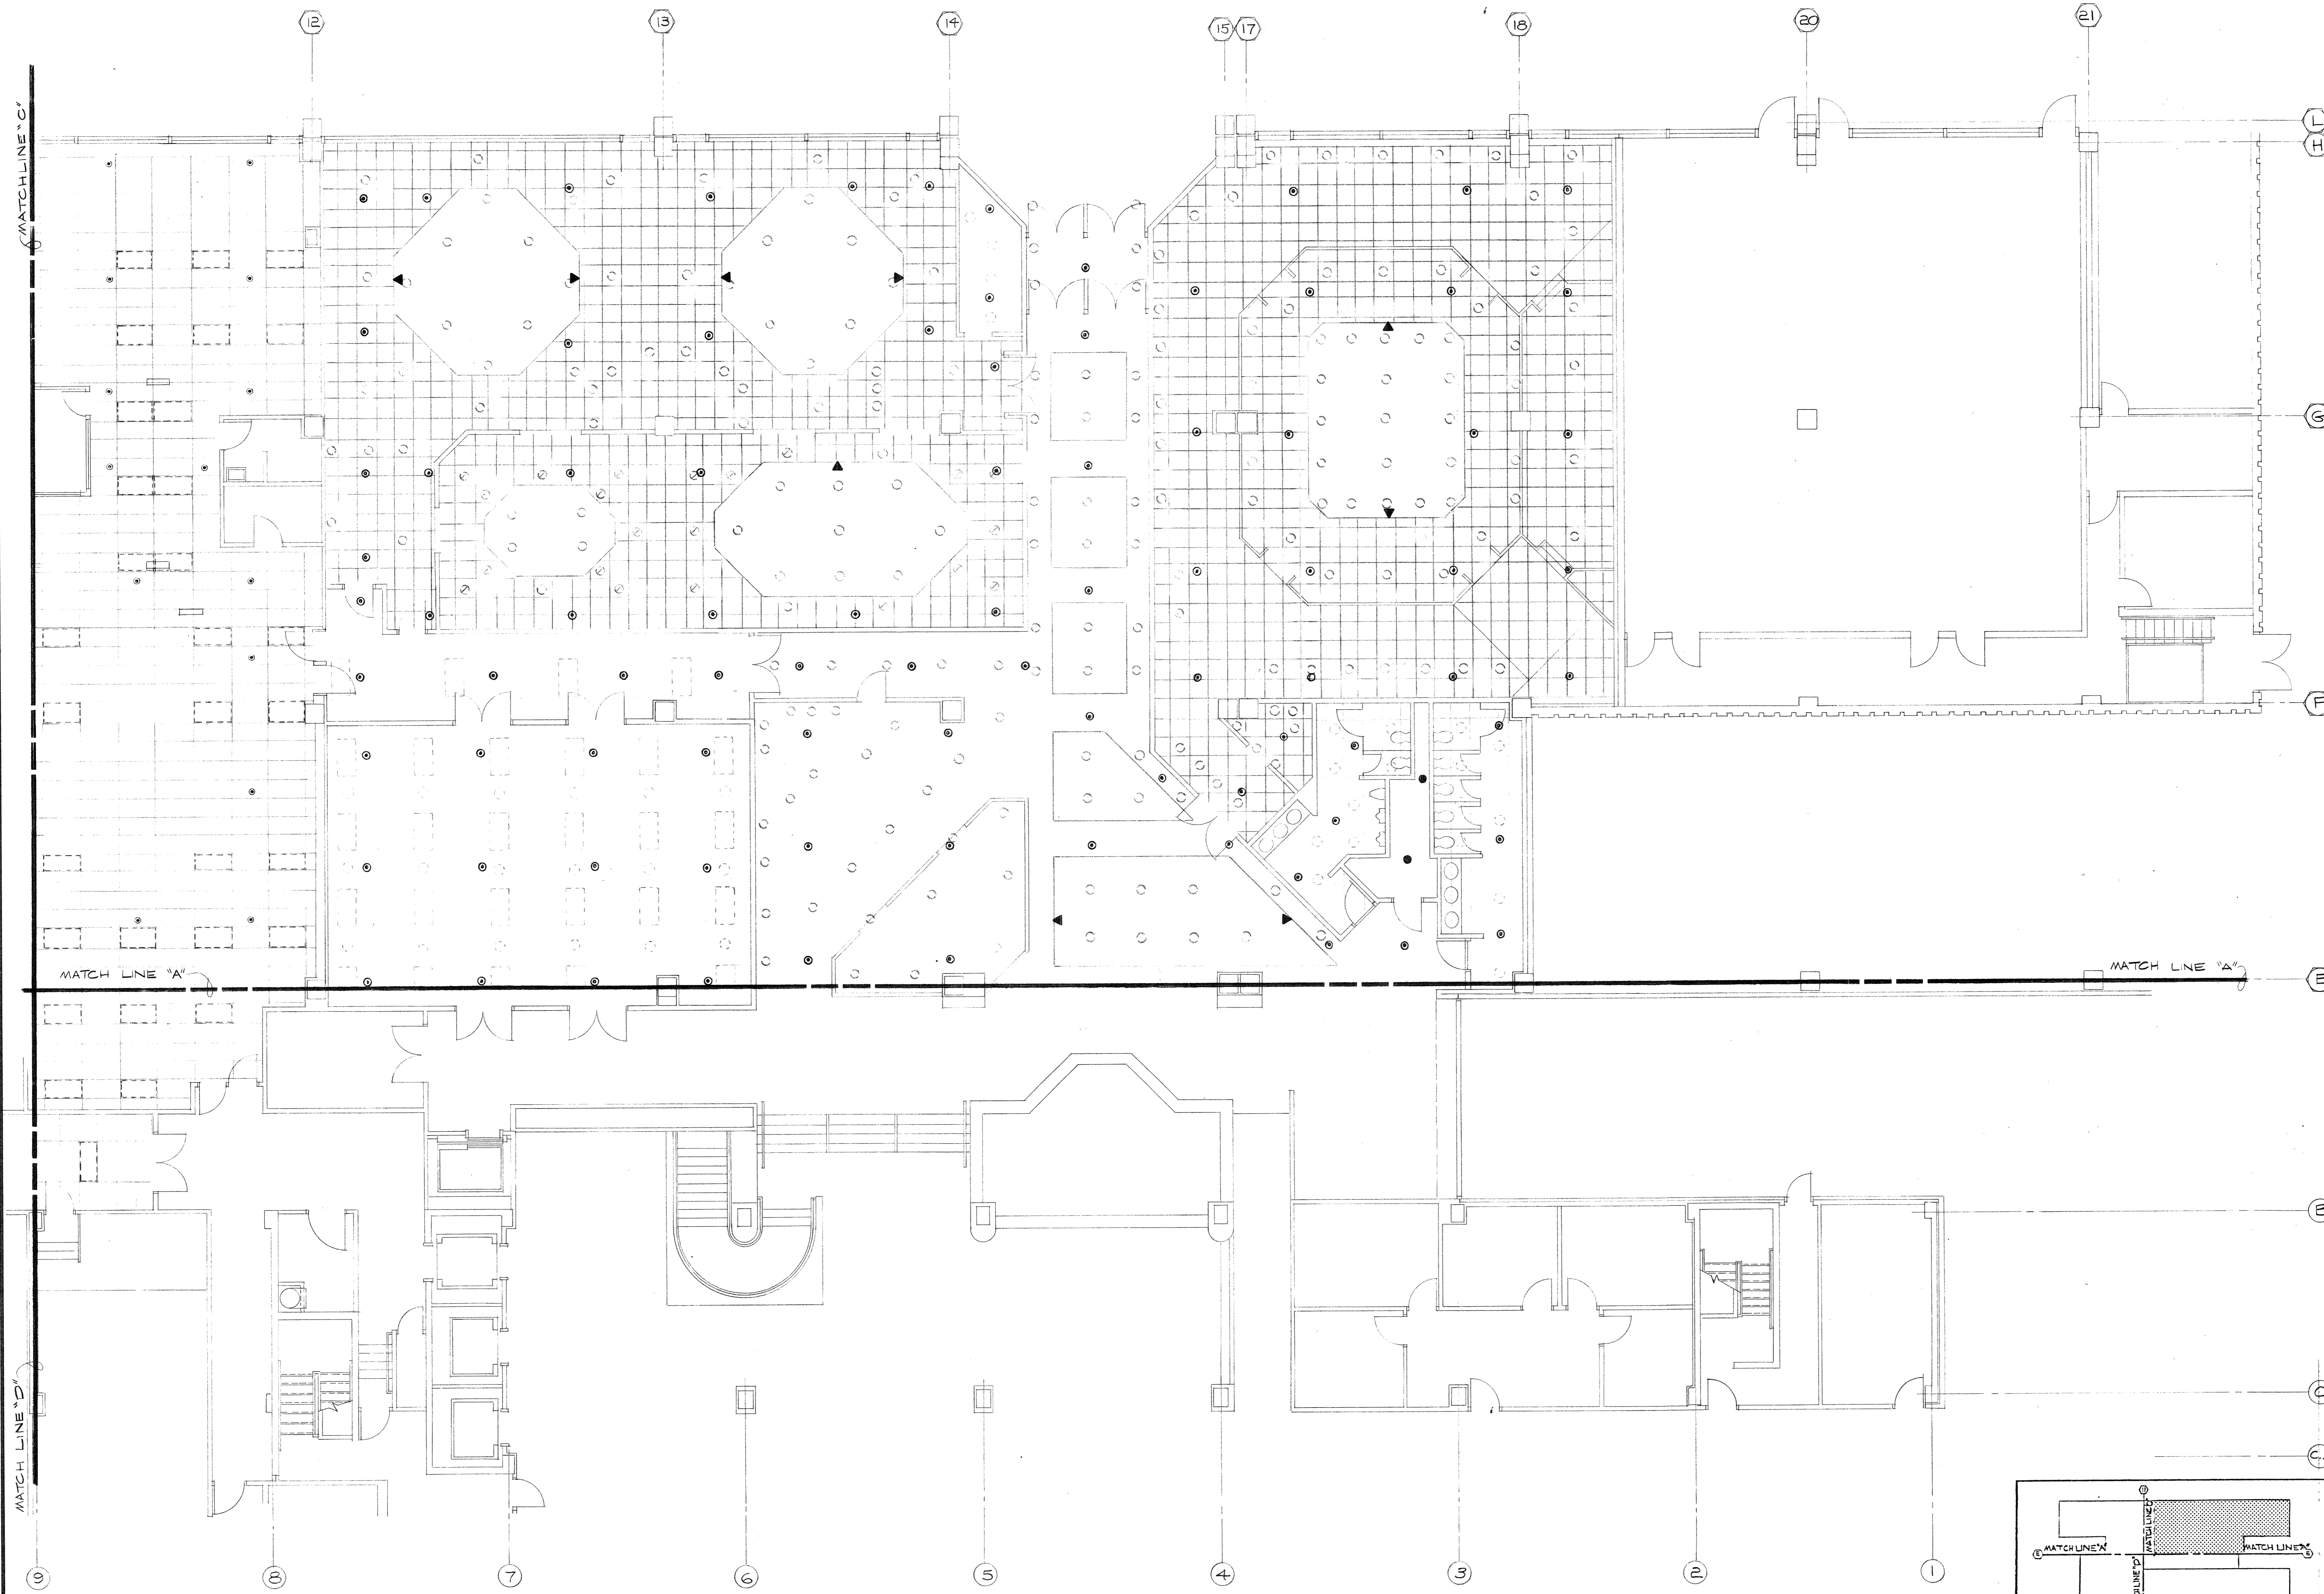

PARTIAL SPRINKLER PLAN - LOBBY/MEZZANINE LEVEL  
 SCALE: 1/8" = 1'-0"

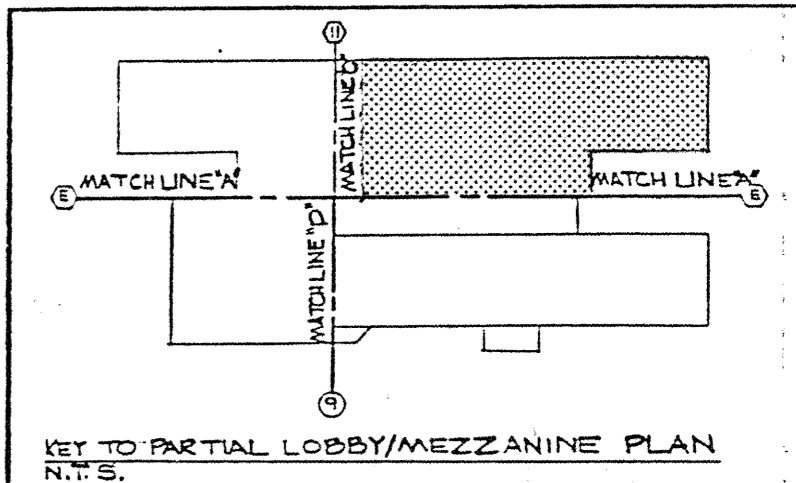


CARTER - FOSTER INC.  
 Consulting Engineers  
 3257 Lochness Drive  
 Lexington, Kentucky

CAPITOL PLAZA HOTEL  
 FRANKFORT / KENTUCKY


JOHNSON / ROMANOWITZ / ARCHITECTS / LEXINGTON / KENTUCKY  
 301 EAST VINE STREET, SUITE A  
 TELEPHONE (606) 252-6781

DRAWN B.H.	PROJECT
CHECKED	DATE 5-10-83
<b>SPRINKLER</b>	
PARTIAL SPRINKLER PLAN - LOBBY/ MEZZANINE LEVEL	
<b>DRAWING</b>	
<b>SP-4</b>	

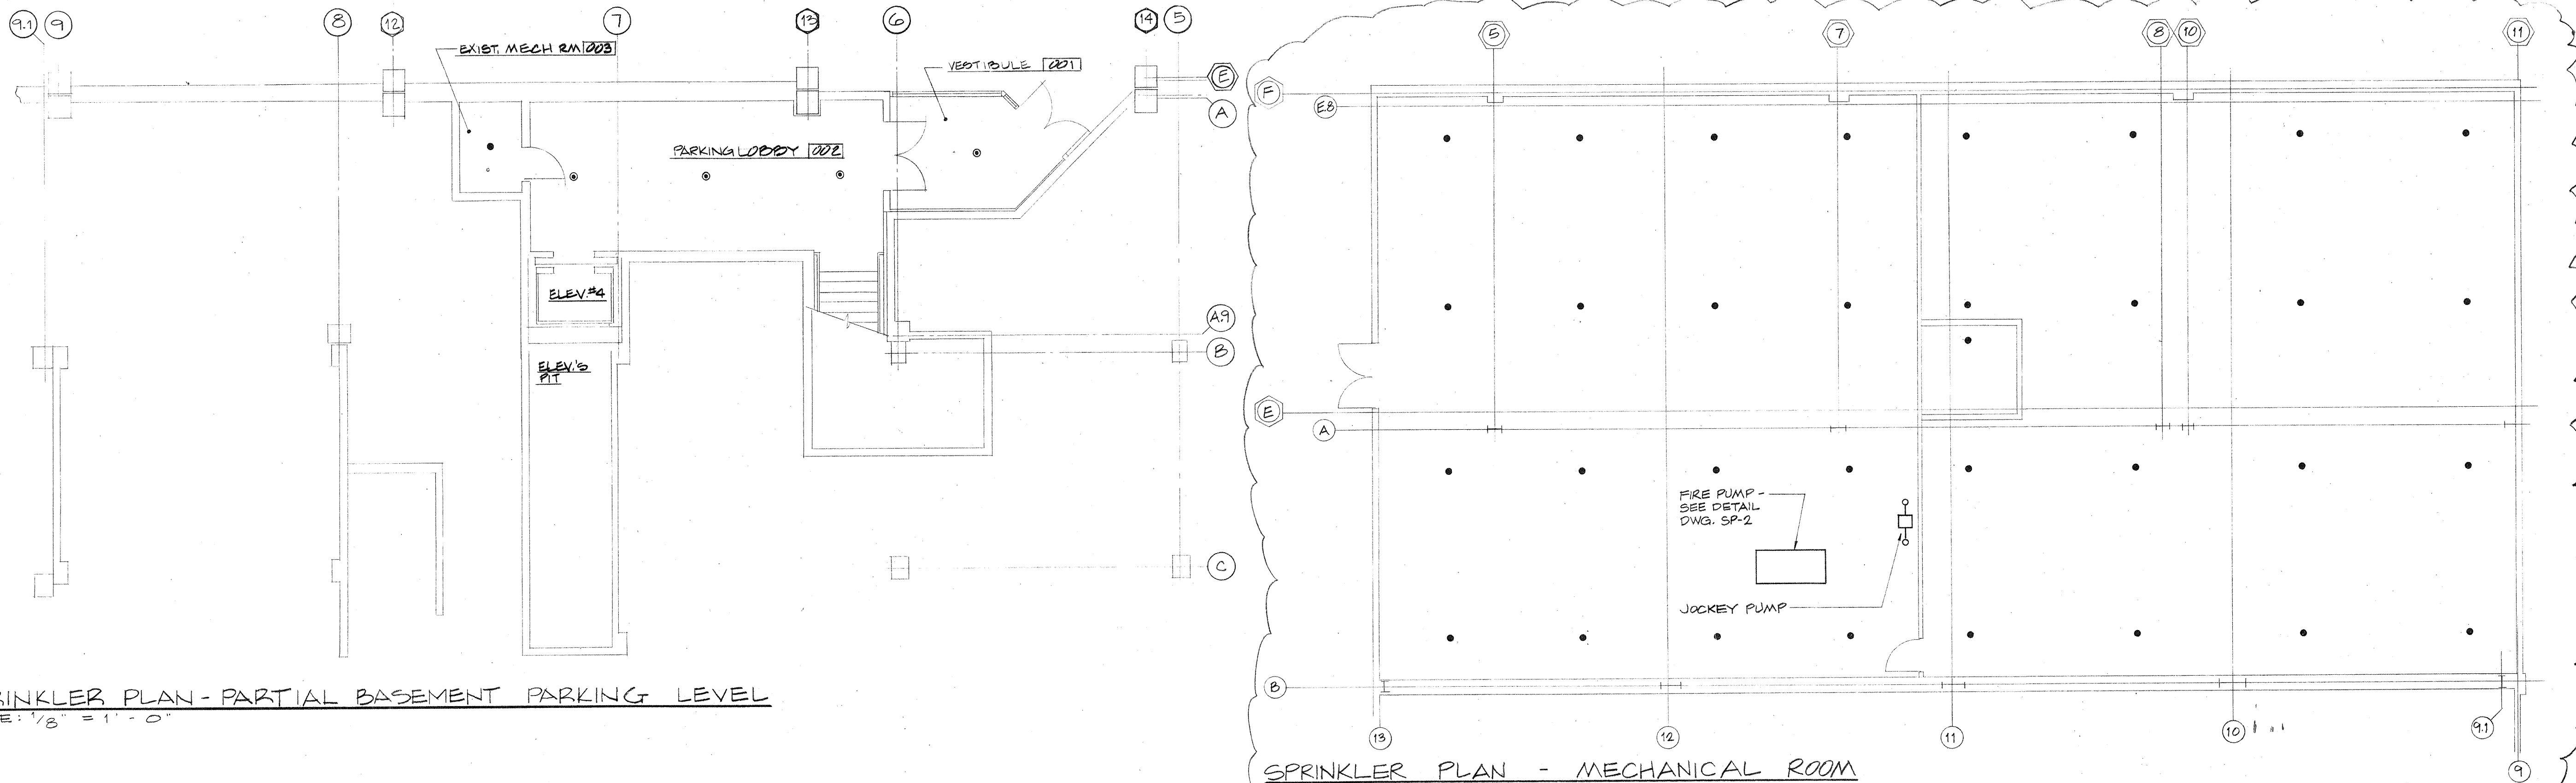


SPRINKLER PLAN - PARTIAL BASEMENT PARKING LEVEL  
SCALE: 1/8" = 1'-0"

SPRINKLER PLAN - MECHANICAL ROOM  
SCALE: 1/8" = 1'-0"

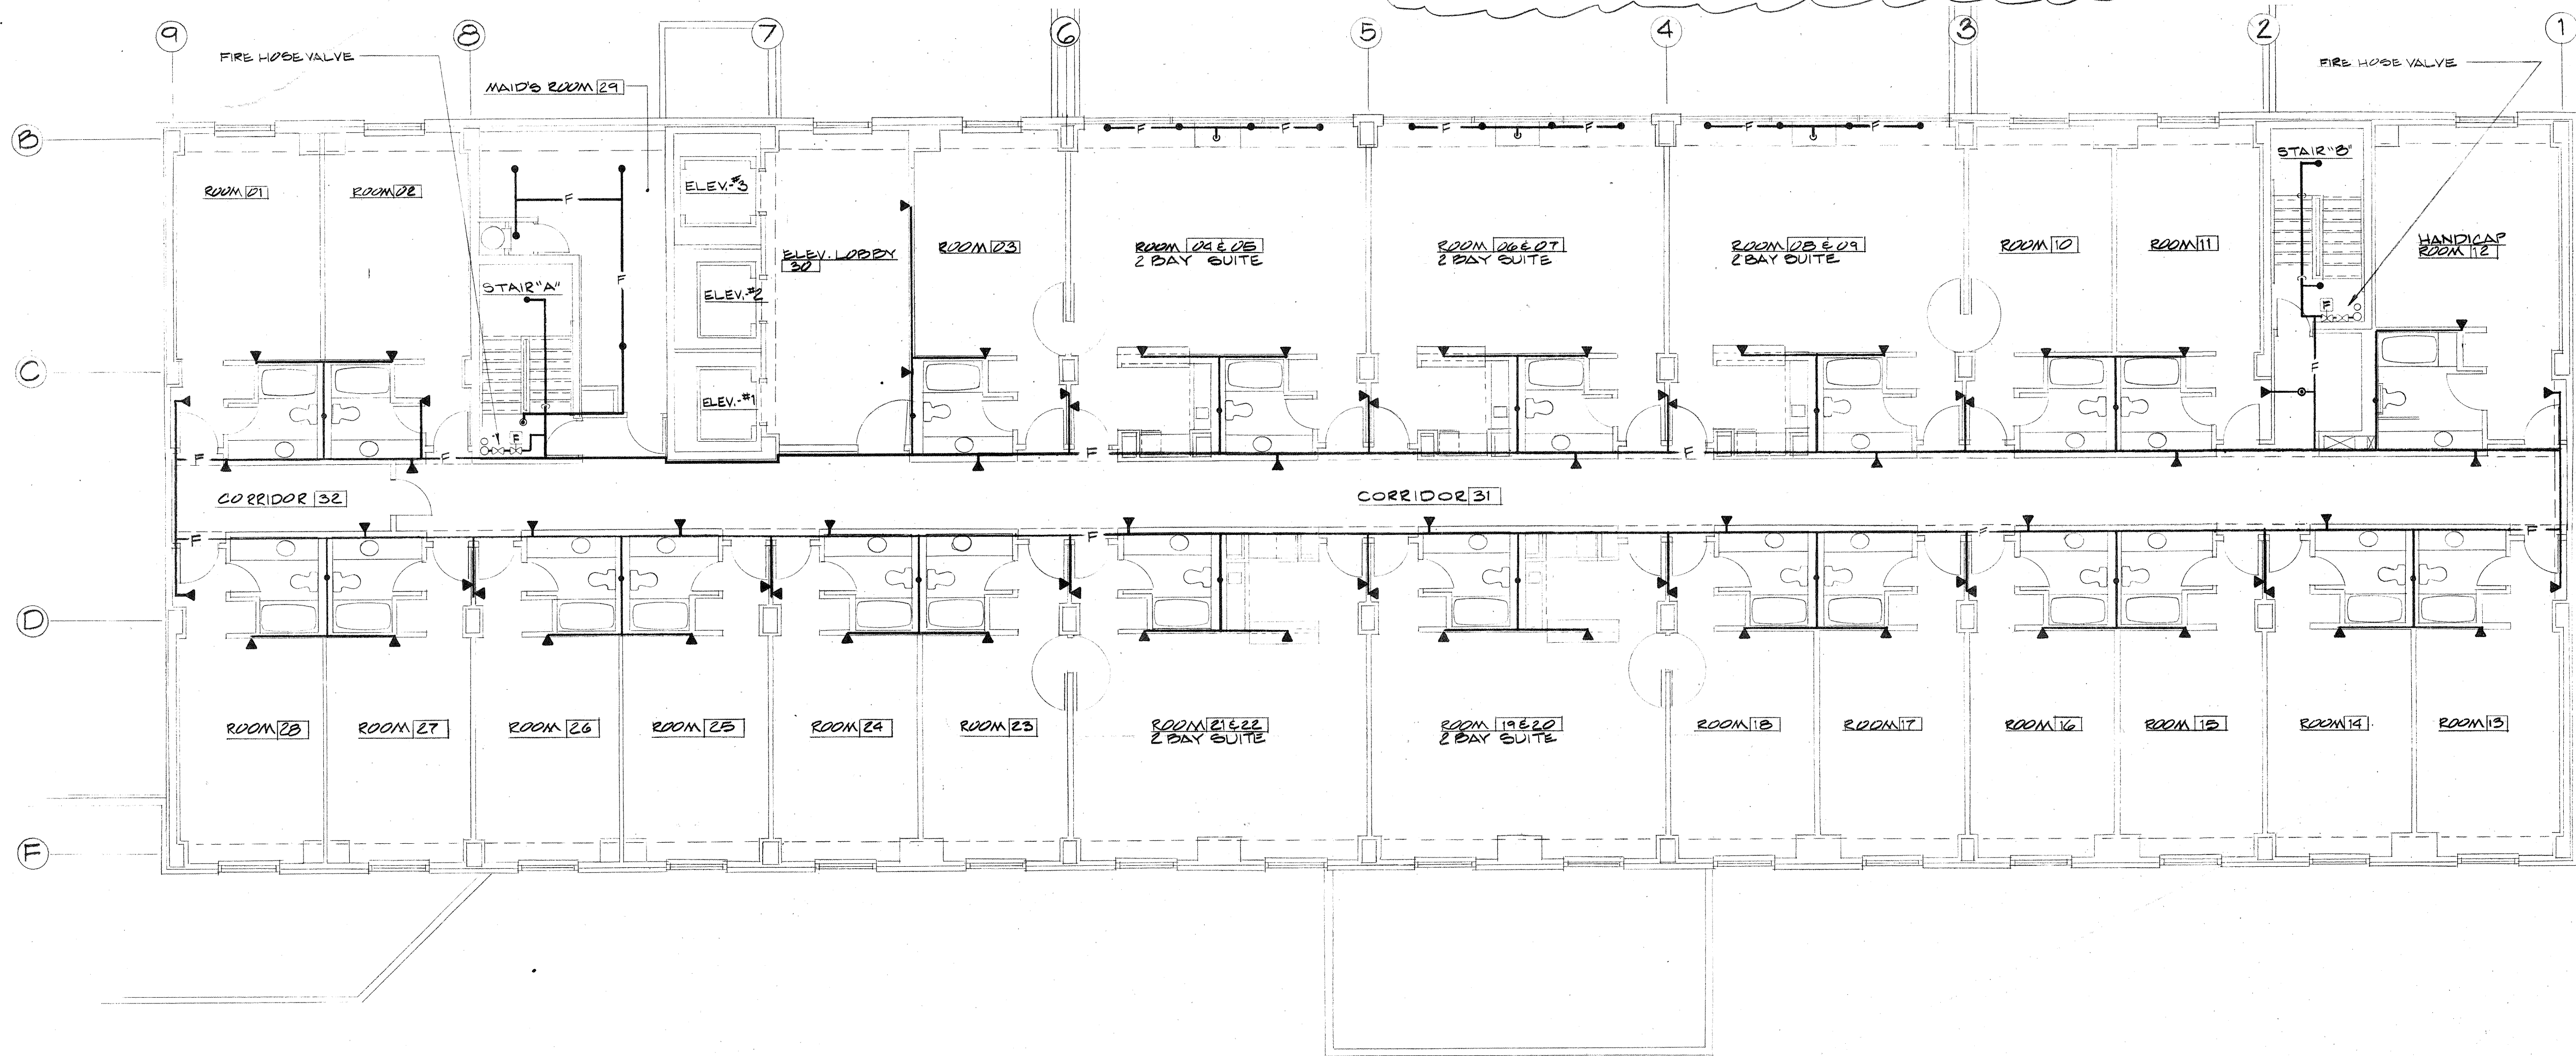

SPRINKLER PLAN - SECOND FLOOR  
SCALE: 1/8" = 1'-0"

REVISIONS  
 ▲ 7-27-83  
 GENERAL REVISION  
 LOCATED FIRE HOSE  
 VALVE & LOCATED  
 SPRINKLER HEAD IN  
 PLUMBING CHASE.  
 ▲ 8-26-83  
 ADDED MECHANICAL ROOM

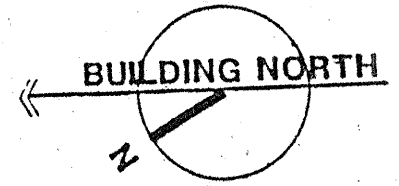

Consulting Engineers  
 3257 Lochness Drive  
 Lexington, Kentucky


CARTER - FOSTER INC.

CAPITOL PLAZA HOTEL  
 FRANKFORT / KENTUCKY


JOHNSON / ROMANOWITZ / ARCHITECTS / LEXINGTON / KENTUCKY  
 301 EAST VINE STREET, SUITE A  
 TELEPHONE (606) 252-6781

DRAWN B. H.	PROJECT
CHECKED	DATE 5-10-83
<b>SPRINKLER</b>	
SPRINKLER PLAN - 2 <sup>ND</sup> FLOOR	
REISSUED 8-2-83	
<b>DRAWING</b>	
<b>SP-5</b>	

REISSUED 9-20-83

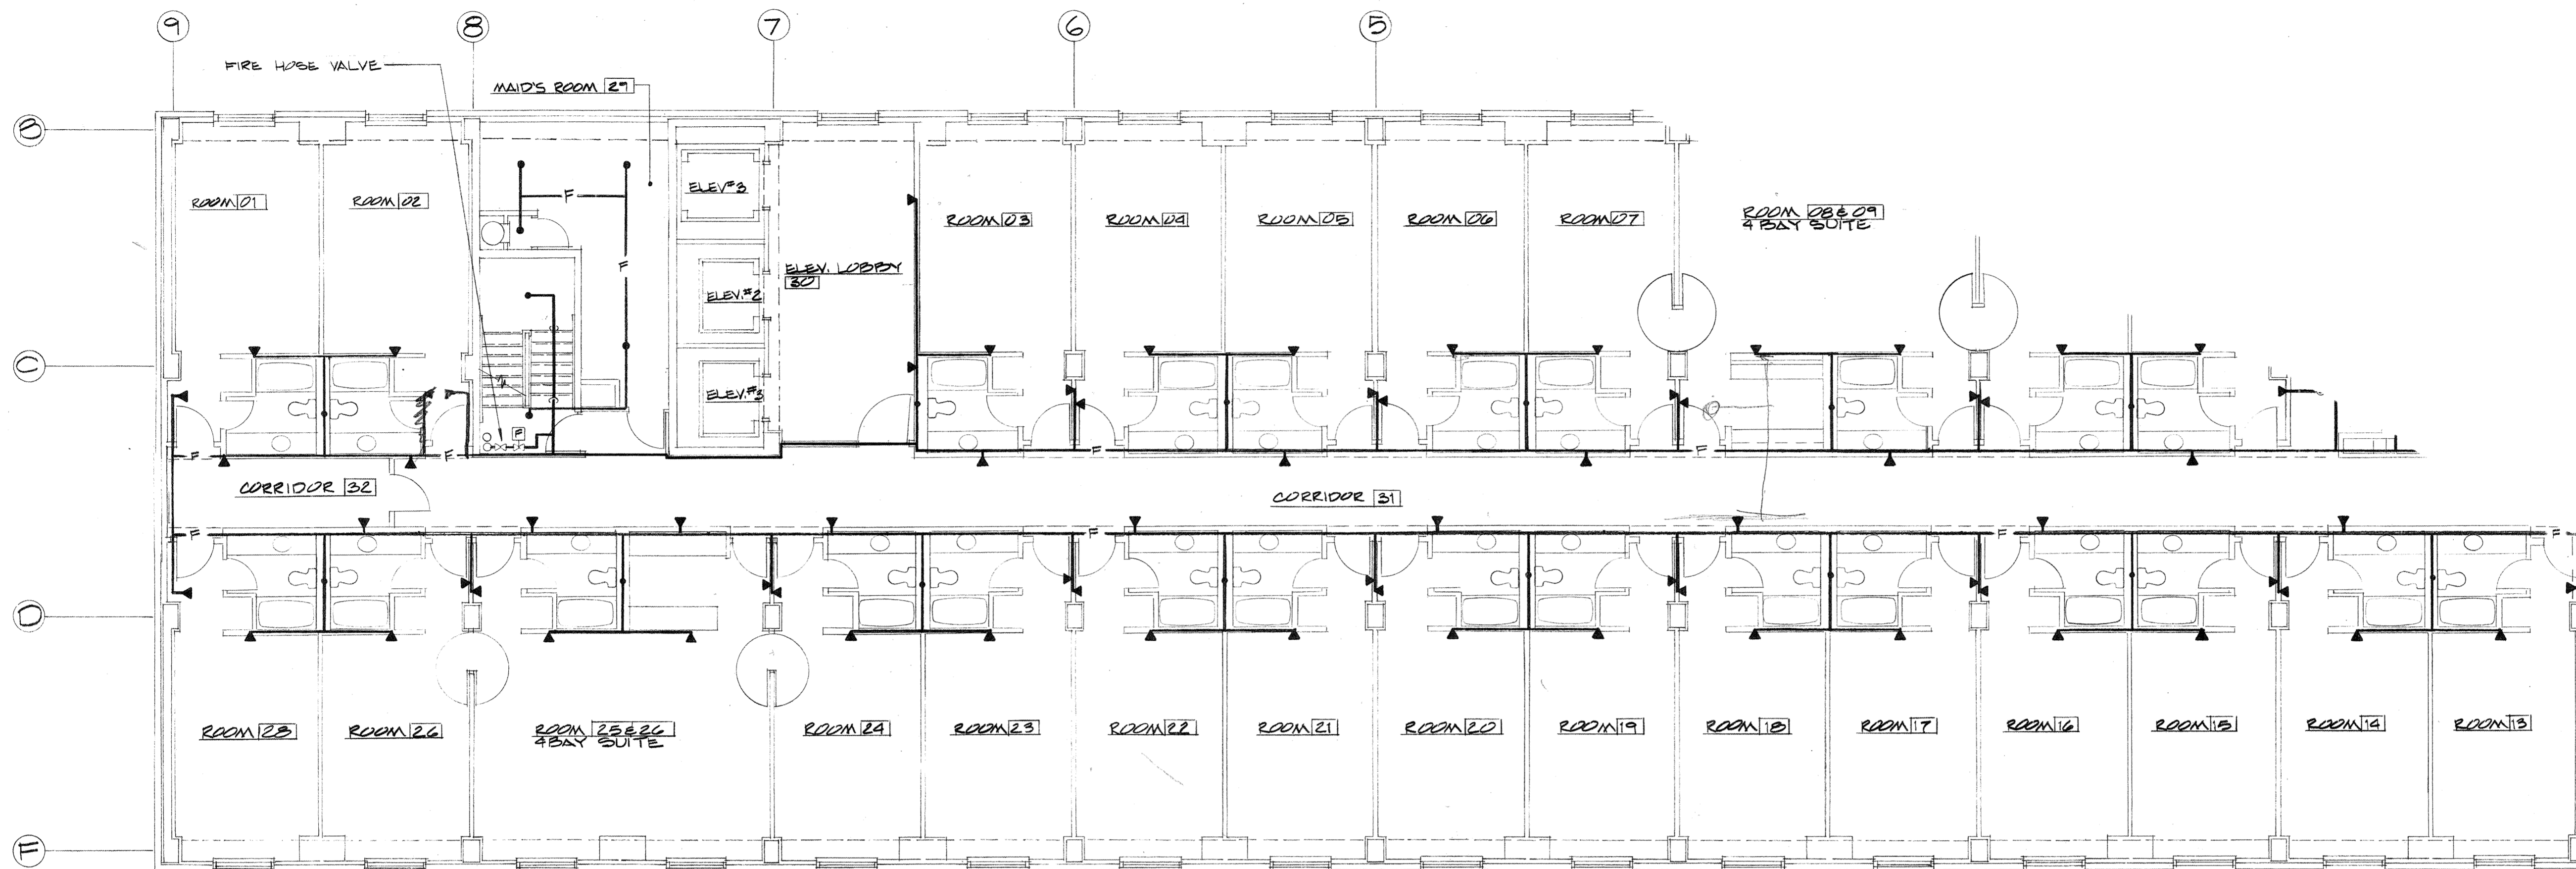


**SPRINKLER PLAN - 8<sup>TH</sup> FLOOR**  
SCALE: 1/8" = 1'-0"

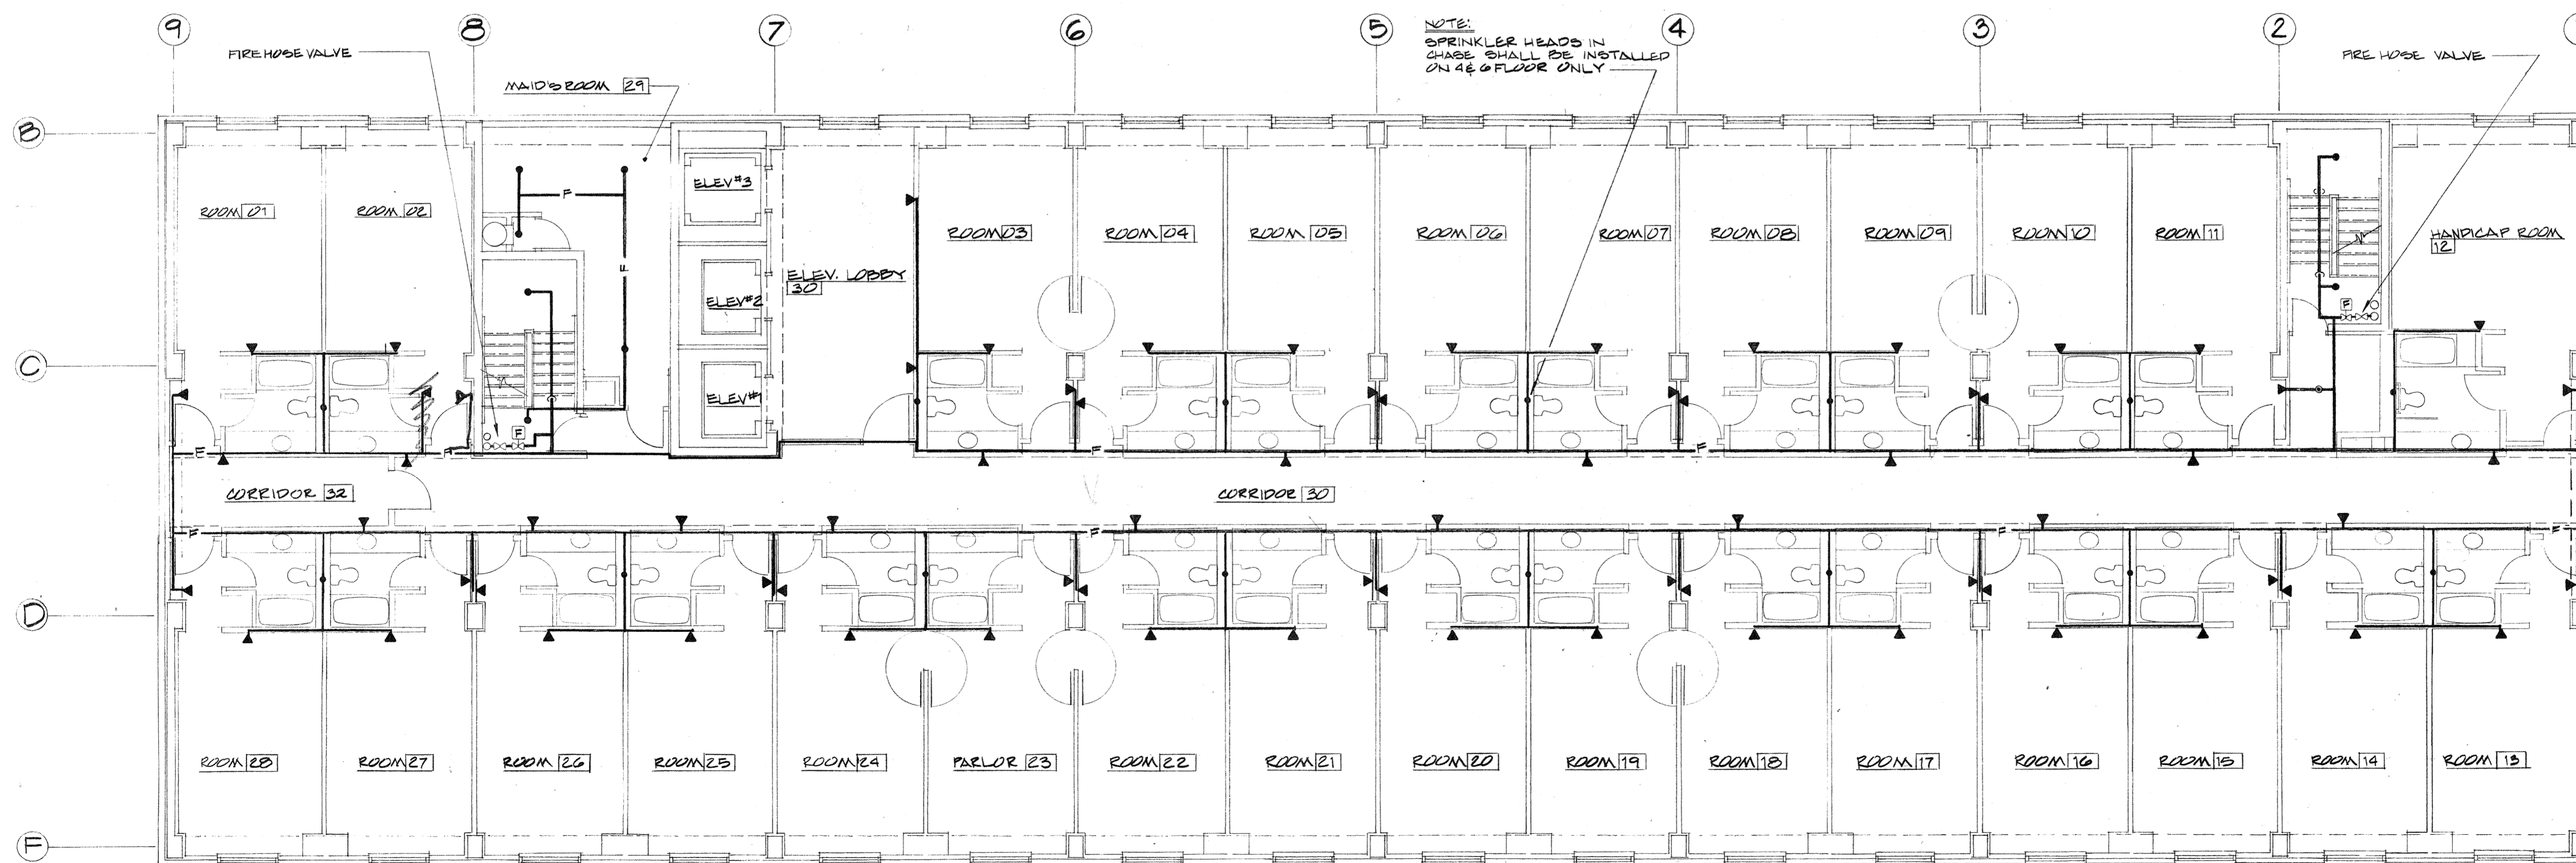

NOTE:  
SPRINKLER HEADS IN  
CHASE SHALL BE INSTALLED  
ON 4<sup>TH</sup> FLOOR ONLY

**SPRINKLER PLAN - 3<sup>RD</sup> THRU 7<sup>TH</sup> FLOORS**  
SCALE: 1/8" = 1'-0"


REVISIONS  
A7-27-83  
GENERAL REVISIONS LOCATED  
FIRE HOSE VALVE & LOCATED  
SPRINKLER HEADS IN PLUMBING  
CHASE

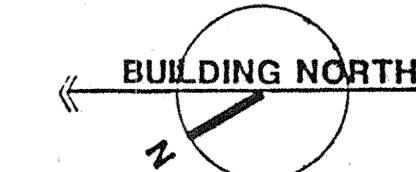


**CARTEF**

JOHNSON / ROMANOWITZ / ARCHITECTS / LEXINGTON / KENTUCKY

DRAWN B.H.	PROJECT
CHECKED	DATE 5-10-83
<b>SPRINKLER</b>	
SPRINKLER PLANS - 3RD THRU 7TH FLOORS & 8TH FLOOR	
REISSUED: 8-2-83	
<b>DRAWING SP-6</b>	

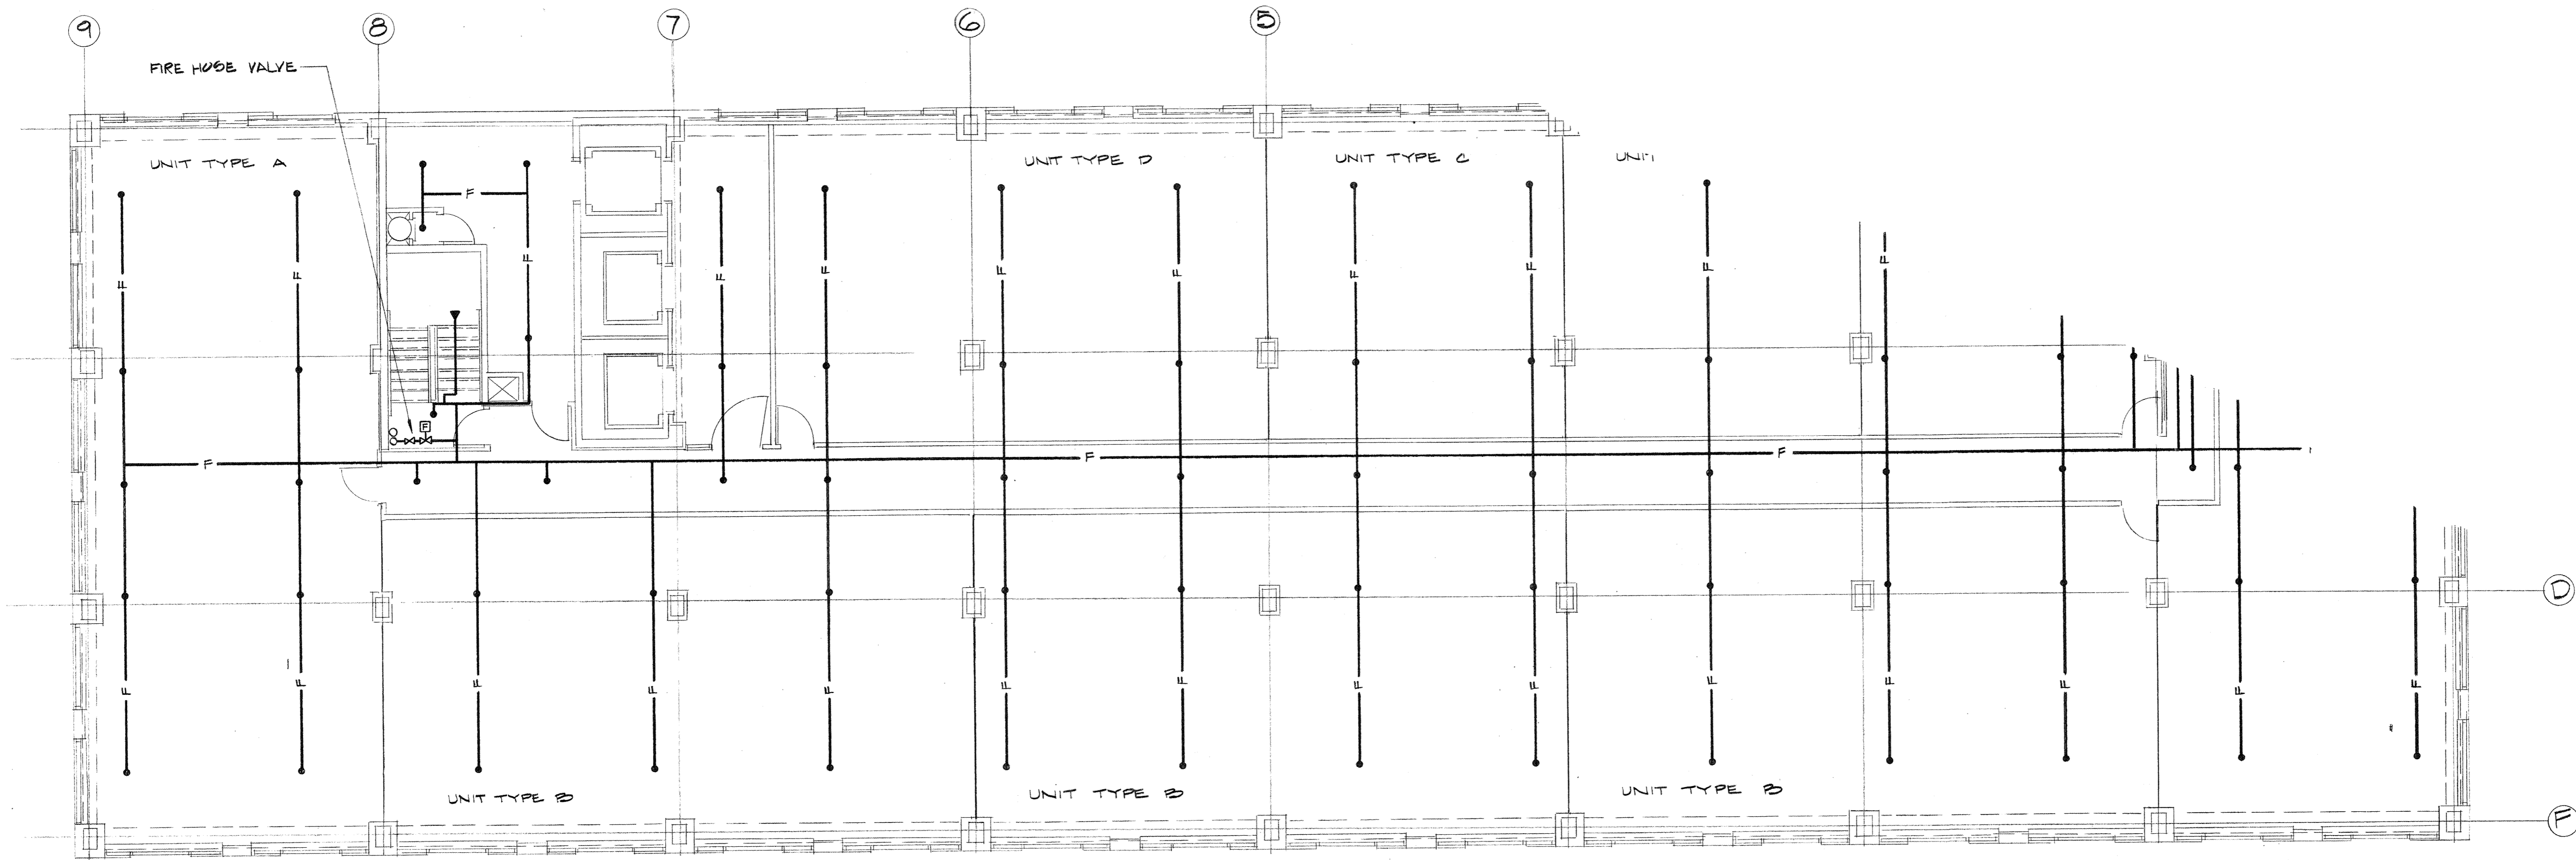


SPRINKLER PLAN - 9<sup>TH</sup> FLOOR - CONDOMINIUMS  
SCALE: 1/8" = 1'-0"

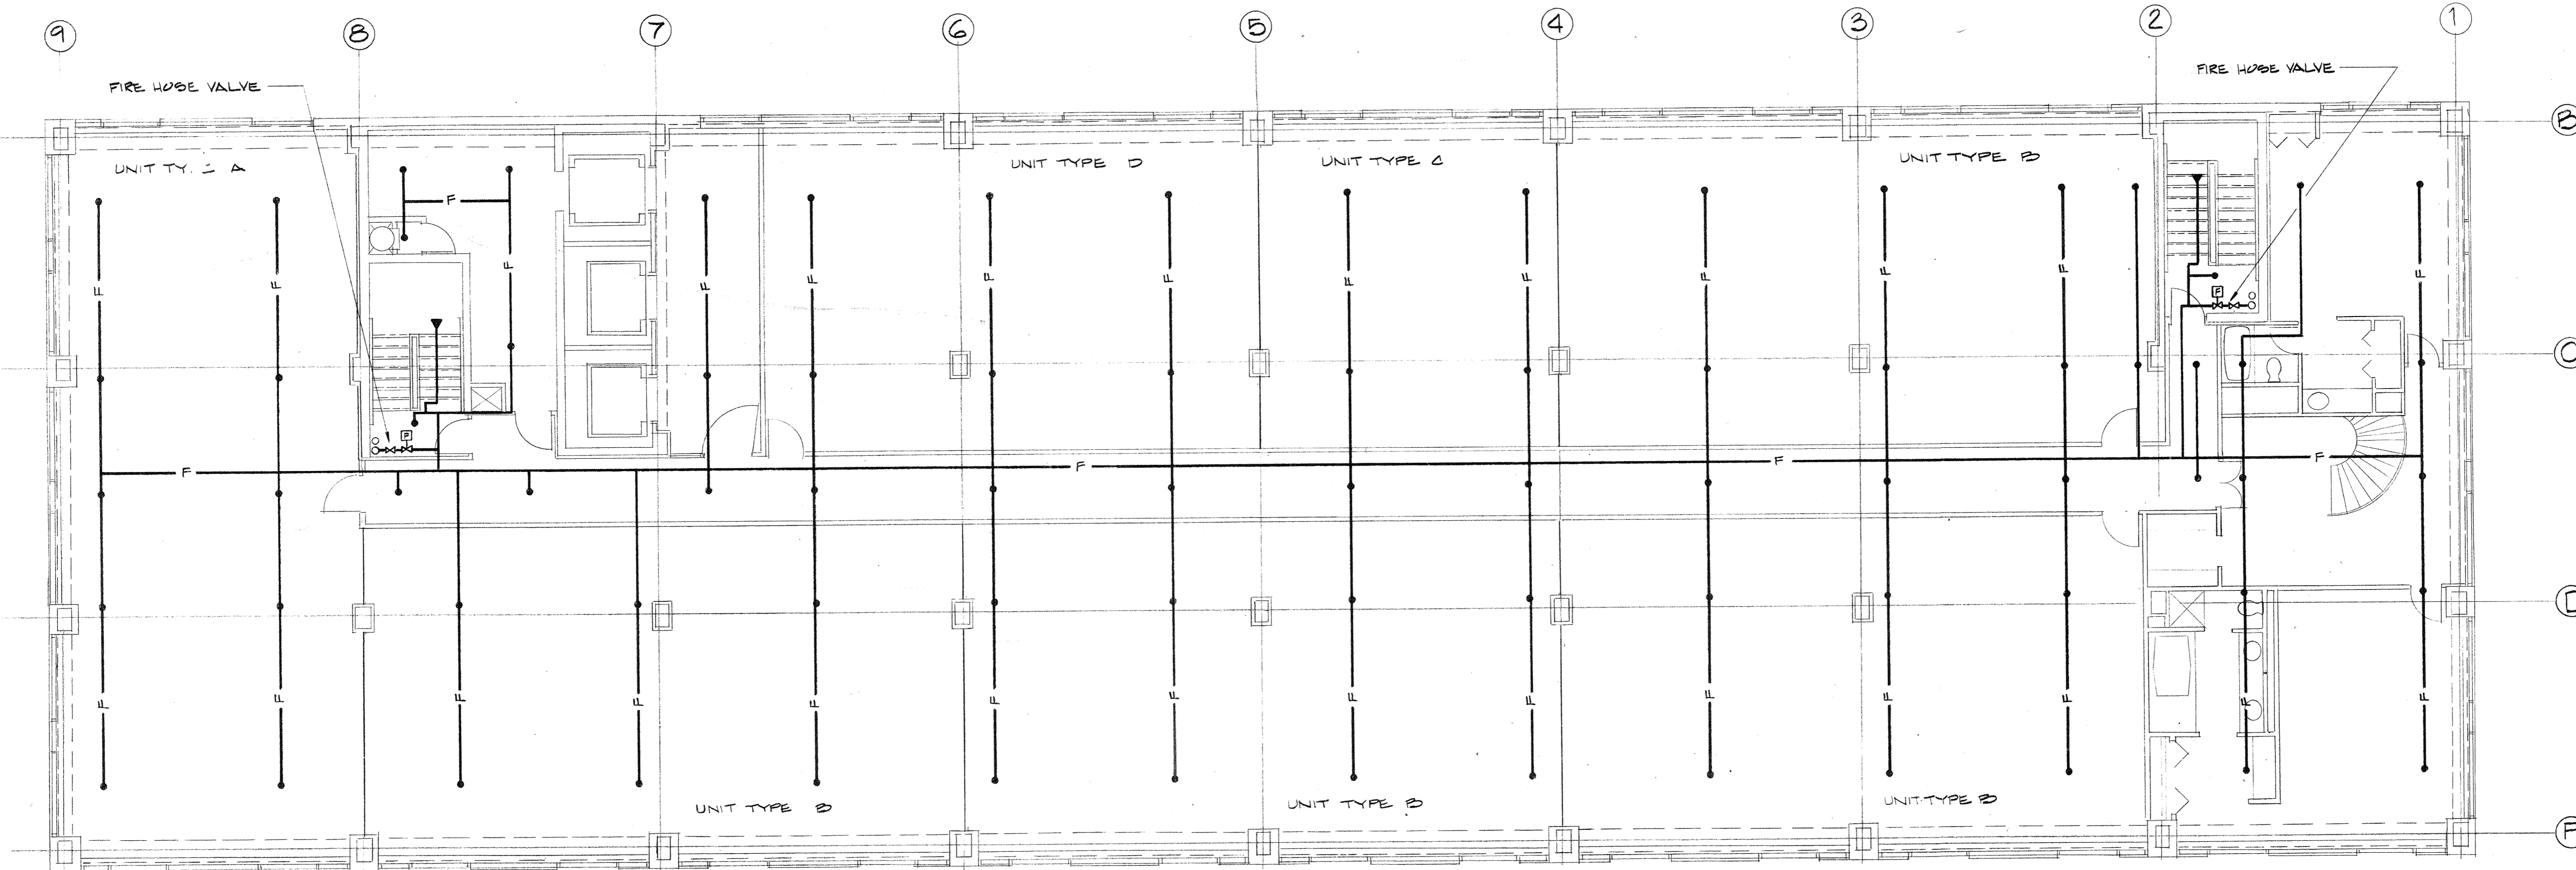

SPRINKLER PLAN - 10<sup>TH</sup> FLOOR - CONDOMINIUMS  
SCALE: 1/8" = 1'-0"

REVISIONS  
 ▲ 7-27-83  
 GENERAL REVISION  
 LOCATED FIRE HOSE  
 VALVE

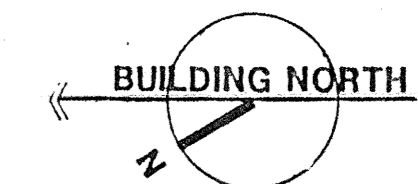

CART

STATE OF KENTUCKY REGISTERED PROFESSIONAL ARCHITECT  
 TAGART FOSTER 6520

STATE OF KENTUCKY REGISTERED PROFESSIONAL ARCHITECT  
 O. GUY CARTER 6517

**JR**

JOHNSON / ROMANOWITZ / ARCHITECTS / LEXINGTON / KENTUCKY  
 301 EAST VINE STREET, SUITE A  
 TELEPHONE (606) 252-6781

DRAWN B. H.	PROJECT
CHECKED	DATE 5-10-83
<b>SPRINKLER</b>	
SPRINKLER PLAN - 9 <sup>TH</sup> AND 10 <sup>TH</sup> FLOOR - CONDO'S	
REISSUED 8-2-83	
<b>DRAWING</b> <b>SP-7</b>	