
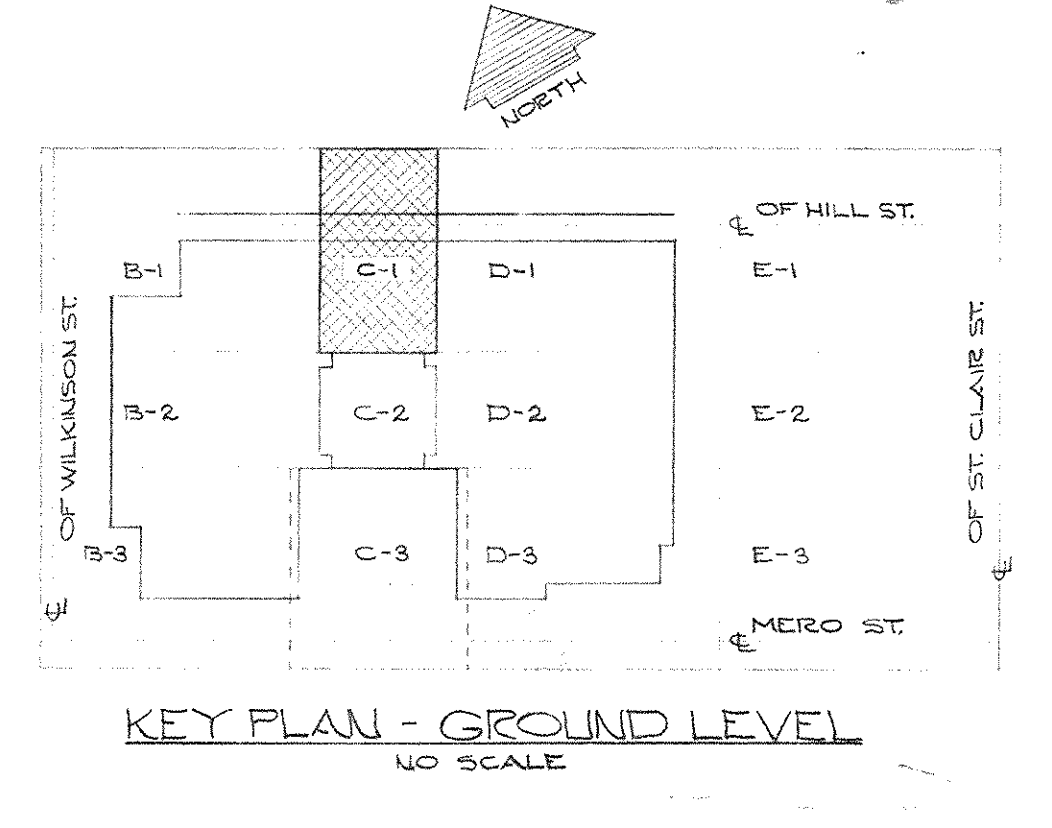
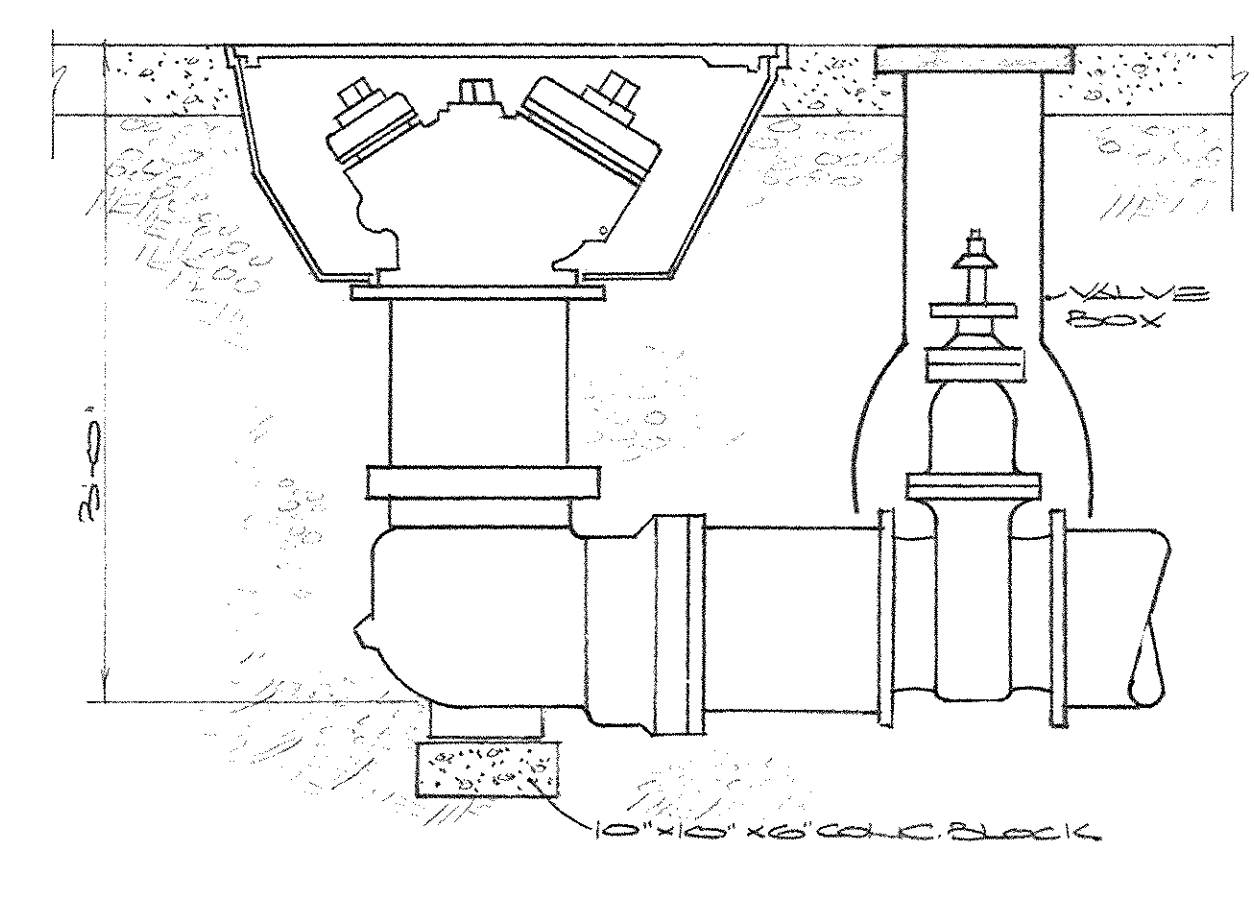
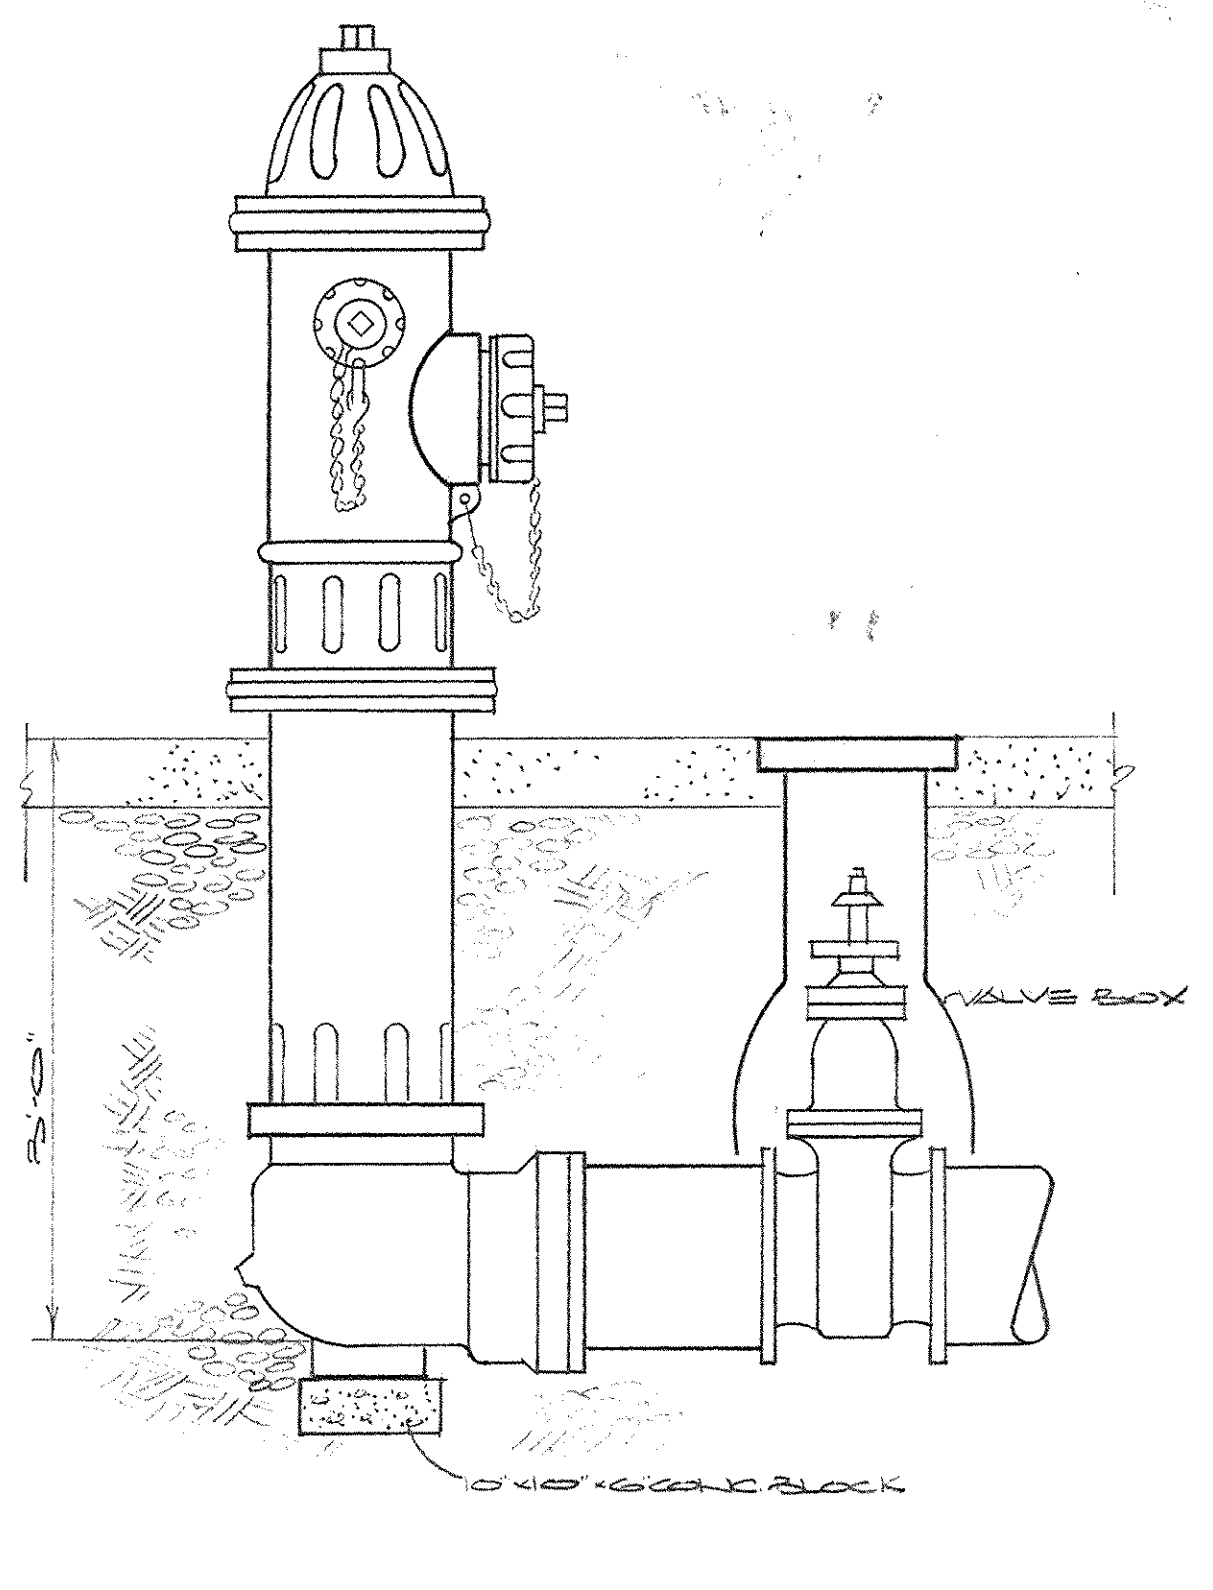
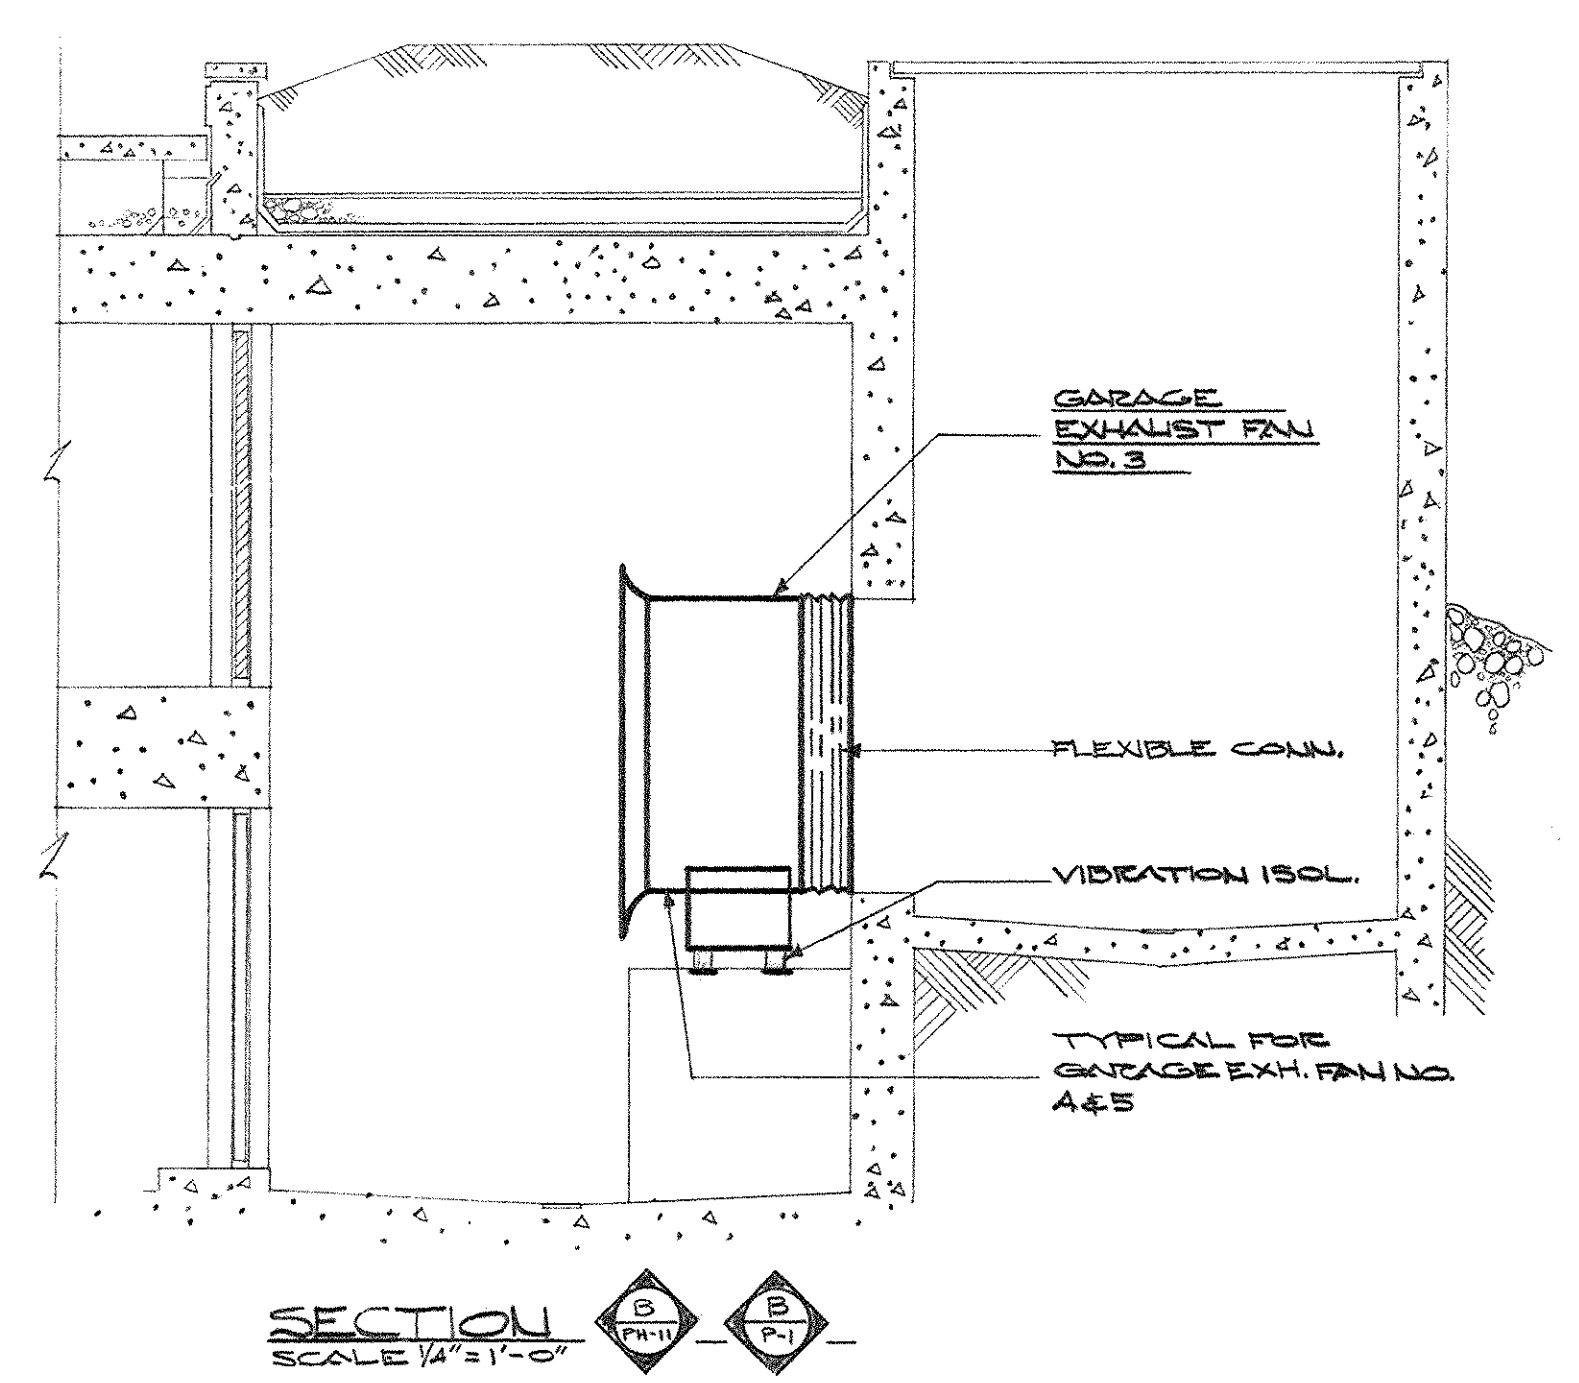
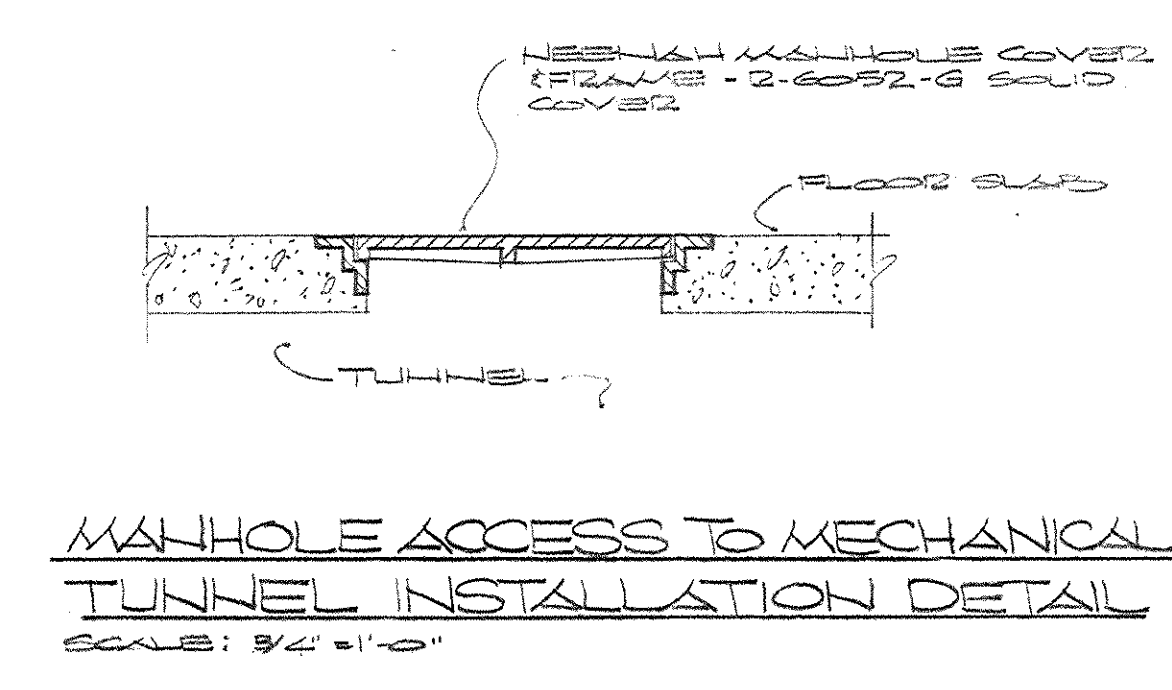
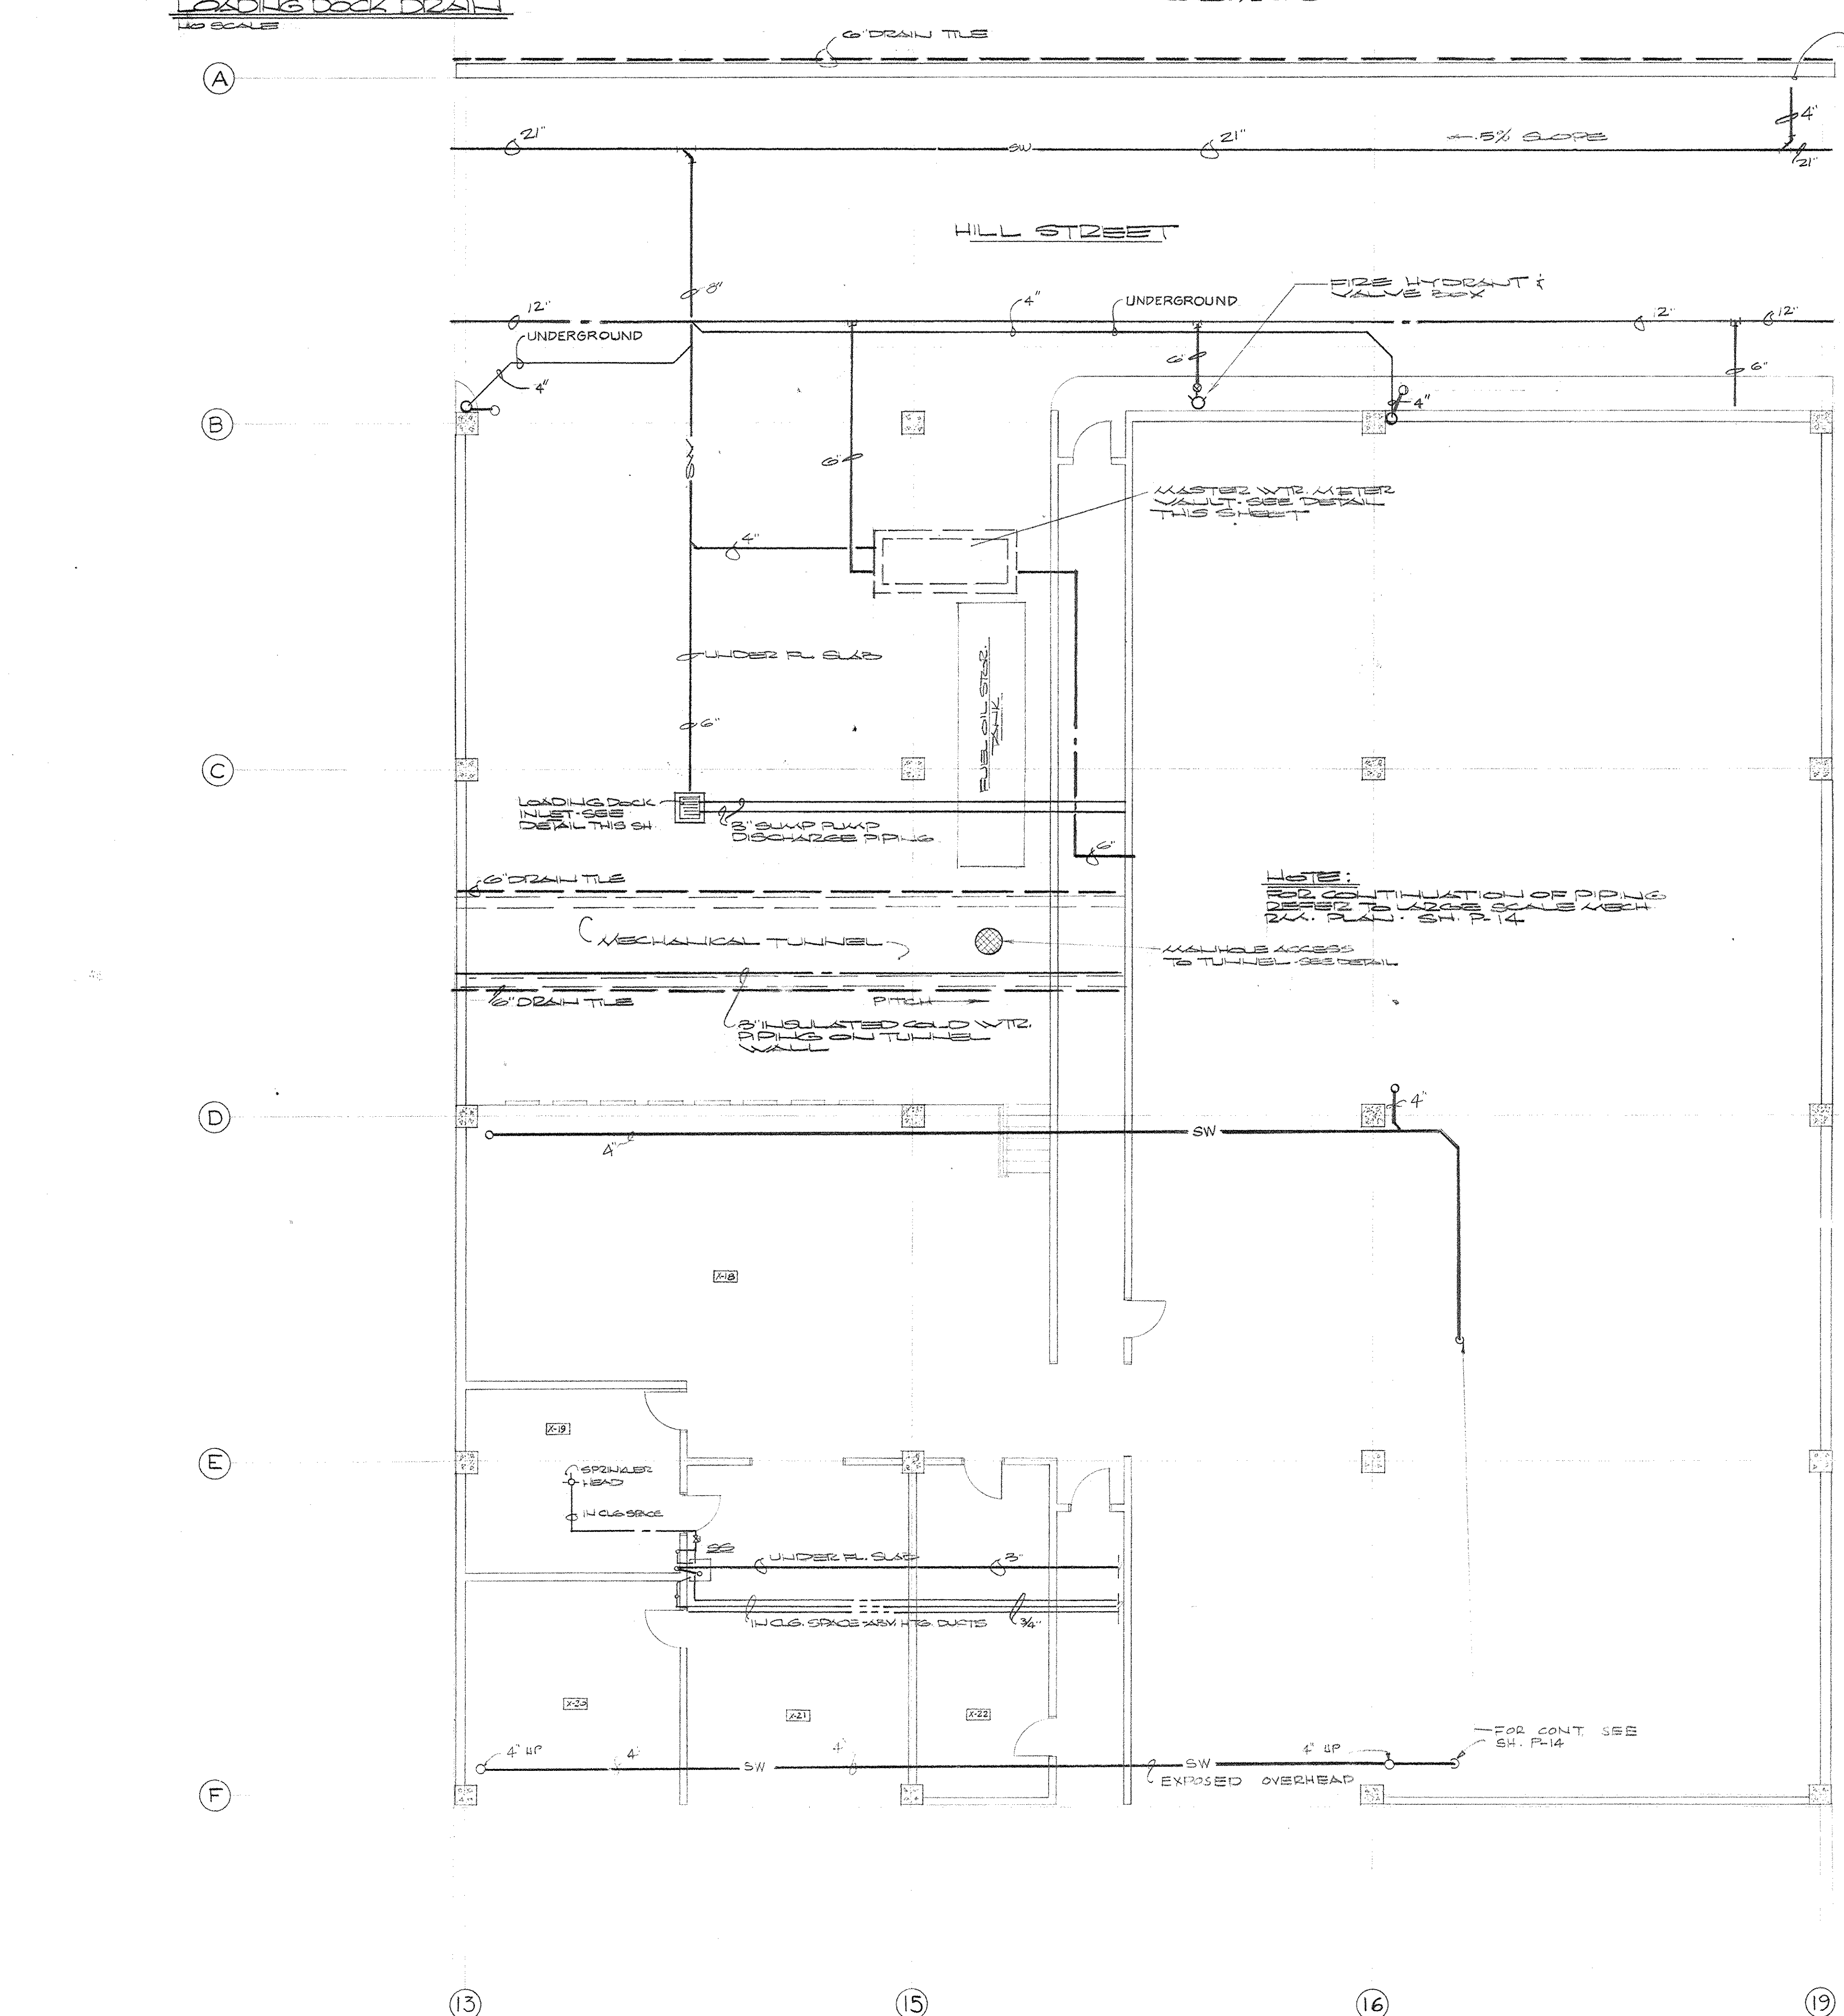
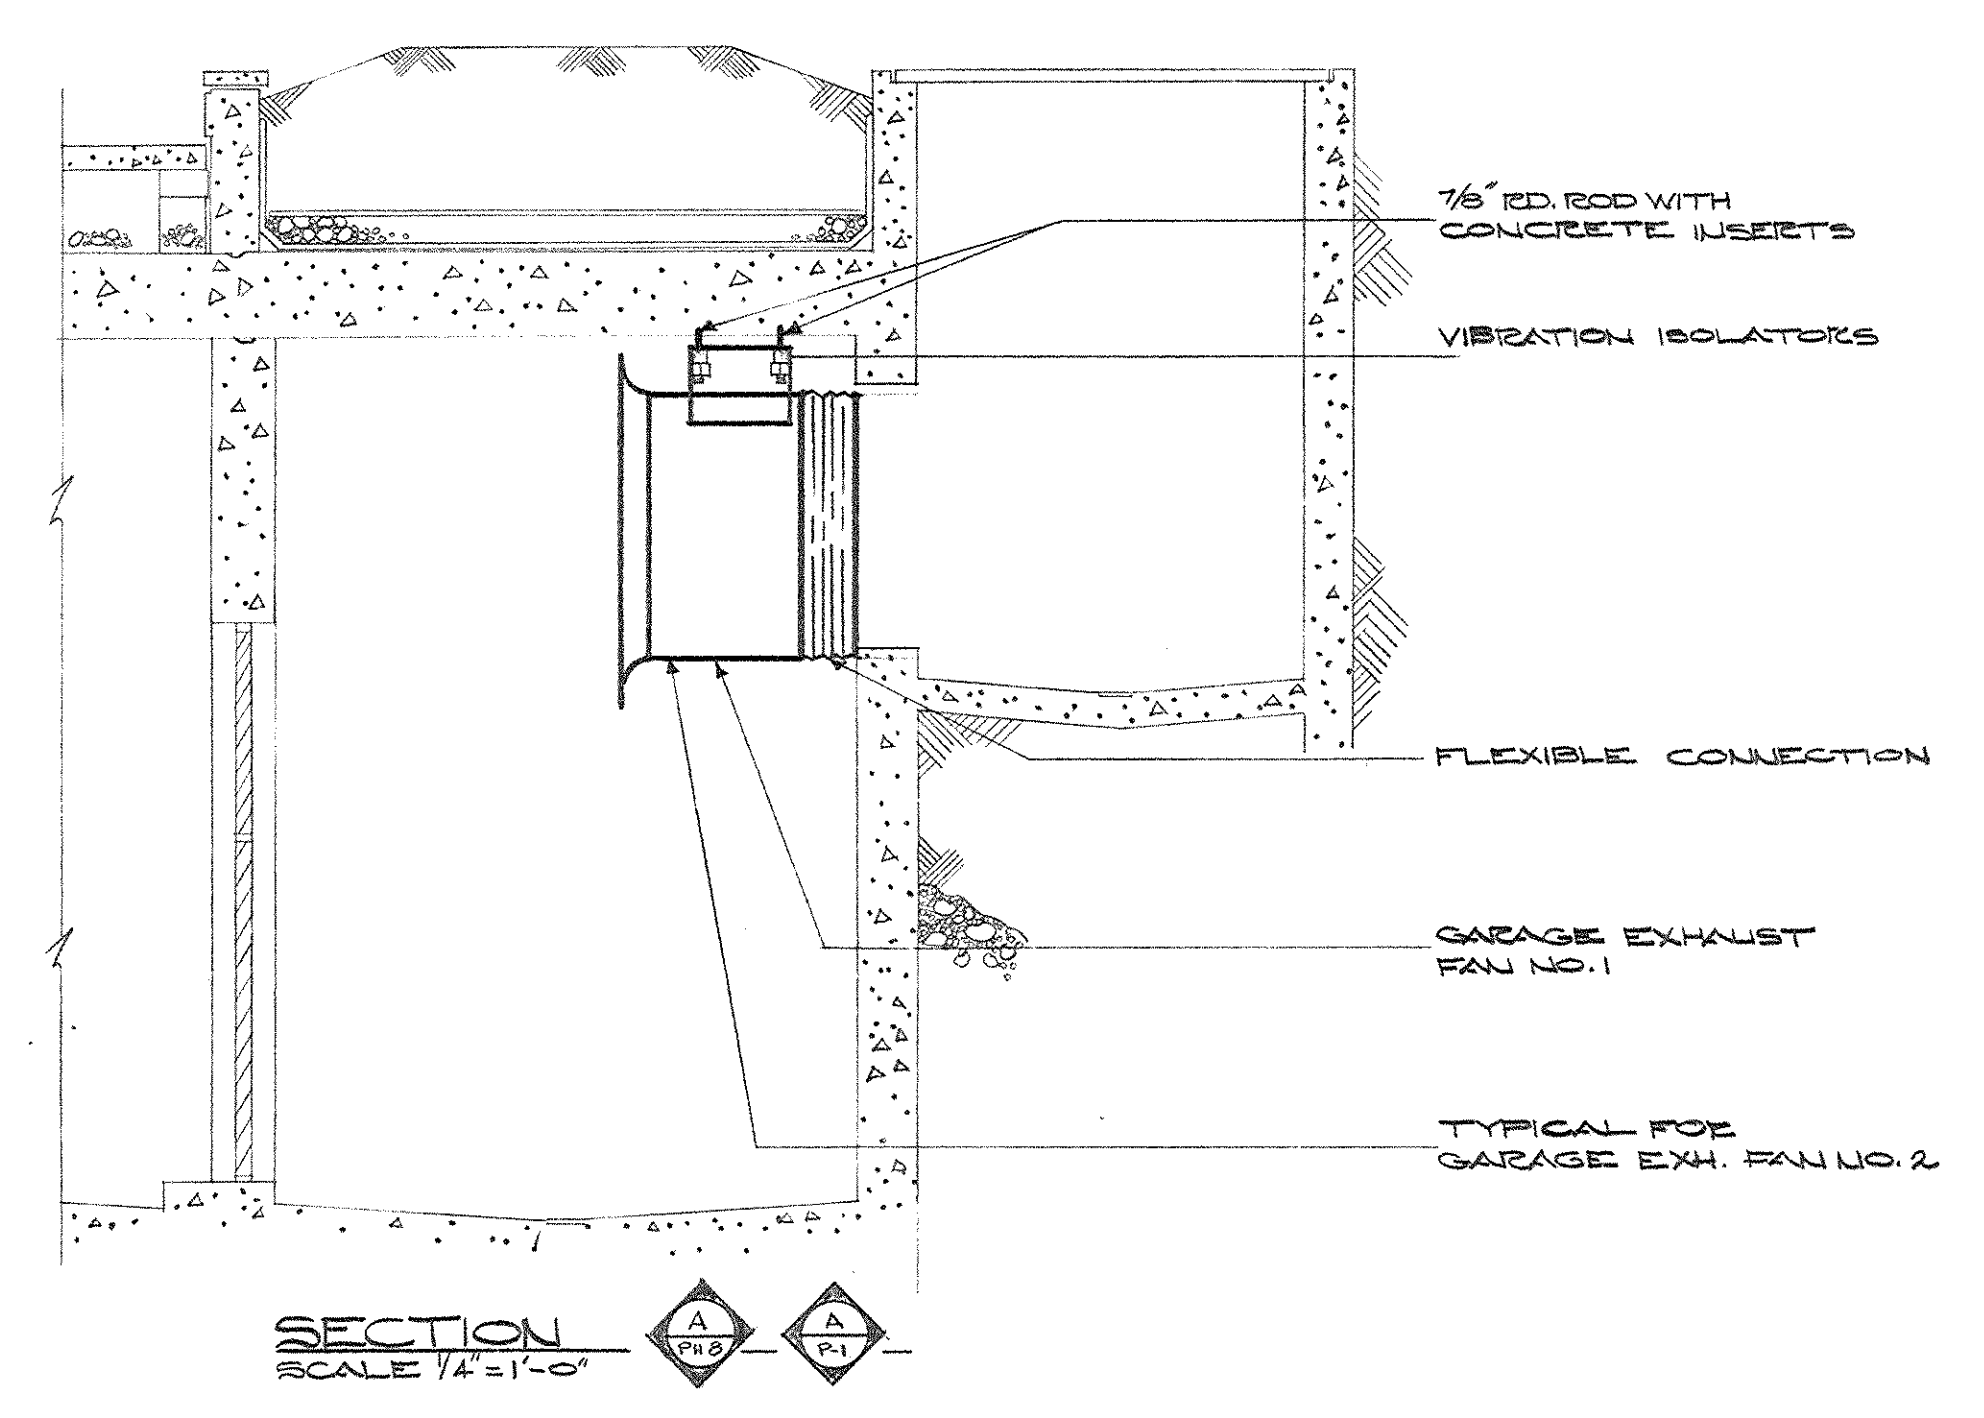


OFFICE DWG NO	ARCH DWG NO	BLD'G SECTOR	NAME OF BUILDING	TITLE OF DRAWING	BRANCH OF WORK	DRAWN BY	DATE	REMARKS
CPA-165	PH-16	E-3	Capital Plaza Office Bldg Frankfort Ky.	Plumbing & Ventilating Plan - Mezzanine Level	Mechanical & Elect	D S	7/15/77	See Factor Smith & Assoc
166	PH-17	E-1		Plan - Plaza Level				
"	167	PH-18		" " " "				
168	PH-19	R-3		" " " "				
"	169	PH-20		" " " "				
170	PH-21	C-3		" " " "				
171	PH-22	D-1		" " " "				
"	172	PH-23		" " " "				
73	PH-24	D-3		" " " "				
173	PH-25	E-1		" " " "		D S		
174	PH-26	E-2		" " " "		SHIFT		
175	PH-27	E-3		" " " "				
176	PH-28	C-3		Arrival Court Fountain Plan & Diagrams				
"	178	PH-29		St. Clair Street " " "				
"	179	PH-30		Hill Street " " "				
180	PH-31	A-1		Cooling Tower Plan & Details				
181	P-1	C-1		Plumbing Plan - Ground Level				D S C
"	182	P-2		" " " "				SHIFT
183	P-3	C-2		" " Mezzanine Level				
184	P-4	C-2		" " Lobby Level				
185	P-5	C-2		" " Floor 13 A				
186	P-6	C-2		" " Penthouse & Roof				
37	P-7	C-2		Office Cores				
188	P-8			Sanitary Waste & Vent Diagram				
189	P-9			Sanitary Waste & Vent Diagram				
190	P-10			Sanitary Waste & Vent Diagram				
191	P-11			Domestic Water Piping Diagram				
192	P-12			" " " "				
193	P-13			" " " "				
194	P-14			Mechanical Room Plans - Diagrams				
195	H-1	C-1		Heating & Air Conditioning Plan - Ground Level	M.E.C.H.			T F
196	H-2	C-2		" " " " " "				T F
197	H-3	C-2		" " " " " Mezzanine Level				
198	H-4	C-2		" " " " " Lobby Level				
CPA 199-203	H-5	C-2	<i>overseas</i>	" " " " " Floors thru 12 & 15 thru 23				
200	H-6	C-2		" " " " " 11th Floor				
201	H-7	C-2		" " " " " 21st Floor				
202	H-8	C-2		" " " " " Roof & Penthouse				
"	203	H-9		Enlarged Core Plan				
204	H-10	C-2		Enlarged Core Plan & Details				
205	H-11	C-1		Enlarged Mechanical Room Plan				D S C

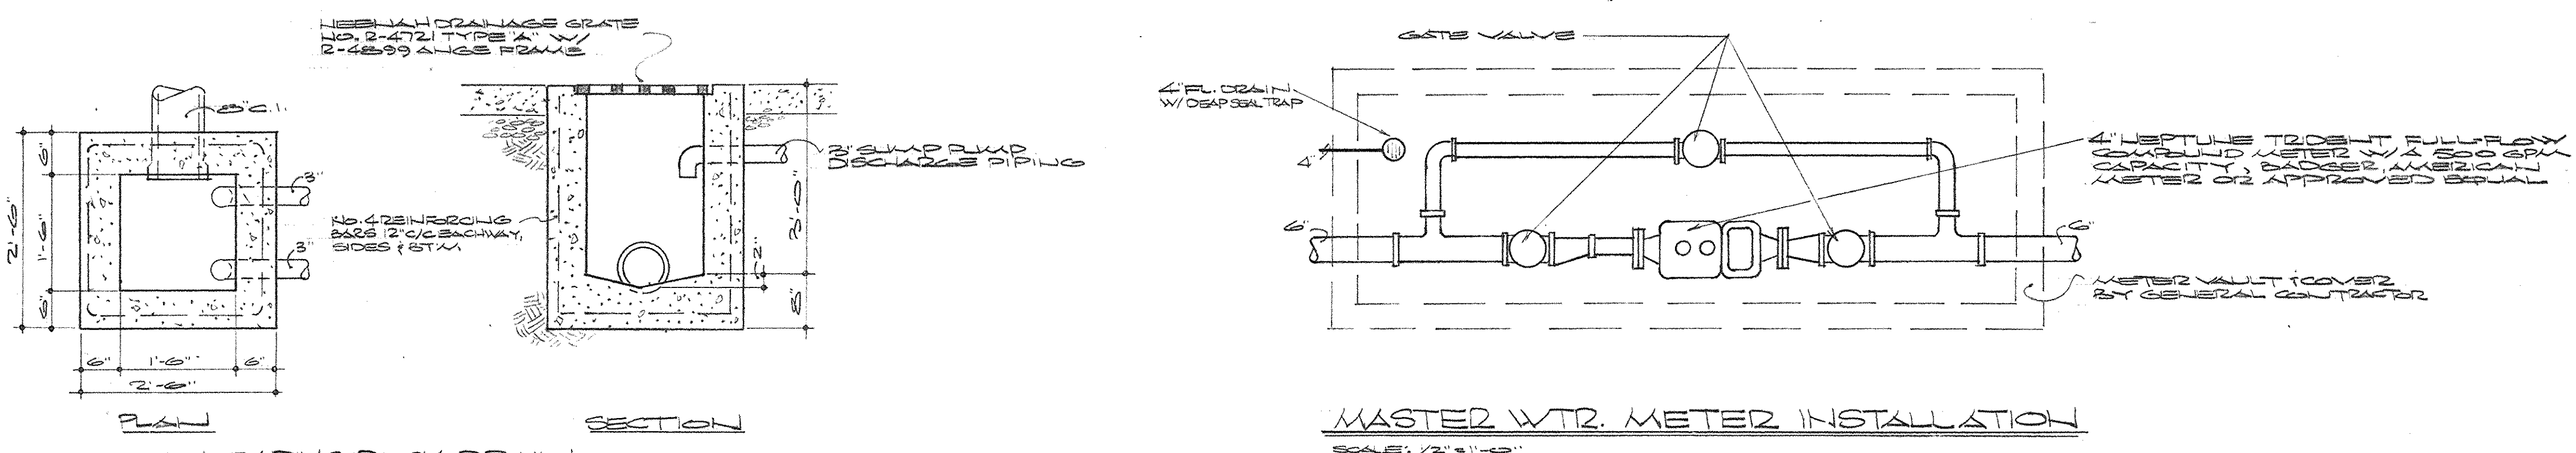


PLUMBING PLAN - GROUND LEVEL - SECTOR C-1
SCALE - 1/8" = 1'-0"

STANDARD
FIRE HYDRANT INSTALLATION DETAILS
NO SCALE


FLUSH MOUNTED
FIRE HYDRANT INSTALLATION DETAILS
NO SCALE

NOTE
PLUMBING DVGS. SUPPLEMENTED BY THE INCLUSION OF
THE FOLLOWING:
1 CHANGE ORDER DVG. NO 40 ITEM NO 2 DATED MAY 71
2 CHANGE ORDER DVG. NO 6 ITEM NO 2 DATED 21 FEB 69


AS-BUILT DRAWINGS
DATE: JAN 73
HUGG, CARTER & ELDERMAN, INC.

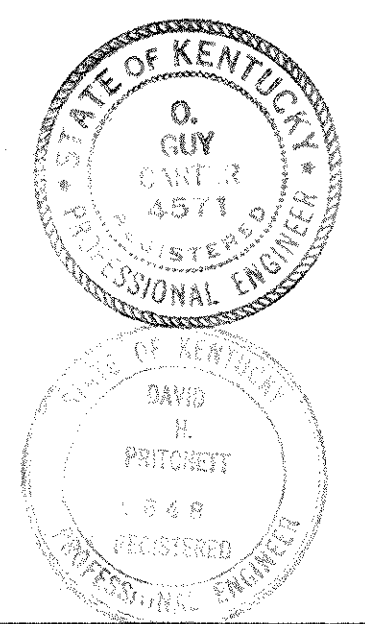


CAPITAL PLAZA OFFICE BUILDING		
FRANKFORT, KENTUCKY		
DRAWN BY C.S.C. P.D.S.	PLUMBING PLAN - GROUND LEVEL - SECTOR C-1	DATE 18, MAY, 1967
TRACED BY D.S.	SCALE 1/8" = 1'-0"	DRAWING NO. 50066
CHECKED BY S.M.F.	EDWARD DARELL STONE 7 EAST 67TH STREET NEW YORK, N. Y.	ASSOCIATE ARCHITECTS & ENGINEERS LEE POTTER SMITH & ASSOCIATES FRANKFORT, KENTUCKY
SECTOR NO. G 1	314 WILKINSON COMMONWEALTH OF KENTUCKY DEPARTMENT OF FINANCE - ENGINEERING STAFF FRANKFORT, KENTUCKY	P 1 OF 14
APPROVED BY ARCHITECT	DATE	
APPROVED BY AGENCY HEAD	DATE	MAY 2 & 1967
APPROVED BY OWNER	DATE	

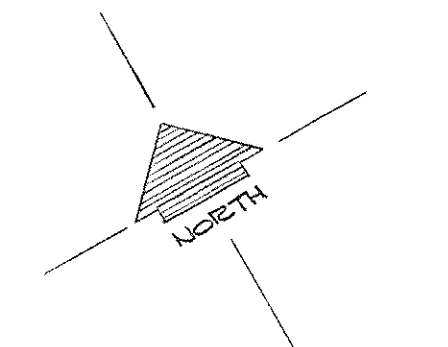


NOTE:
MECHANICAL WORK IN THIS
HAS BEEN REVISED - SEE
CHANGE ORDER NO. 8, ITEM
NO. 2, SHEET 1 OF 2.

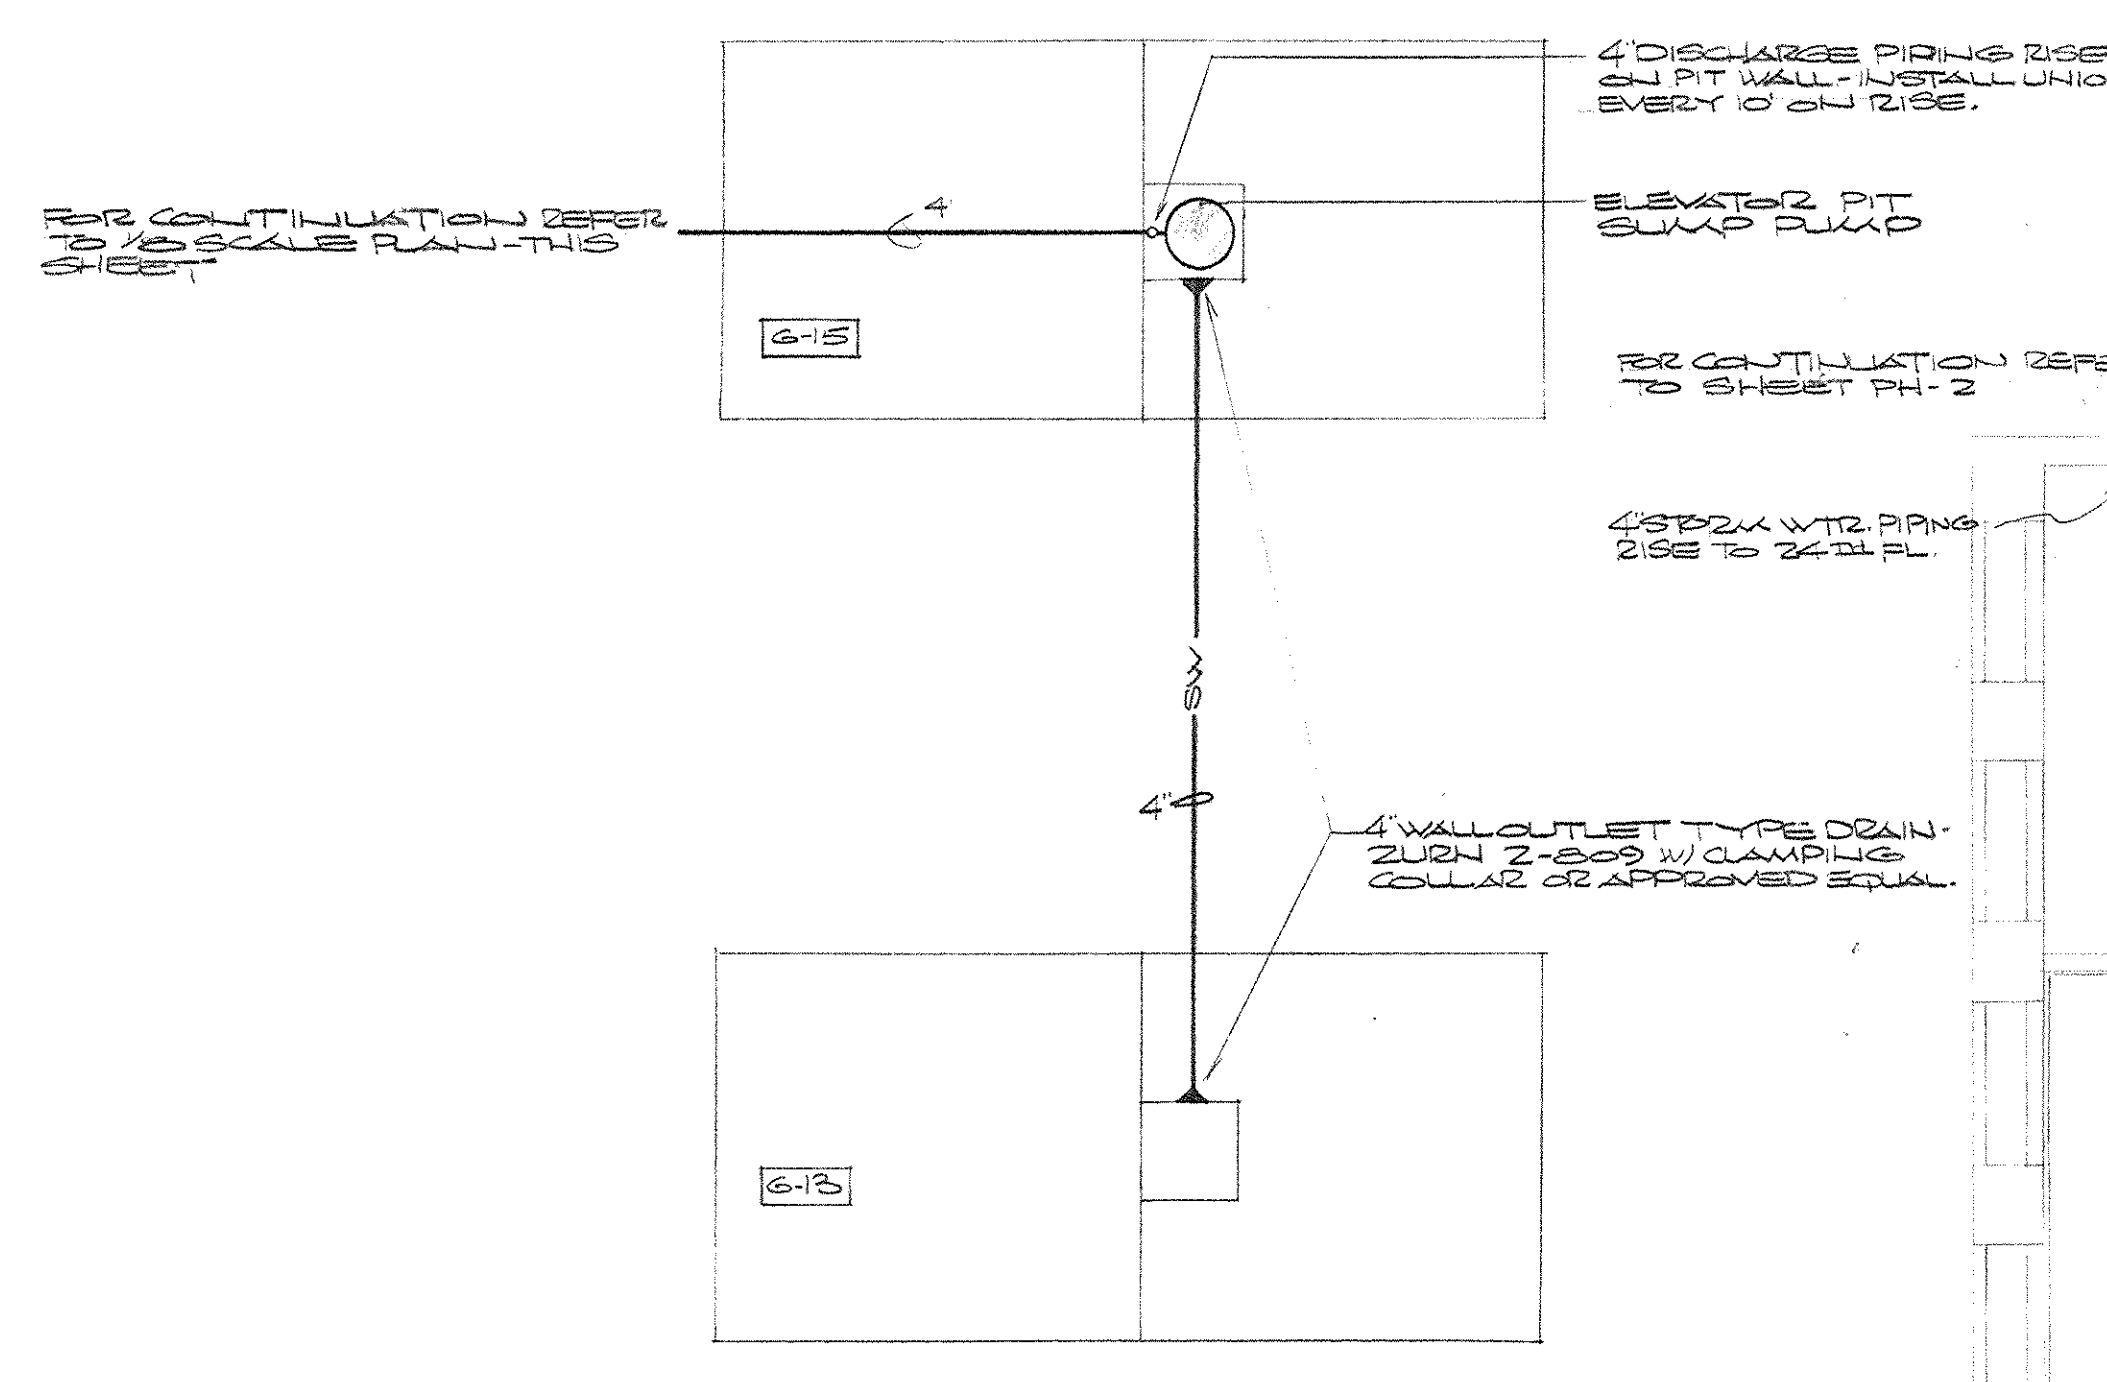

ELEVATOR PIT PLAN
SCALE: 1/4" = 1'-0"


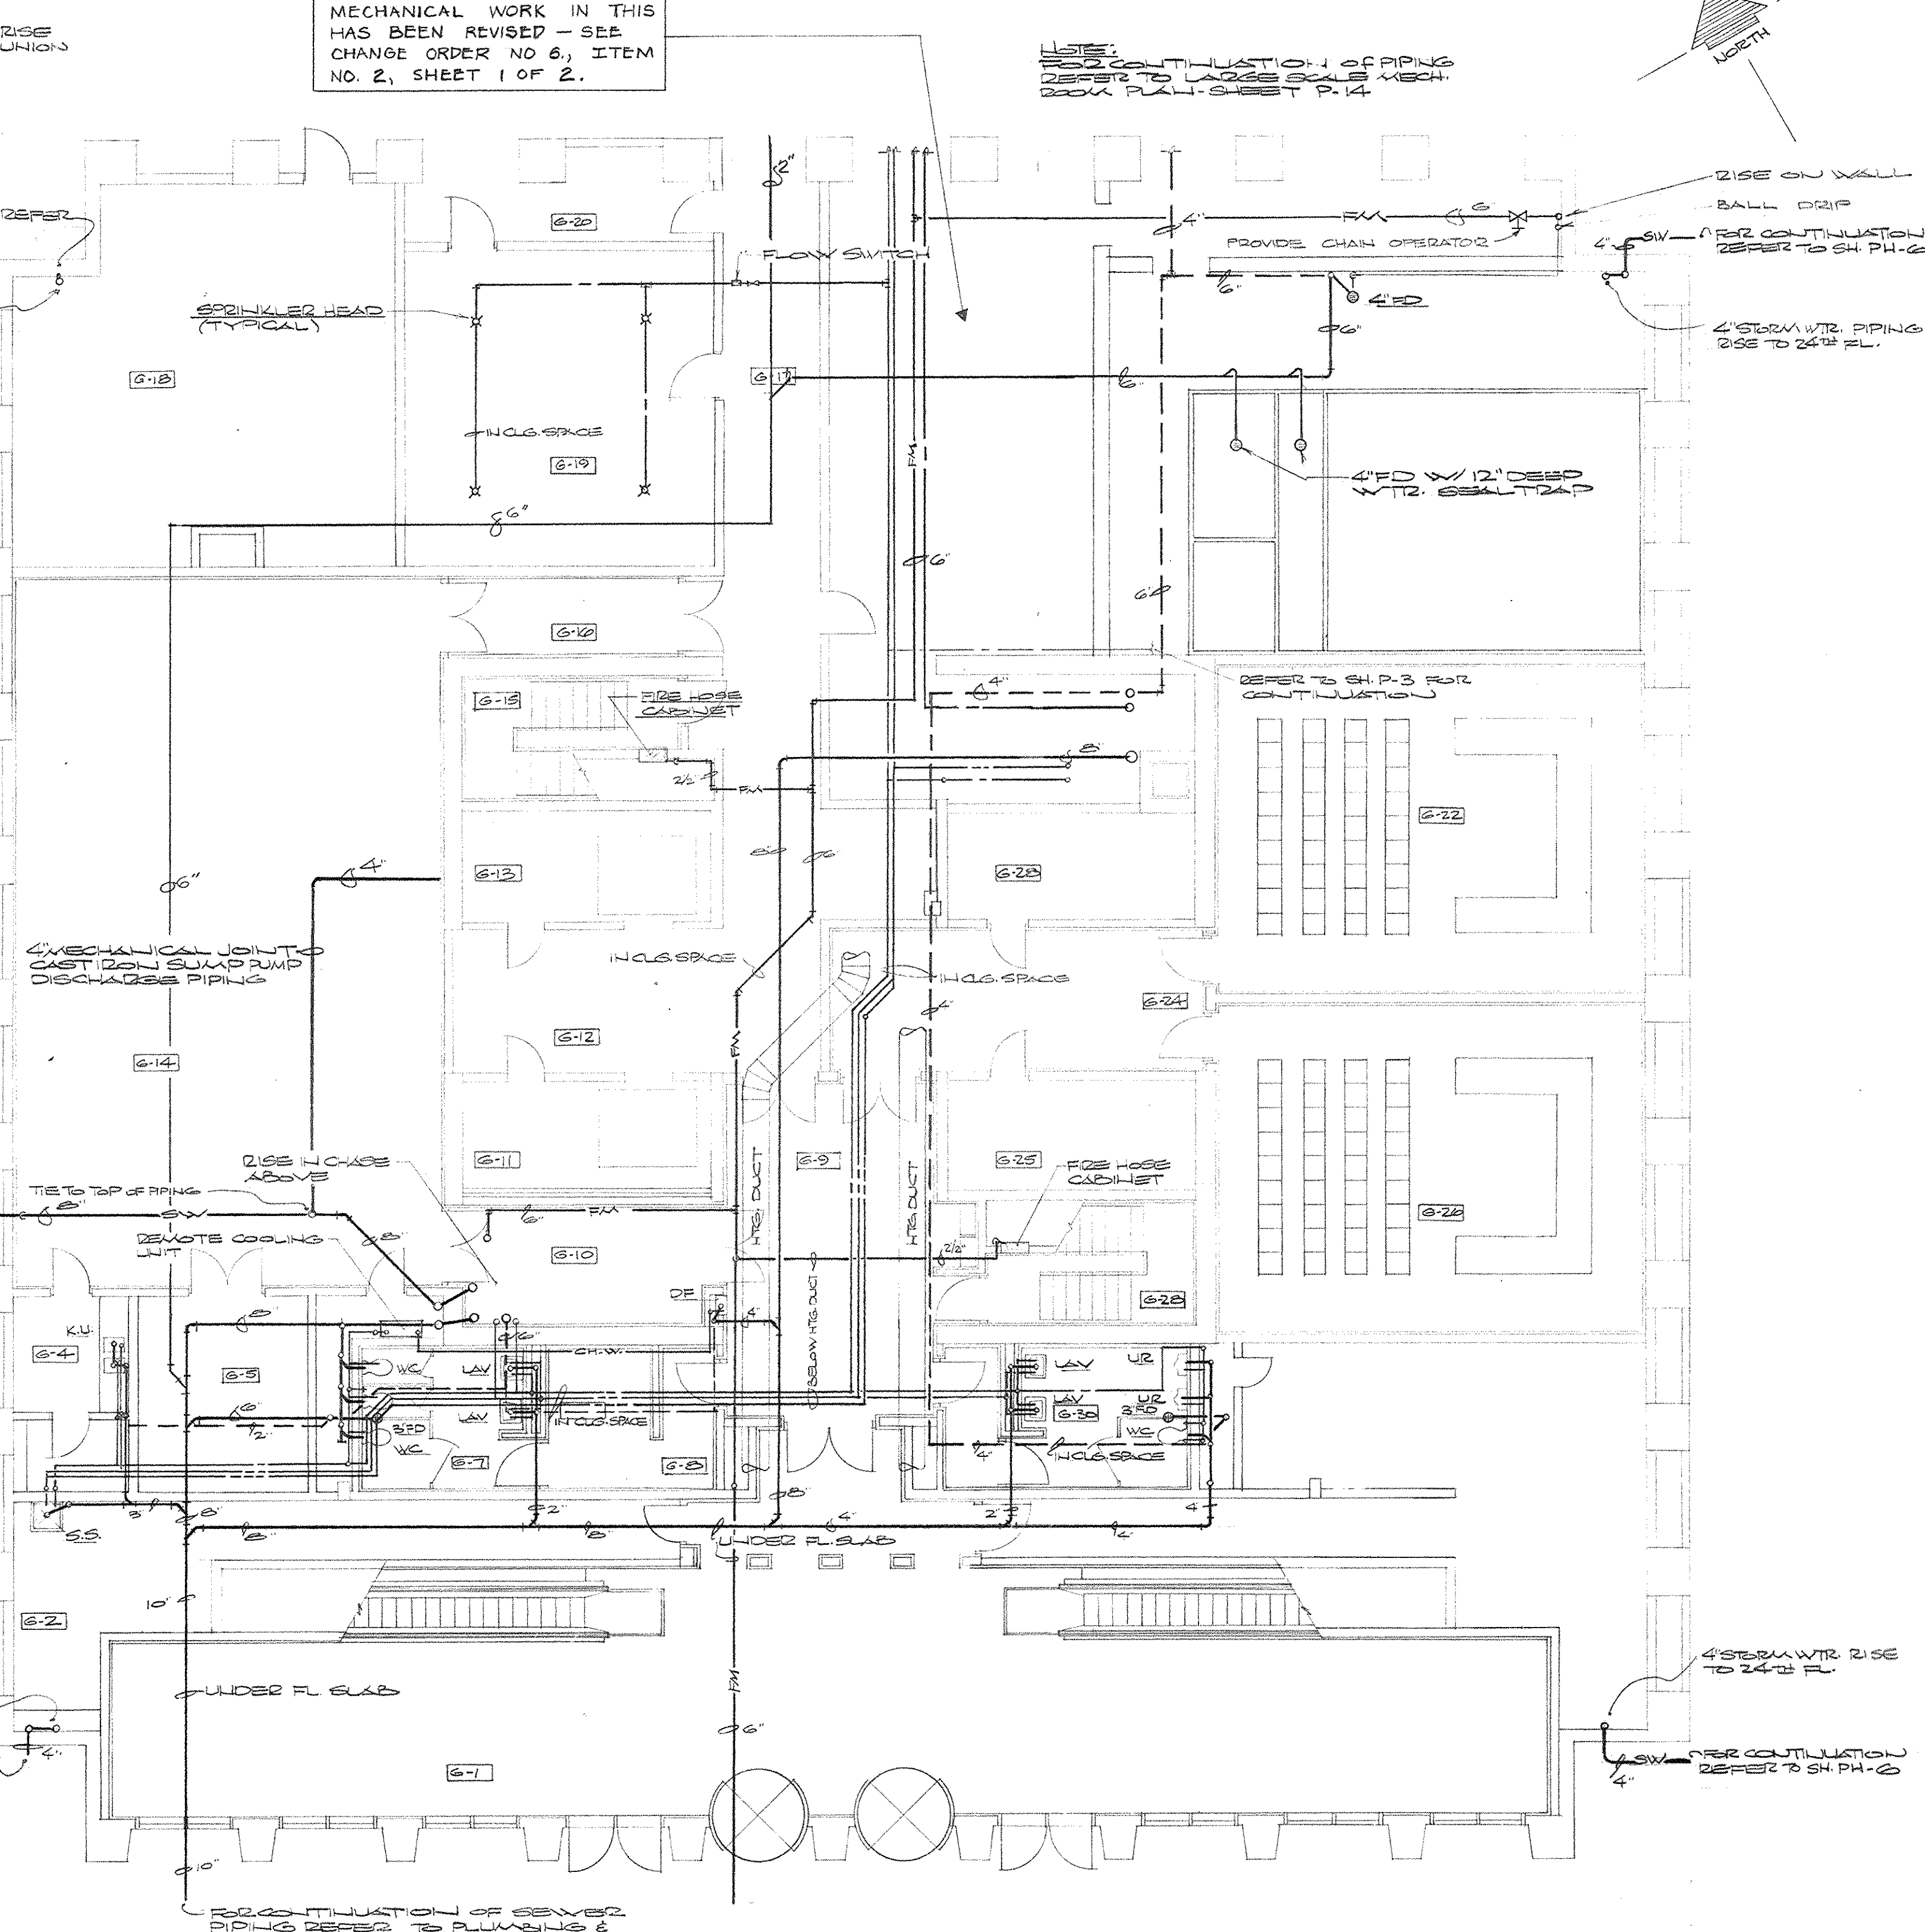


PLUMBING PLAN-GROUND LEVEL-SECTION C-2
SCALE: 1/8" = 1'-0"

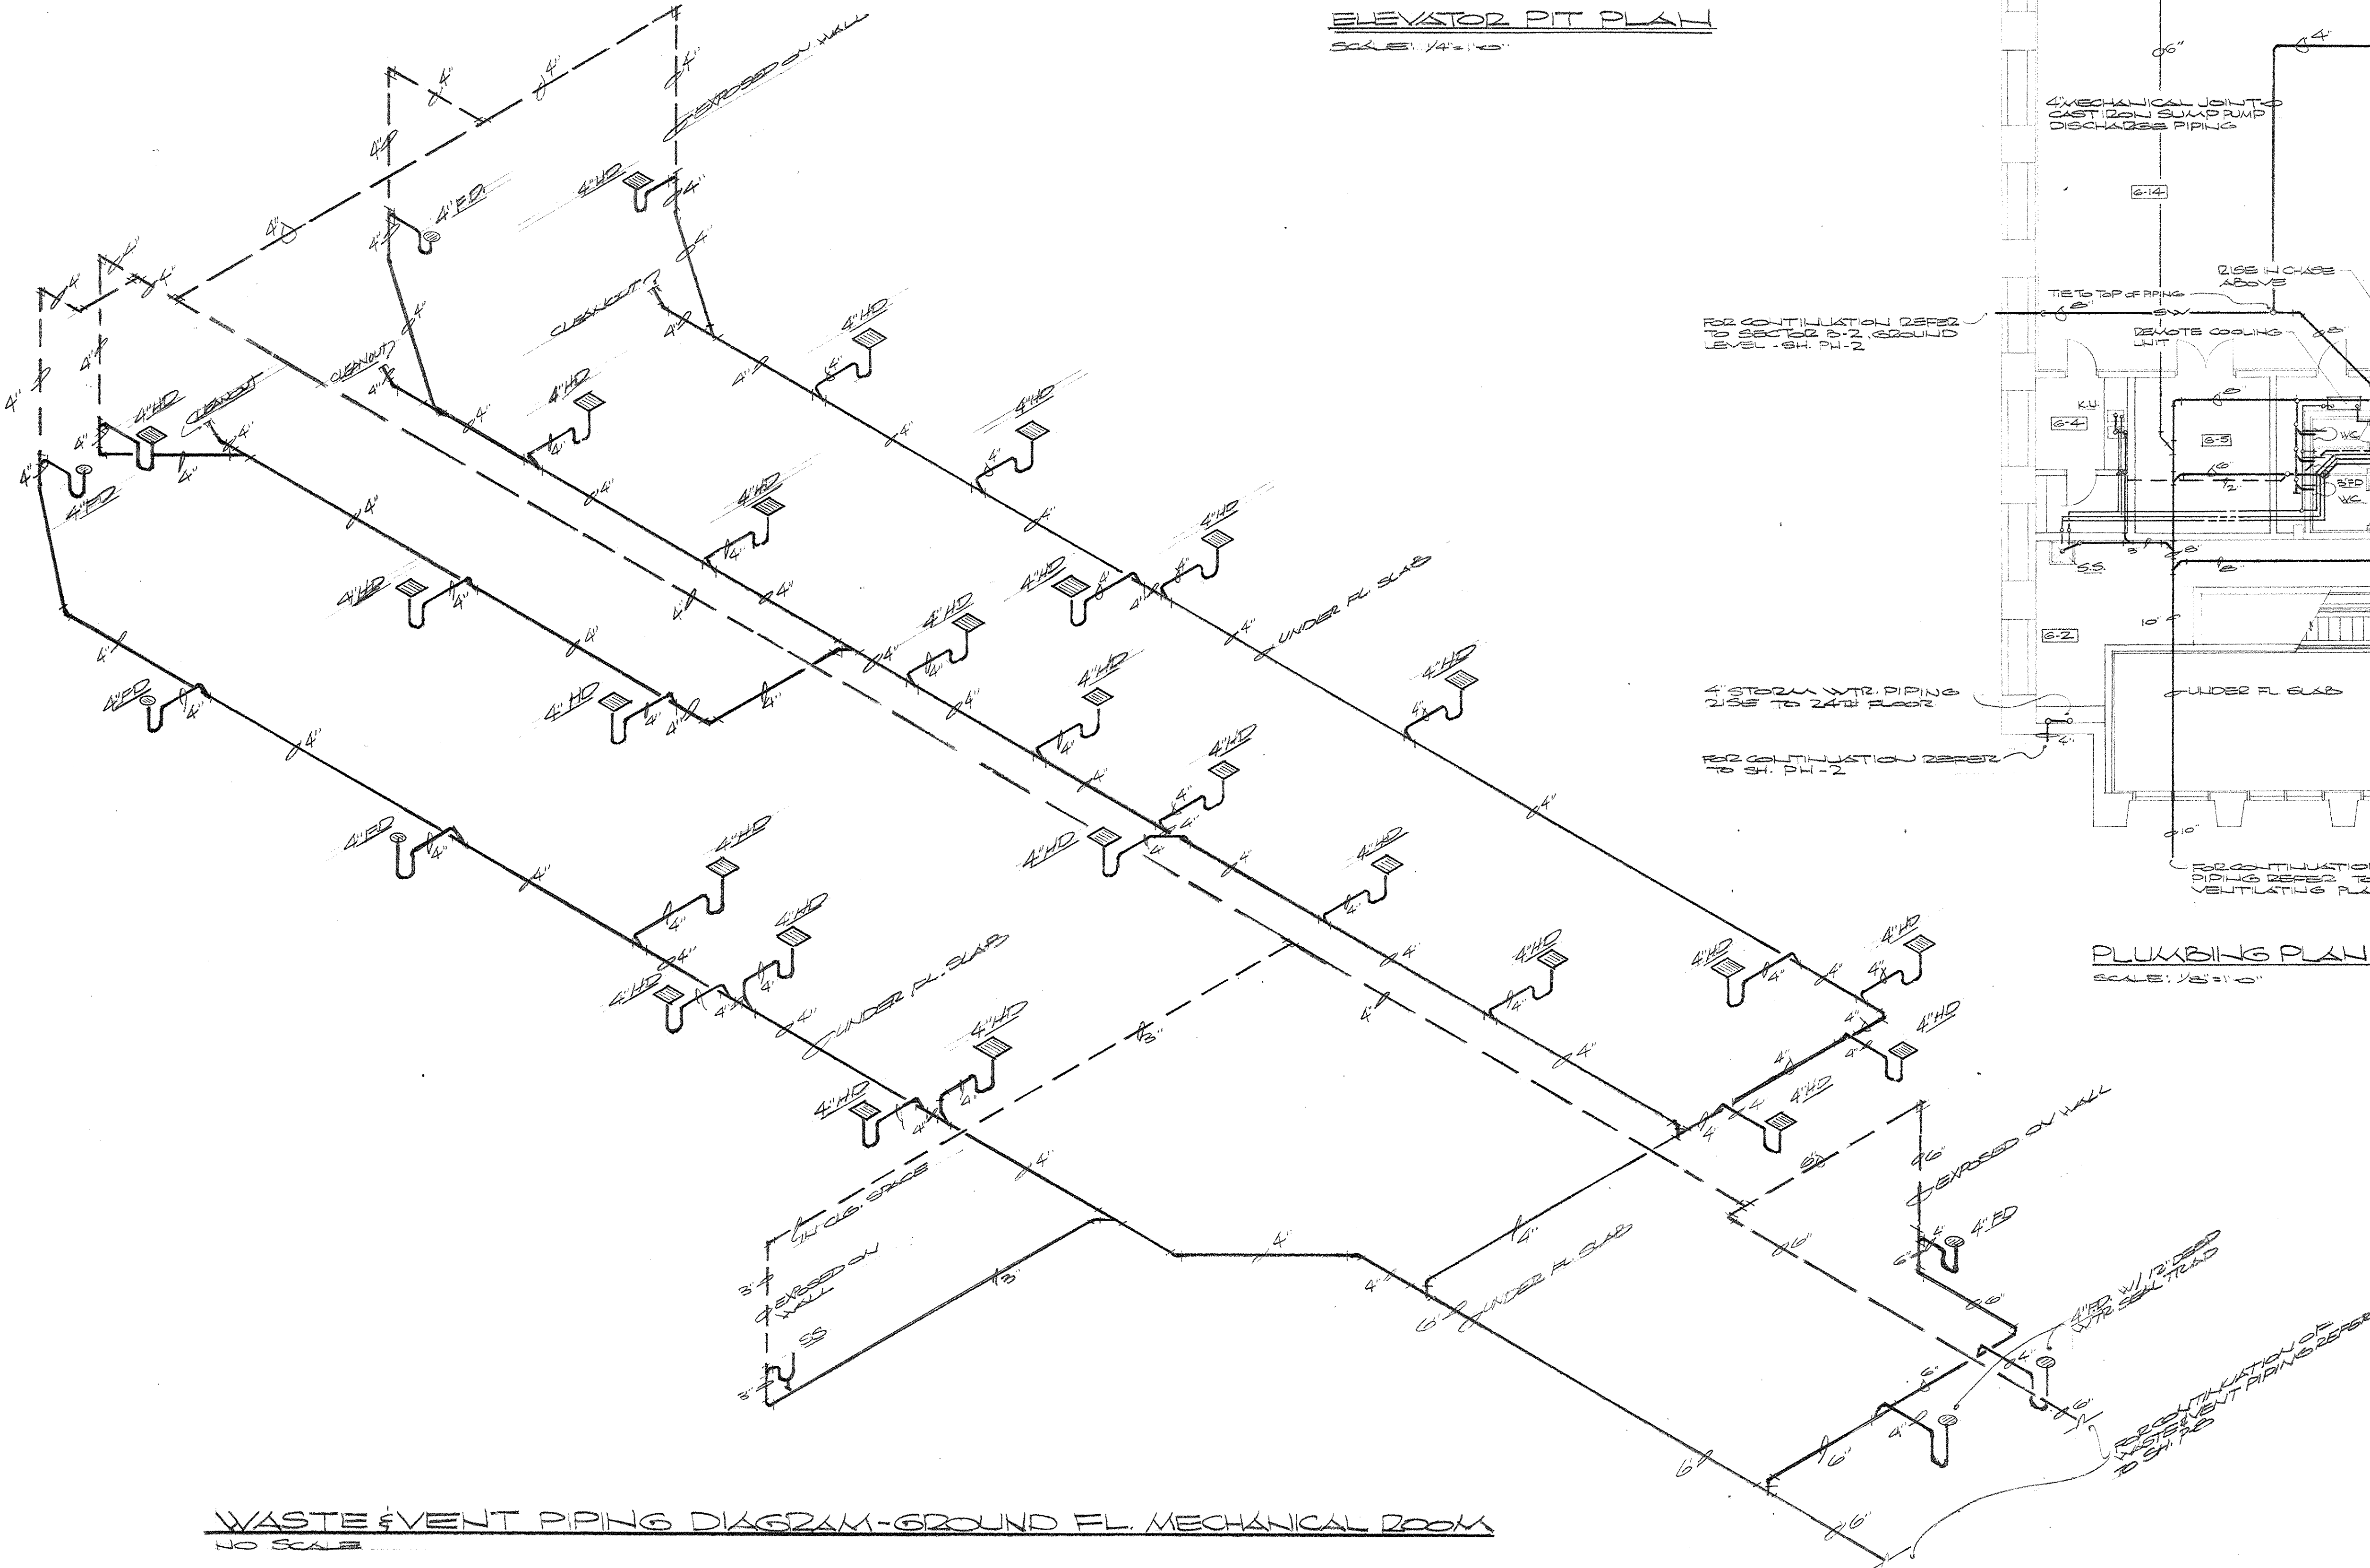


WASTE & VENT PIPING DIAGRAM-GROUND FL. MECHANICAL ROOM
NO SCALE

AS-BUILT DRAWINGS
DATE: JAN 73
HUGG, CARVER & BLANKEN, INC.

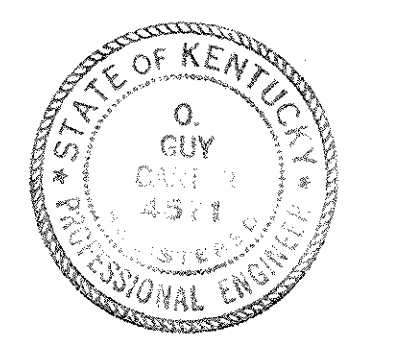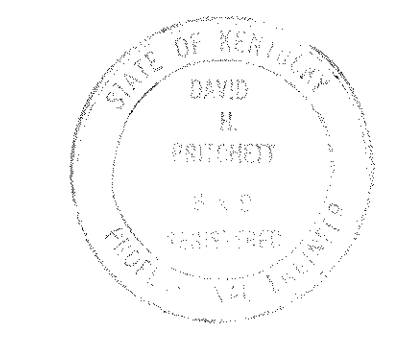


CAPITAL PLAZA OFFICE BUILDING FRANKFORT, KENTUCKY		
DRAWN BY SM/ET	PLUMBING PLAN-GROUND LEVEL-SECTION C-2	DATE 15 MAY 67
CHECKED BY SM/ET	ARCHITECT EDWARD DURELL STONE	SCALE AS SHOWN
SECTOR NO.	7 EAST 67TH STREET NEW YORK, N.Y.	COMM. NO. 62-286
	ASSOCIATE ARCHITECTS & ENGINEERS LEE POTTER SMITH & ASSOCIATES	DRAWING NO.
	314 WILKINSON FRANKFORT, KENTUCKY	
	COMMONWEALTH OF KENTUCKY DEPARTMENT OF FINANCE - ENGINEERING STAFF FRANKFORT, KENTUCKY	
APPROVED BY ARCHITECT	DATE	
APPROVED BY AGENCY HEAD	DATE	
APPROVED BY OWNER	DATE	MAY 24 1967



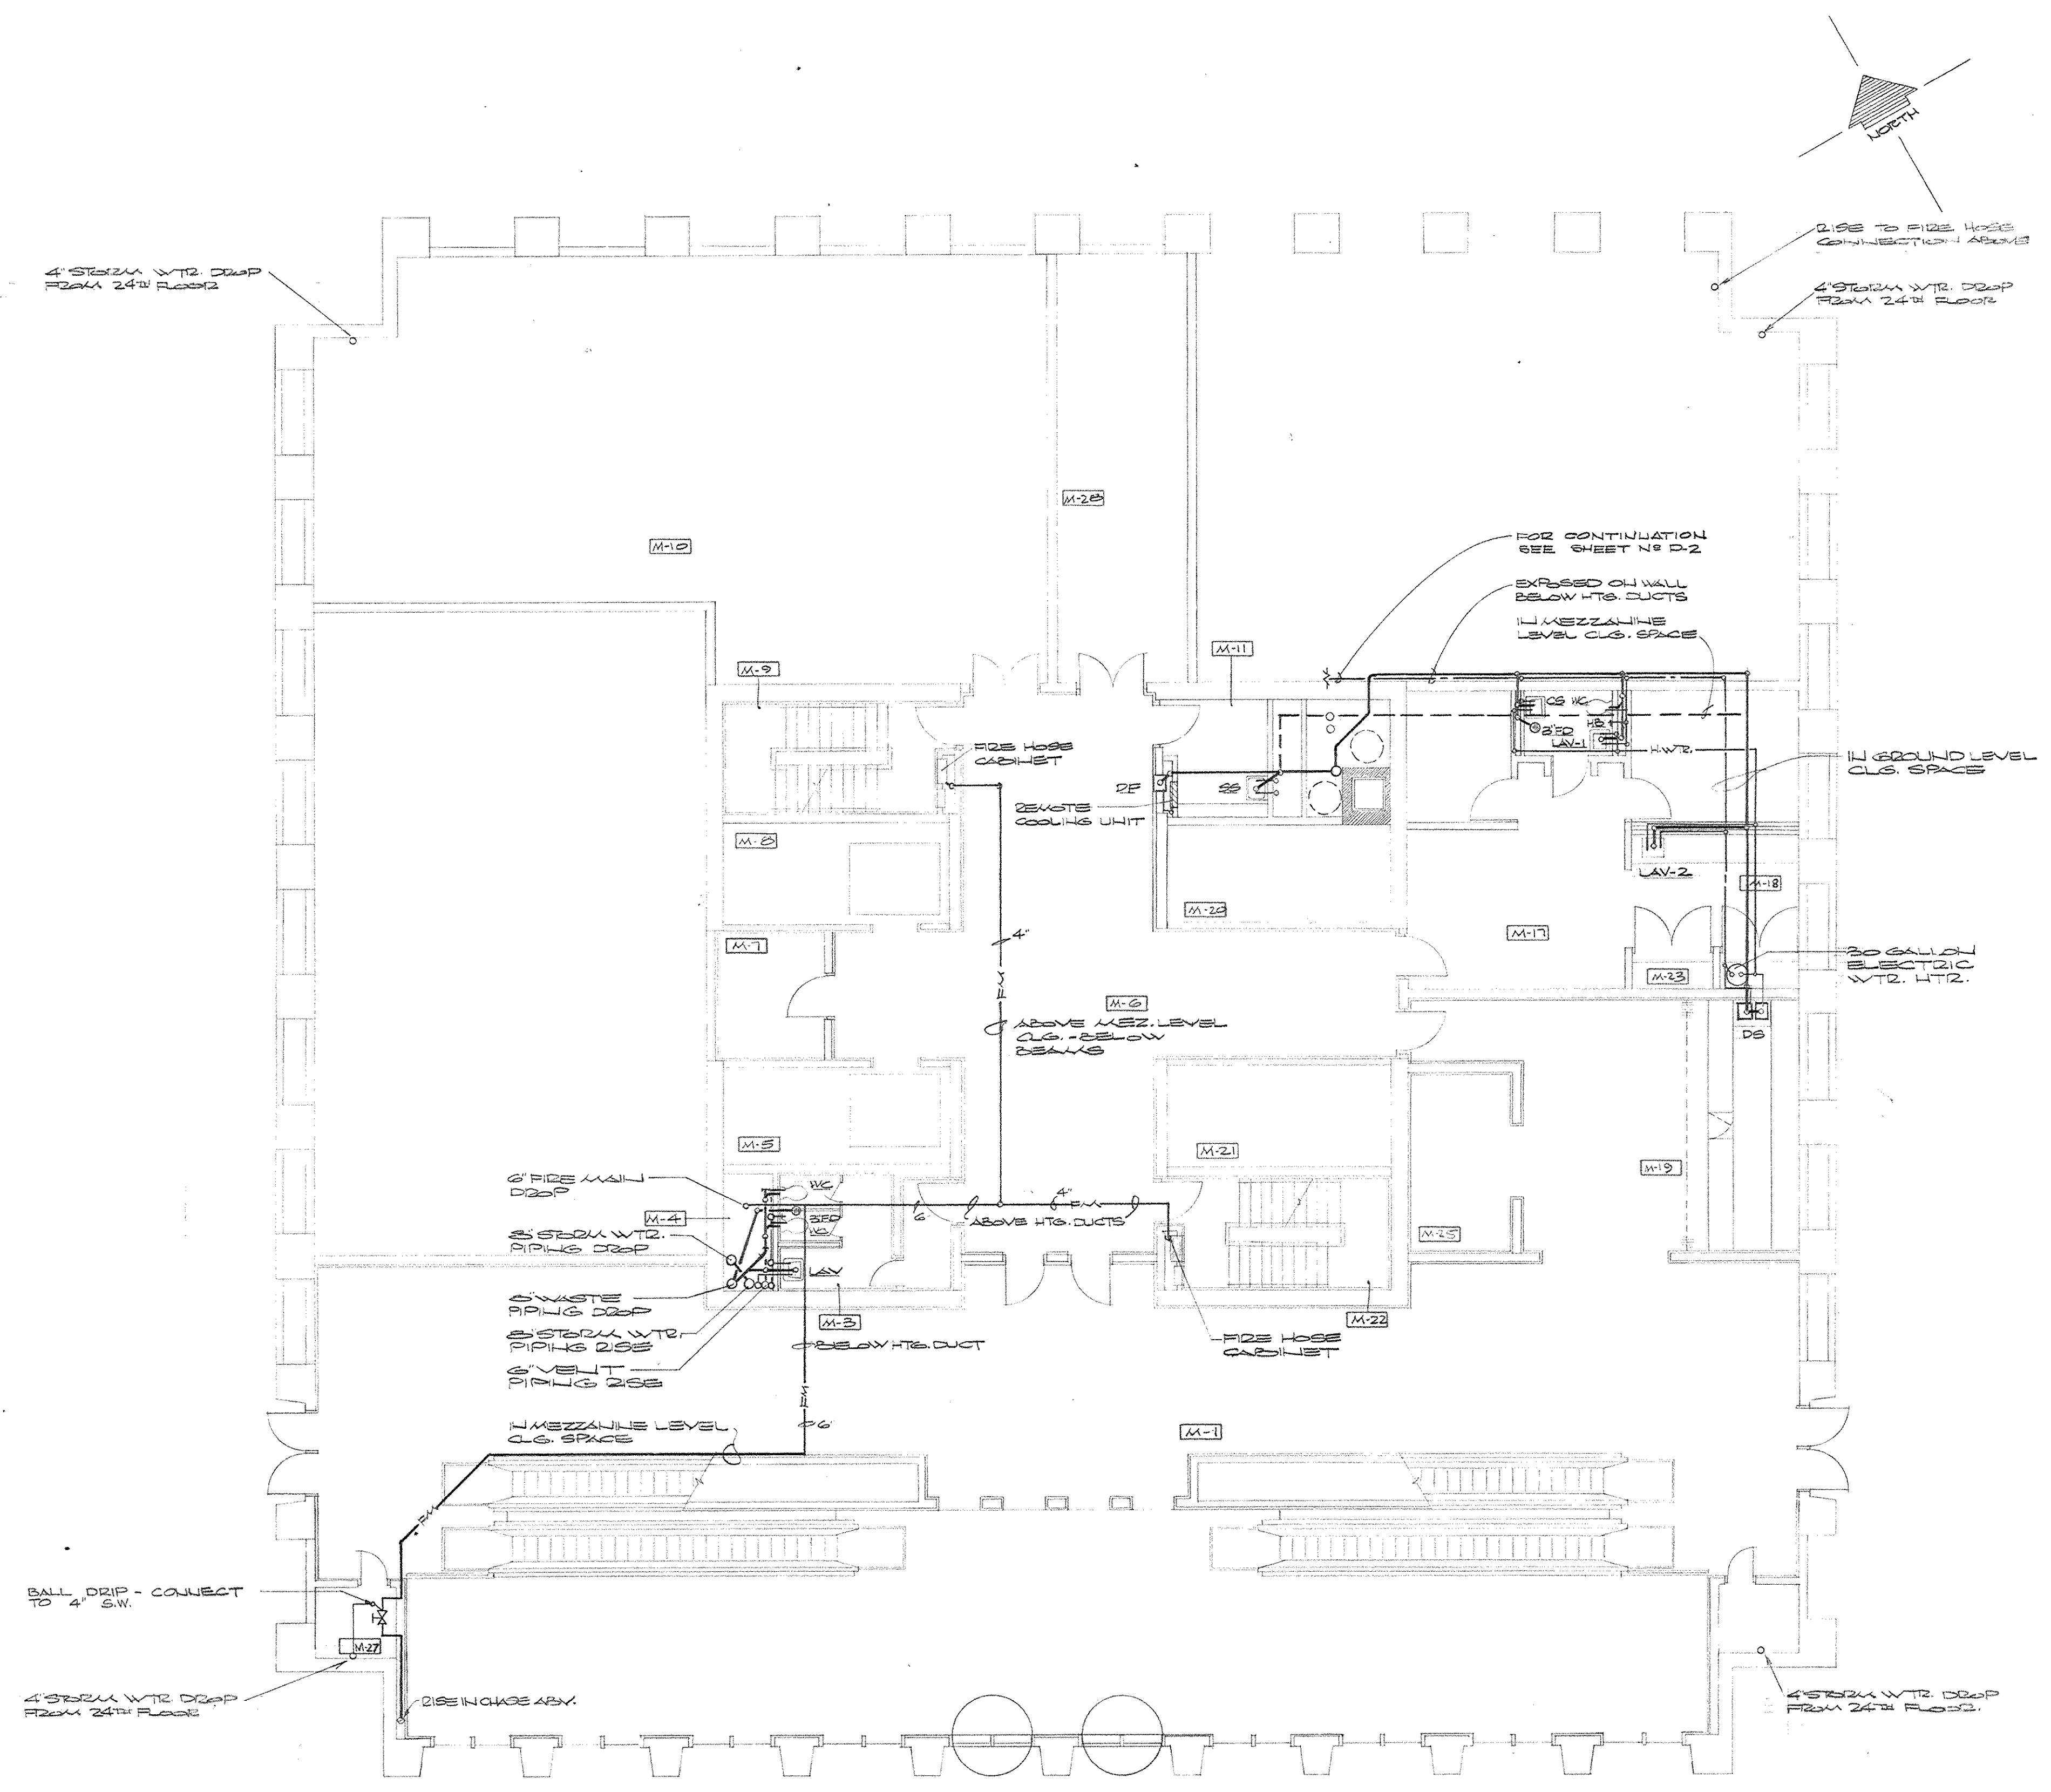


PLUMBING PLAN - MEZZANINE LEVEL - SECTOR C-2
 SCALE: 1/8" = 1'-0"

AS-BUILT DRAWINGS
 DATE: JAN 73
 HUGG, CARTER & BLACKMAN, INC.


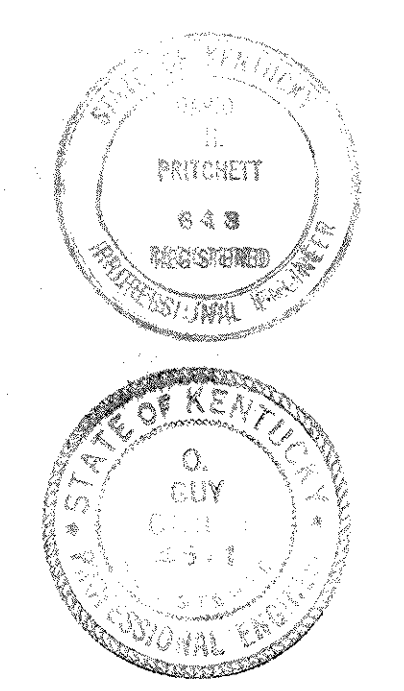


CAPITAL PLAZA OFFICE BUILDING		
FRANKFORT, KENTUCKY		
DRAWN BY SMIT	PLUMBING PLAN MEZZANINE LEVEL	DATE 10/27/71
TRACED BY SMIT	ARCHITECT EDWARD DURELL STONE	SCALE 1/8" = 1'-0"
CHECKED BY SMIT	7 EAST 87TH STREET NEW YORK, N. Y.	COMM. NO. 2226
SECTOR NO.	ASSOCIATE ARCHITECTS & ENGINEERS LEE POTTER SMITH & ASSOCIATES 314 WILKINSON FRANKFORT, KENTUCKY	DRAWING NO. P 3 OF 14
APPROVED BY	ARCHITECT	DATE
APPROVED BY	AGENCY HEAD <i>Mr. Conwell</i>	DATE MAY 24 1973
APPROVED BY	OWNER	DATE

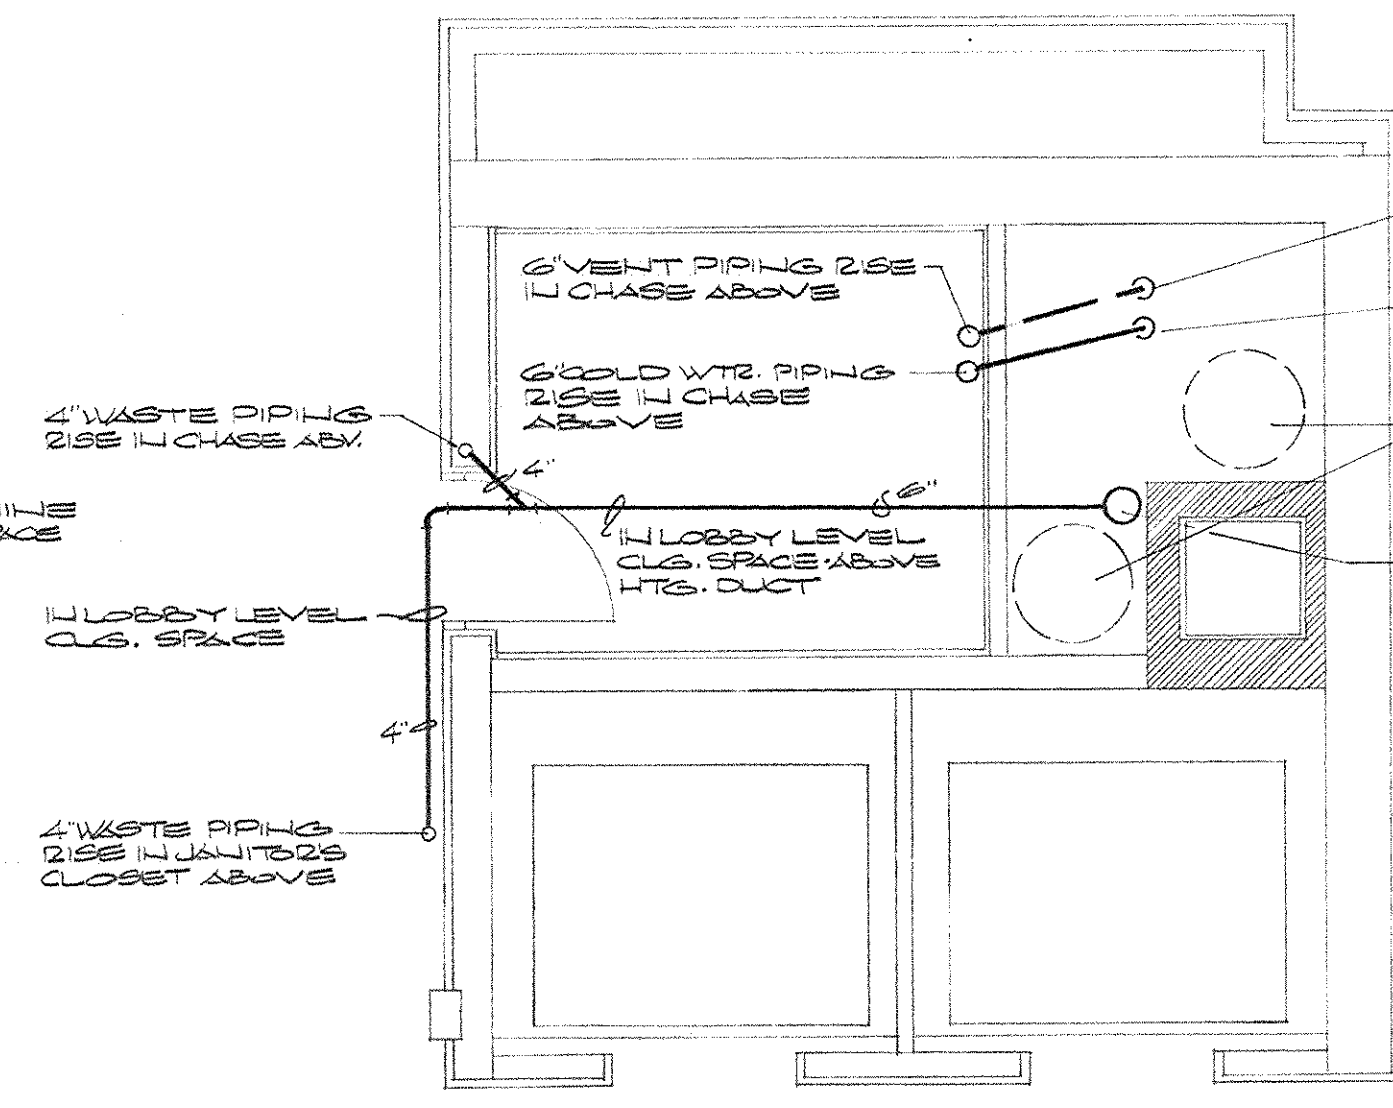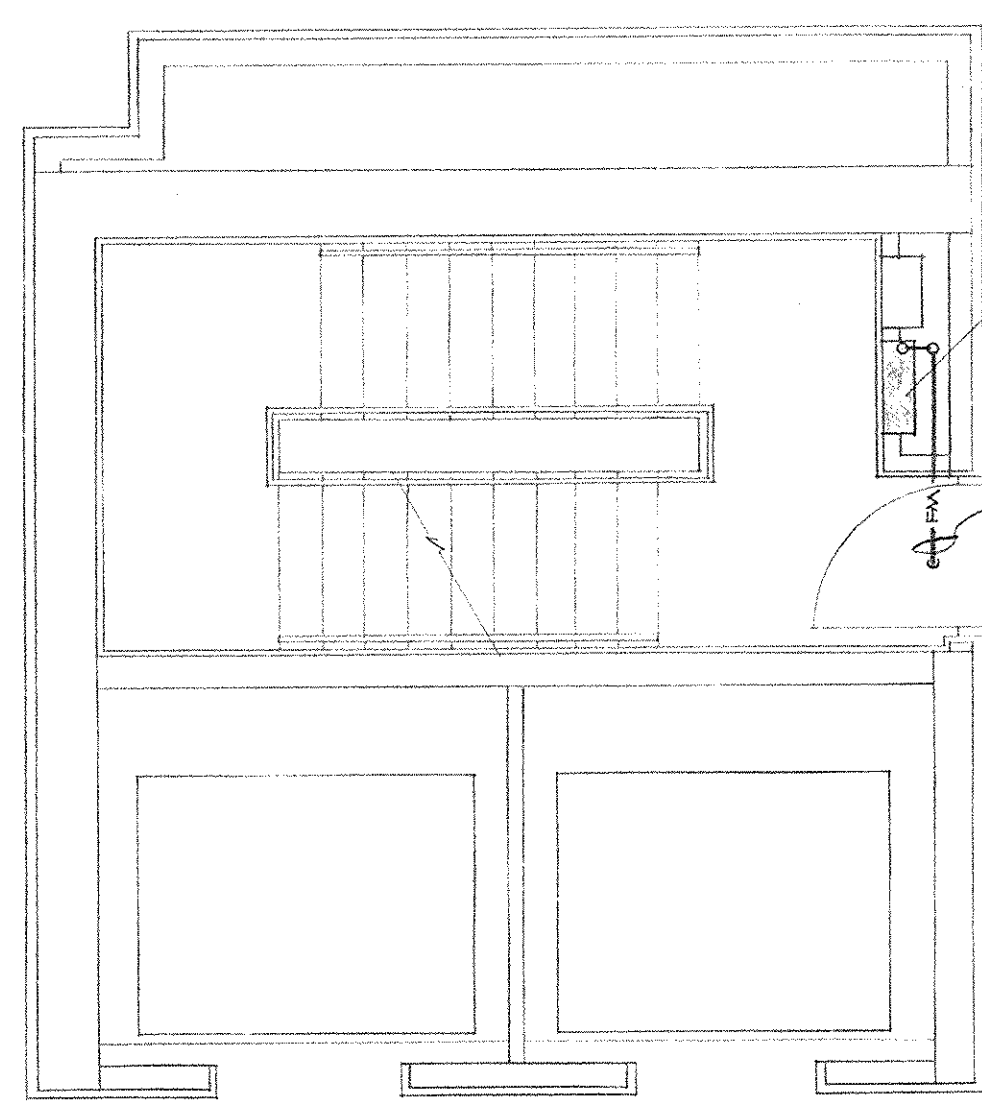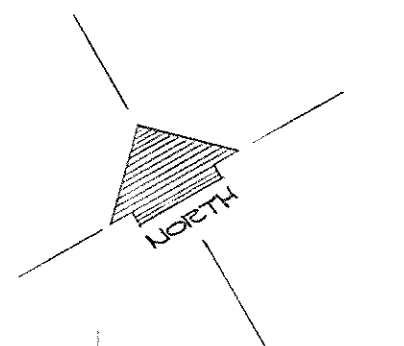

6" VENT PIPING 2" DIA. 1" CHASE ABOVE
 6" COLD WTR. PIPING 2" DIA. 1" CHASE ABOVE
 HTS. DUCTS
 2" WASTE PIPING 2" DIA. 4" DROP 1" CHASE


2" WASTE PIPING 2" DIA. 1" CHASE ABV.
 1" MEZZANINE LEVEL CUS. SPACE
 1" LOBBY LEVEL CUS. SPACE
 4" WASTE PIPING 2" DIA. 1" CHASE CLOSET ABOVE

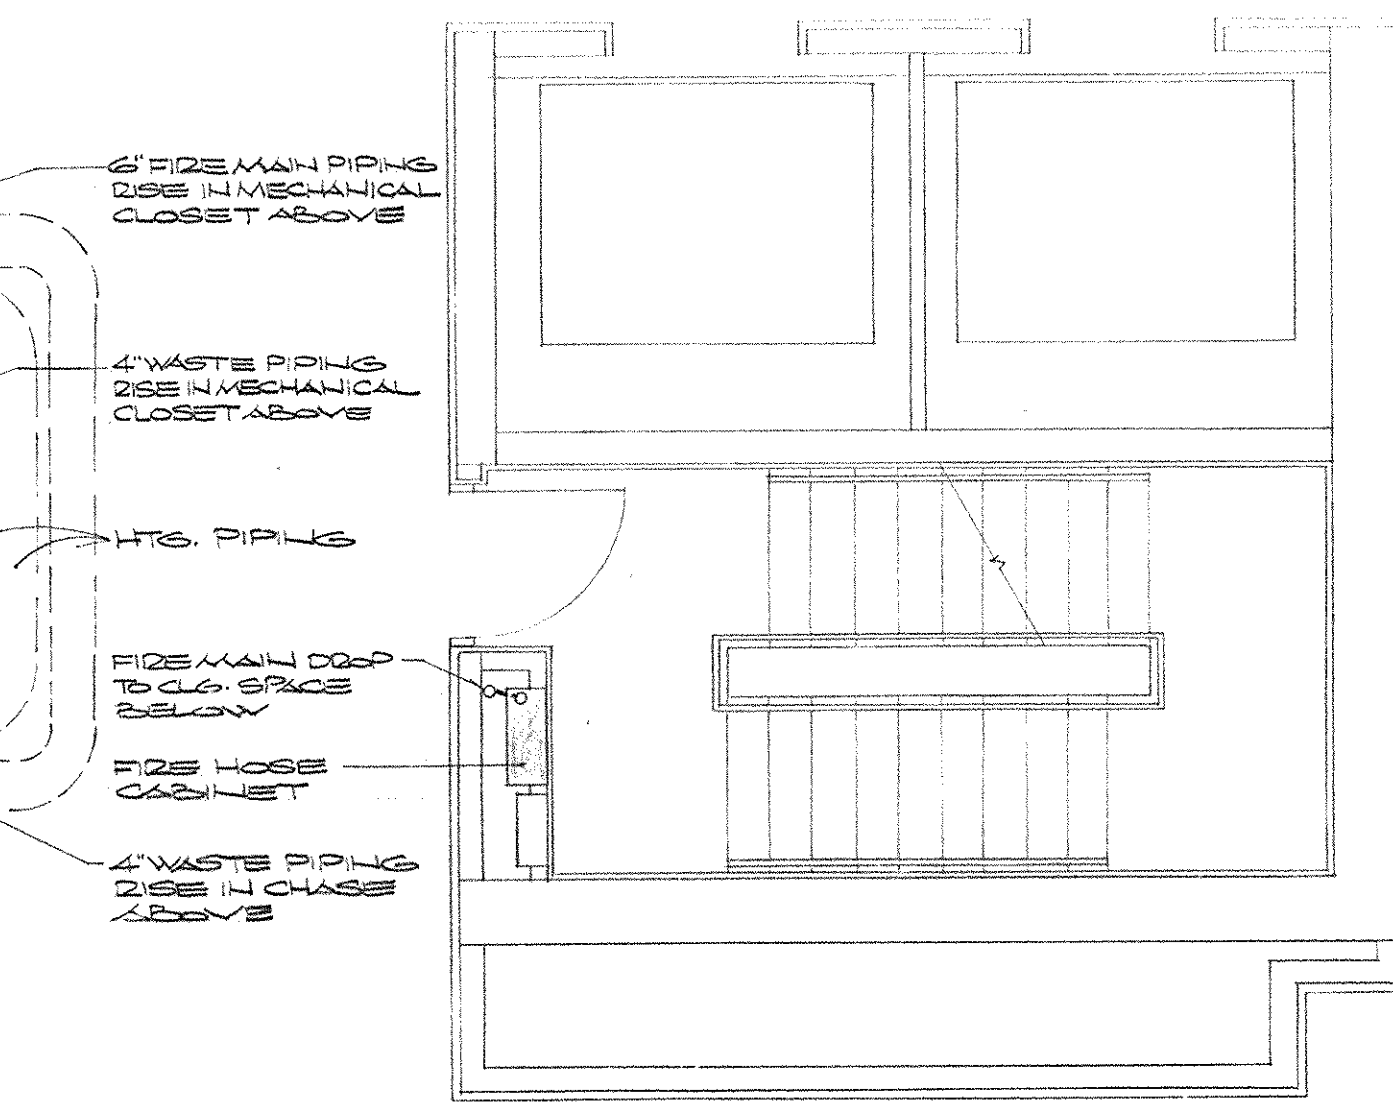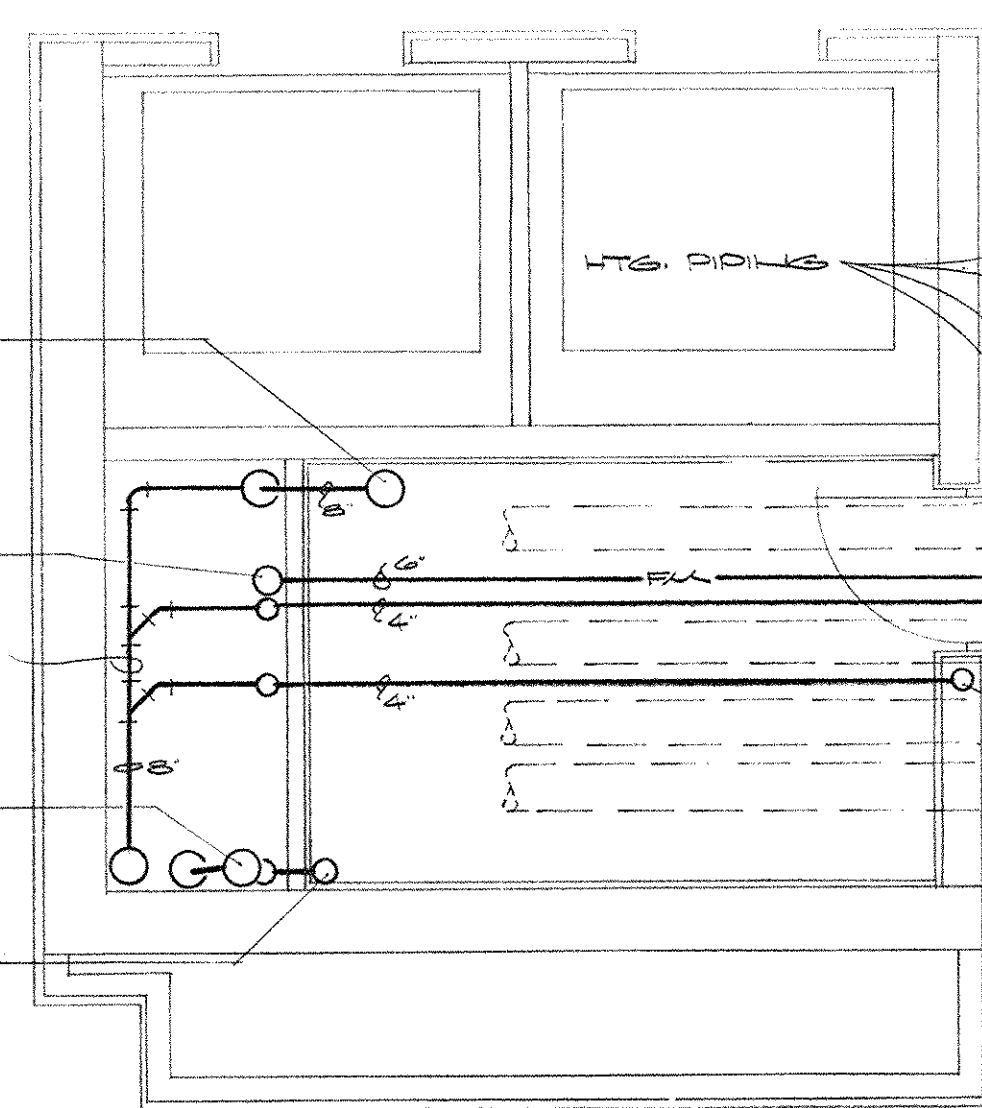

2" WASTE PIPING 2" DIA. 1" CHASE ABOVE
 6" FIRE MAIN DROP 1" CHASE
 BELOW HTS. PIPING
 6" COLD WTR. PIPING 2" DIA. 1" CHASE ABV.
 6" VENT PIPING 2" DIA. 1" CHASE ABOVE

6" FIRE MAIN PIPING 2" DIA. 1" MECHANICAL CLOSET ABOVE
 4" WASTE PIPING 2" DIA. 1" MECHANICAL CLOSET ABOVE
 HTS. PIPING
 6" FIRE MAIN DROP TO CUS. SPACE BELOW
 2" WASTE PIPING 2" DIA. 1" CHASE ABOVE
 4" WASTE PIPING 2" DIA. 1" CHASE ABOVE

ENLARGED CORE PLAN-LOBBY LEVEL
 SCALE: 1/4" = 1'-0"

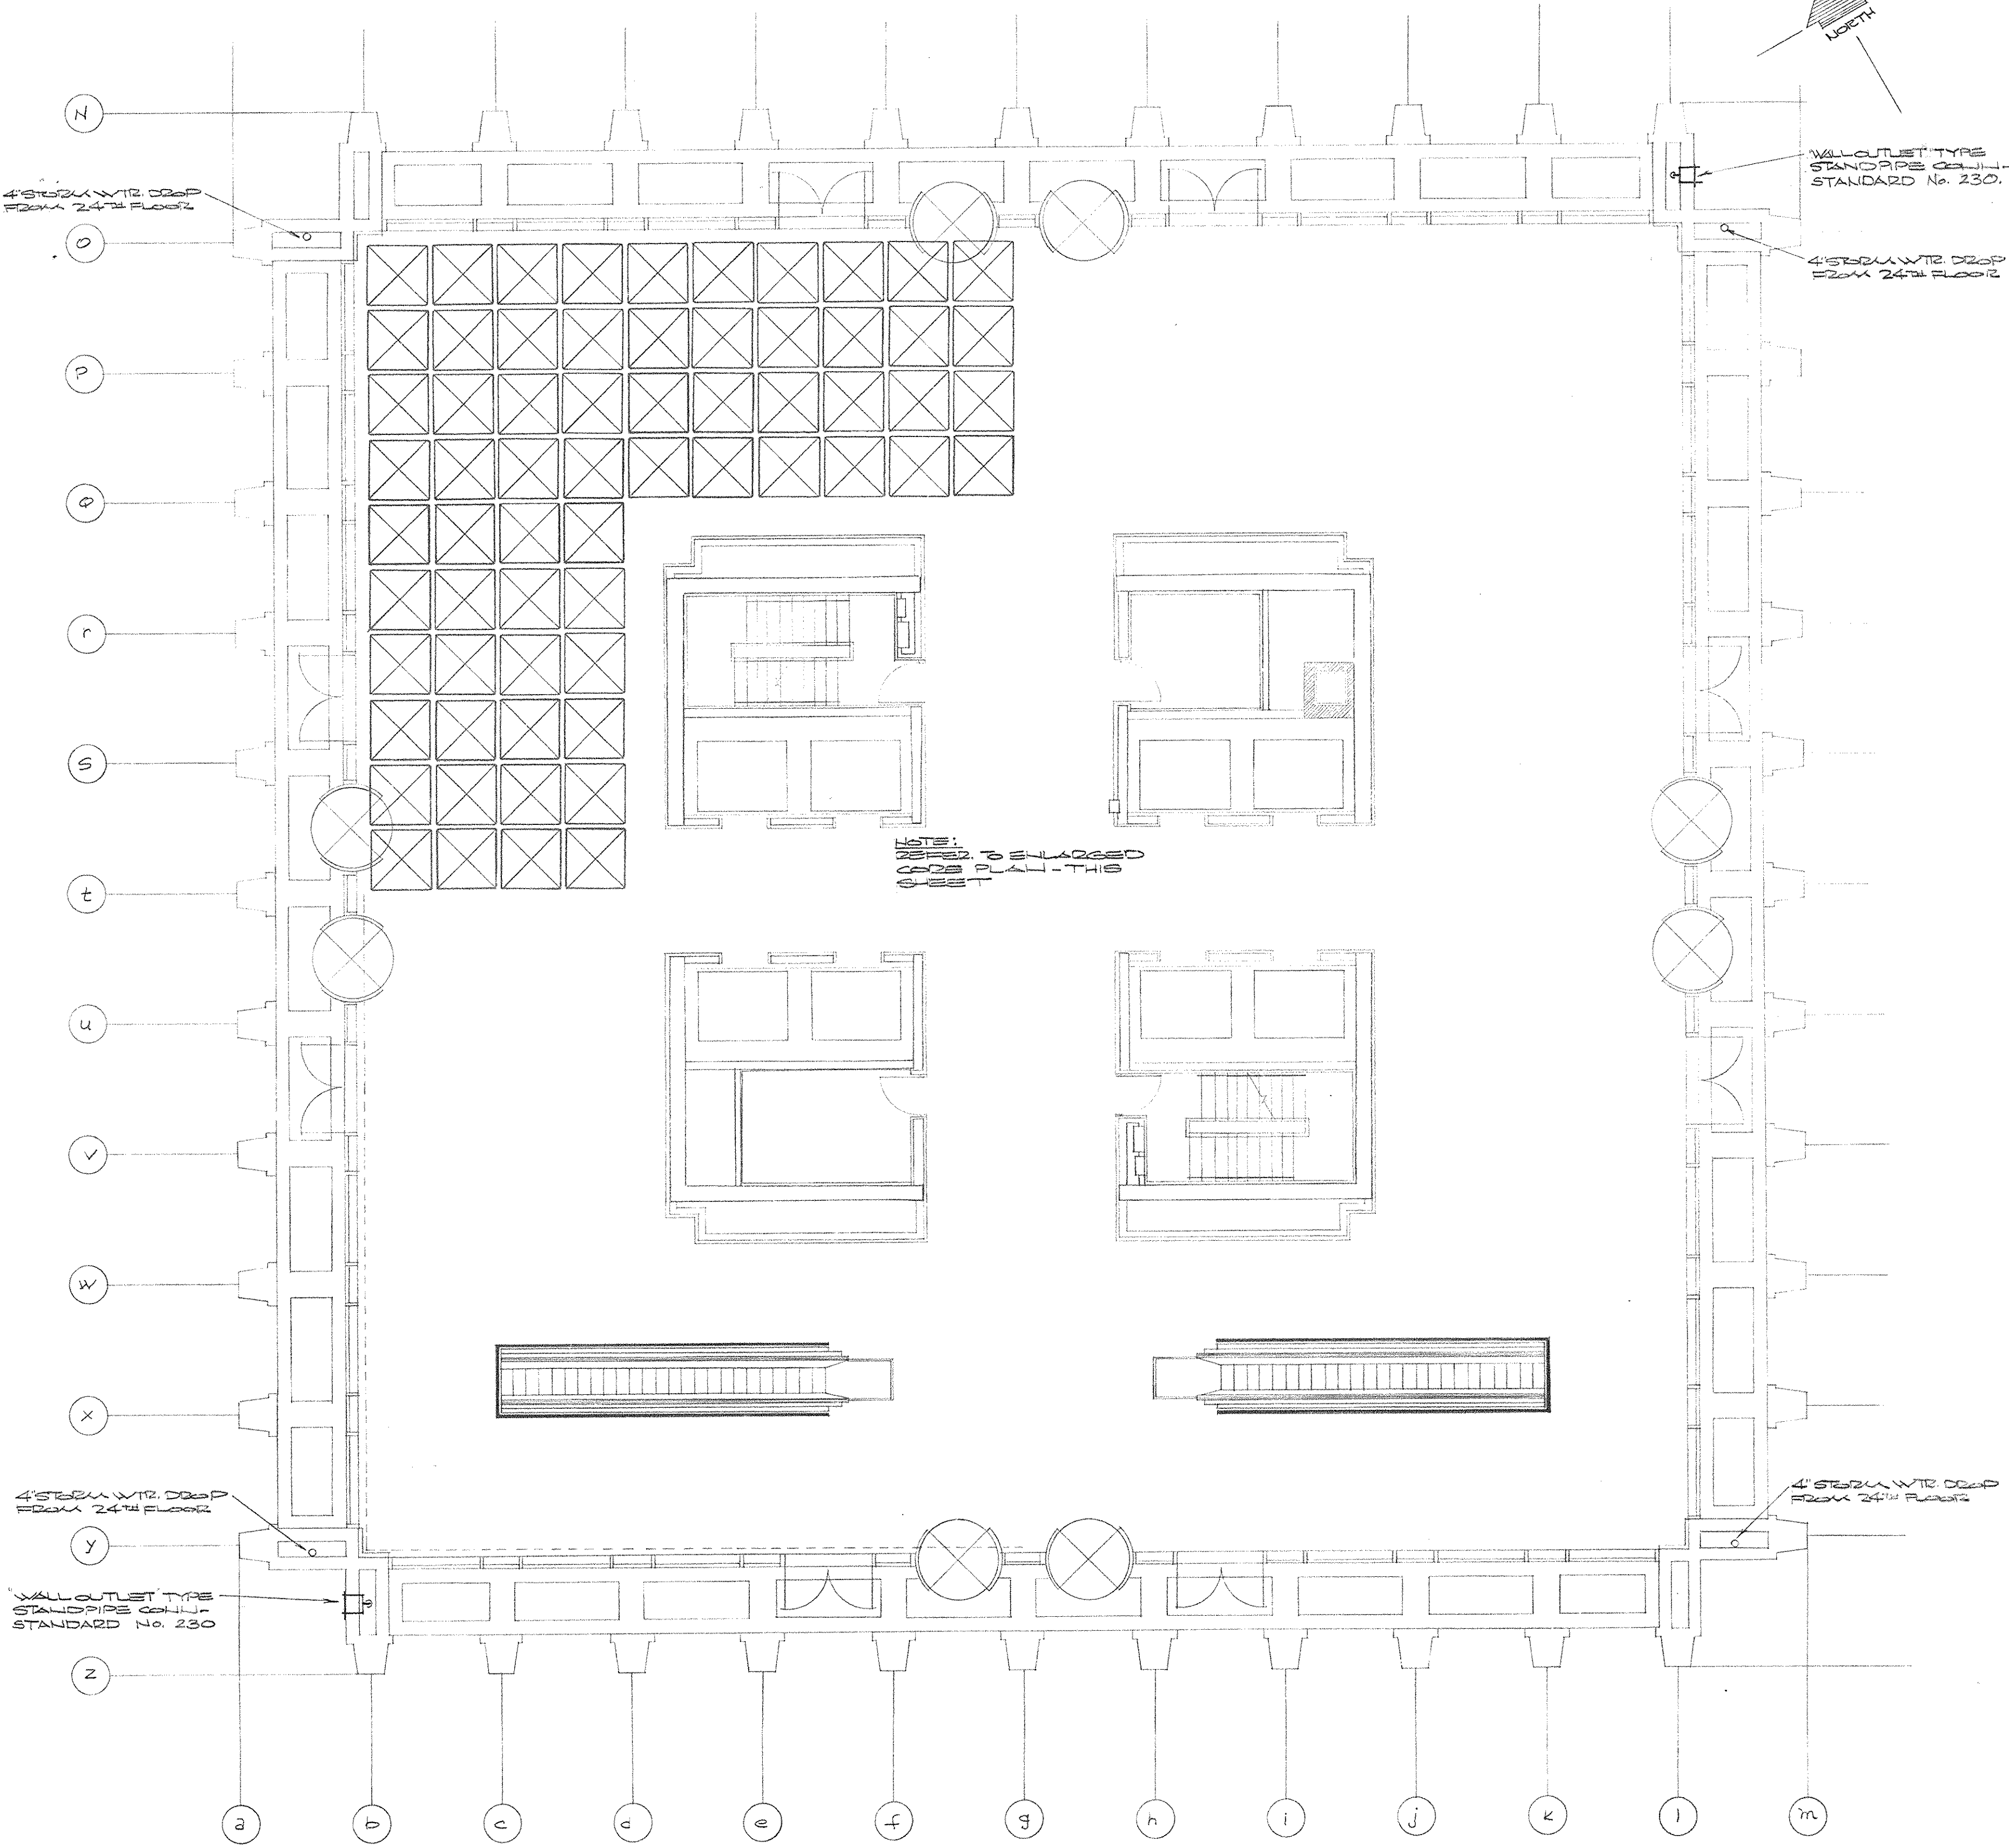

N
O
P
Q
R
S
T
U
V
W
X
Y
Z


a b c d e f g h i j k l m n

4" FIRE MAIN WTR. DROP FROM 24" DIA. FLOOR
 WALL OUTLET TYPE STANDARD No. 230

WALL OUTLET TYPE STANDARD No. 230
 4" FIRE MAIN WTR. DROP FROM 24" DIA. FLOOR



NOTE: CORE TO BE ENCLOSED FOR FALL-TIGHT

PLUMBING PLAN-LOBBY LEVEL
 SCALE: 1/8" = 1'-0"

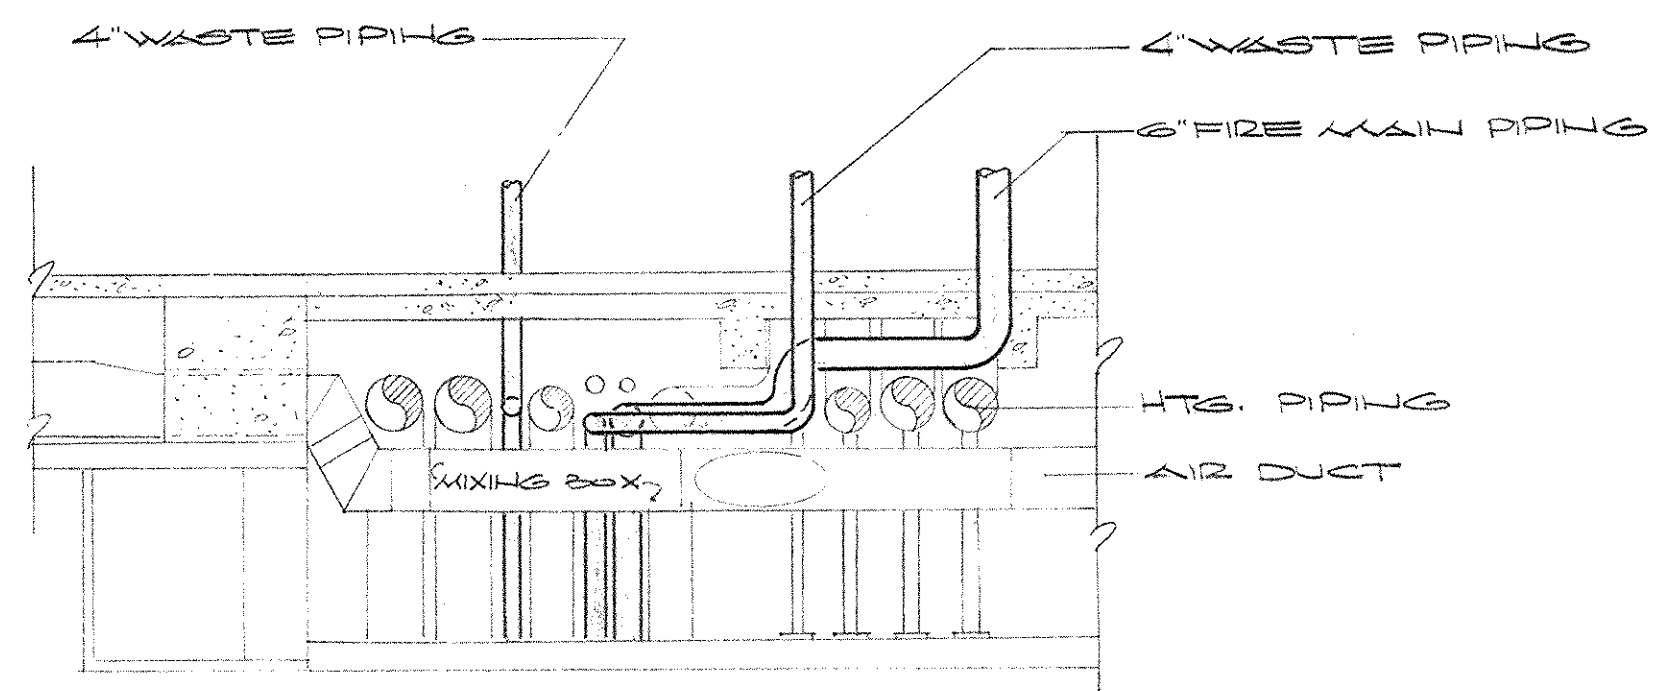


SECTION
 SCALE: 1/4" = 1'-0"

AS-BUILT DRAWINGS
 DATE: JAN 73
 HUGG, CARTER & BLAIRMAN, INC.

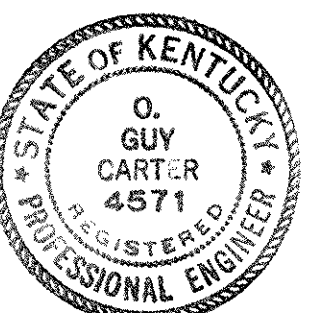
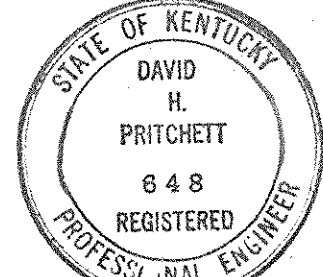


CAPITAL PLAZA OFFICE BUILDING FRANKFORT, KENTUCKY		
DRAWN BY SW/ET	PLUMBING PLAN- LOBBY LEVEL	DATE 1/5/73
TRACED BY SW/ET	ARCHITECT EDWARD DURELL STONE	SCALE AS NOTED
CHECKED BY SW/ET	7 EAST 67TH STREET NEW YORK N. Y.	COMM. NO. SP-105
SECTOR NO.	ASSOCIATE ARCHITECTS & ENGINEERS LEE POTTER SMITH & ASSOCIATES 314 WILKINSON FRANKFORT, KENTUCKY	DRAWING NO. P 4 OF 14
COMMONWEALTH OF KENTUCKY DEPARTMENT OF FINANCE - ENGINEERING STAFF FRANKFORT, KENTUCKY		
APPROVED BY	ARCHITECT	DATE
APPROVED BY	AGENCY HEAD	DATE
APPROVED BY	<i>O. Guy Cartier</i> OWNER	DATE 1/5/73

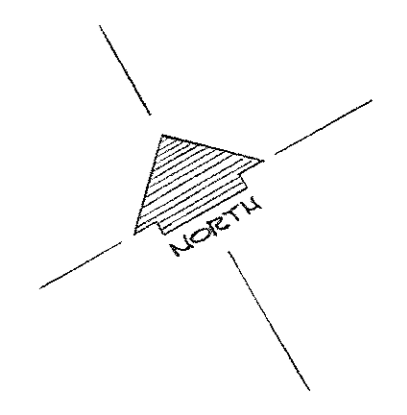

NOTE:
 4" STORM WTR. PIPING DROP TO BELOW
 GROUND FL. SHALL BE 4" STORM WTR. PIPING
 DROP TO 12" LEVEL (ROUGH-IN) TWO 2" PL.
 DRAINS W/ DEEP SEAL TRAPS AT THE LOCATIONS
 SHOWN ON THE ARCH. DRAWINGS (EXTEND UP
 AS STORM WTR. MAIN UP TO 24" FL. OR
 SPACE (ROUGH-IN) TWO 2" FL. DRAINS (AS
 SHOWN ON SHEET H-7)

NOTE:
 4" STORM WTR. PIPING DROP TO BELOW
 GROUND FL. SHALL BE 4" STORM WTR. PIPING
 DROP TO 12" LEVEL (ROUGH-IN) TWO 2" PL.
 DRAINS W/ DEEP SEAL TRAPS AT THE LOCATIONS
 SHOWN ON THE ARCH. DRAWINGS (EXTEND UP
 AS STORM WTR. MAIN UP TO 24" FL. OR
 SPACE (ROUGH-IN) TWO 2" FL. DRAINS (AS SHOWN
 ON SHEET H-7)

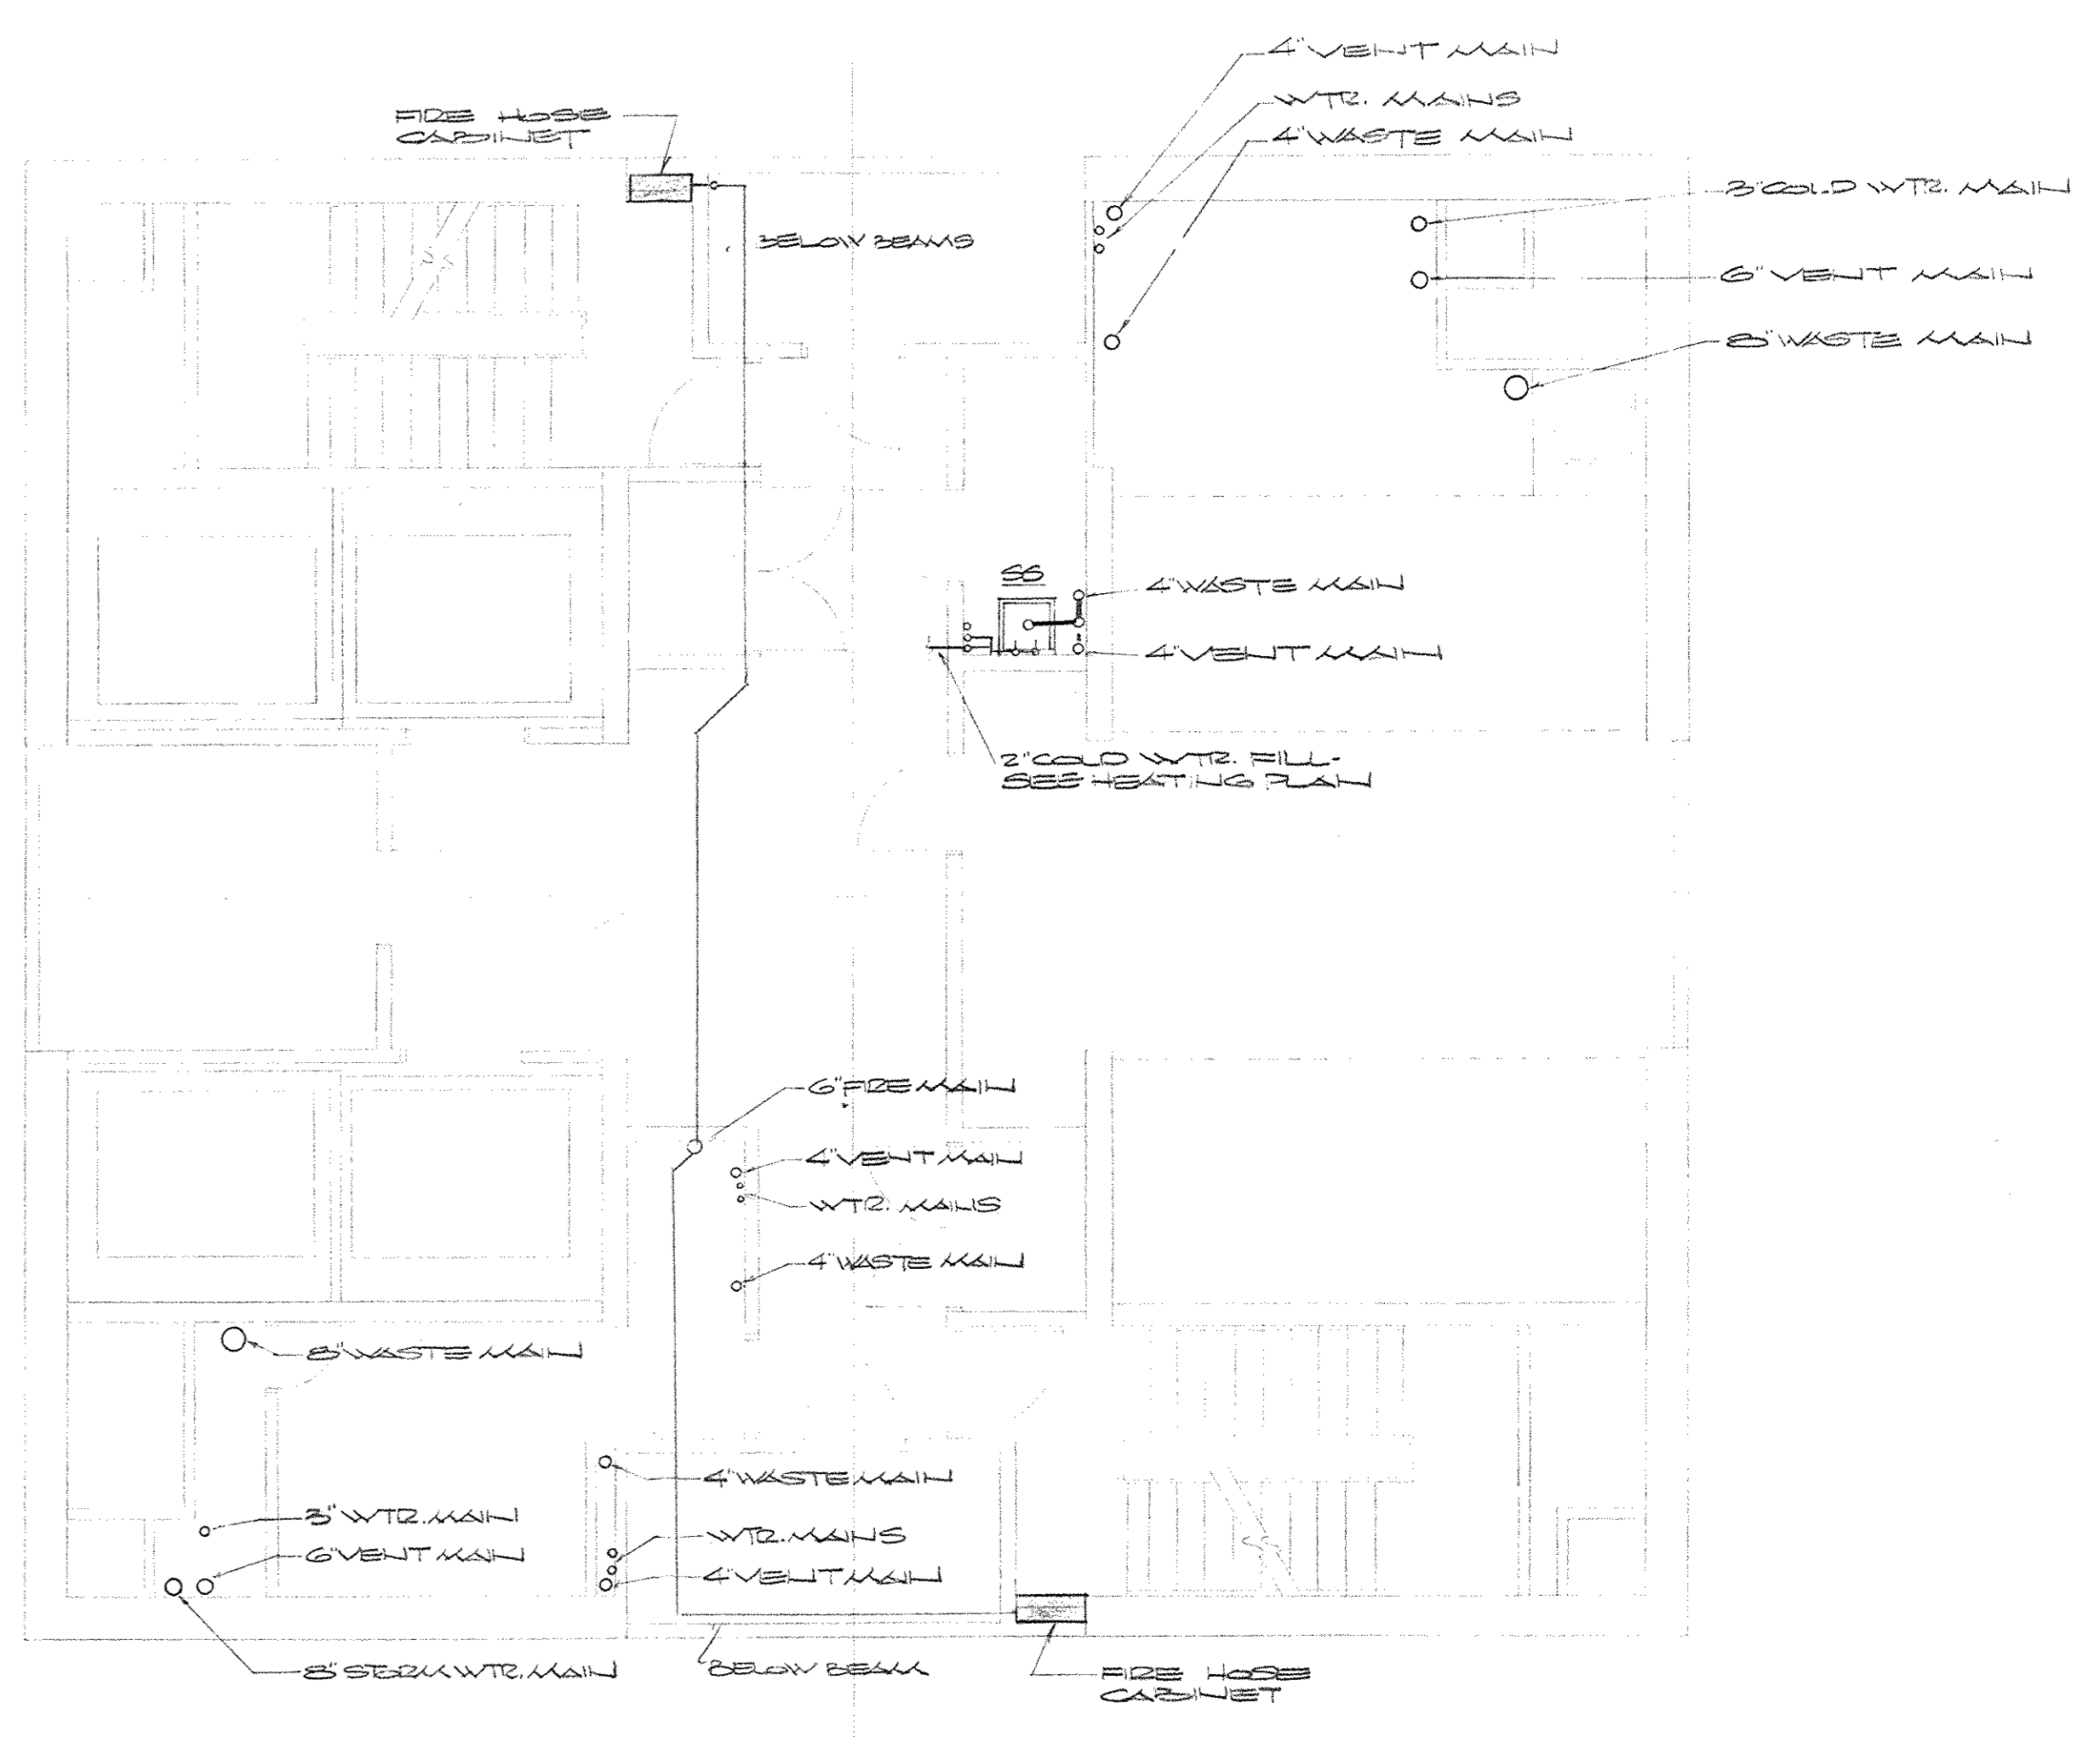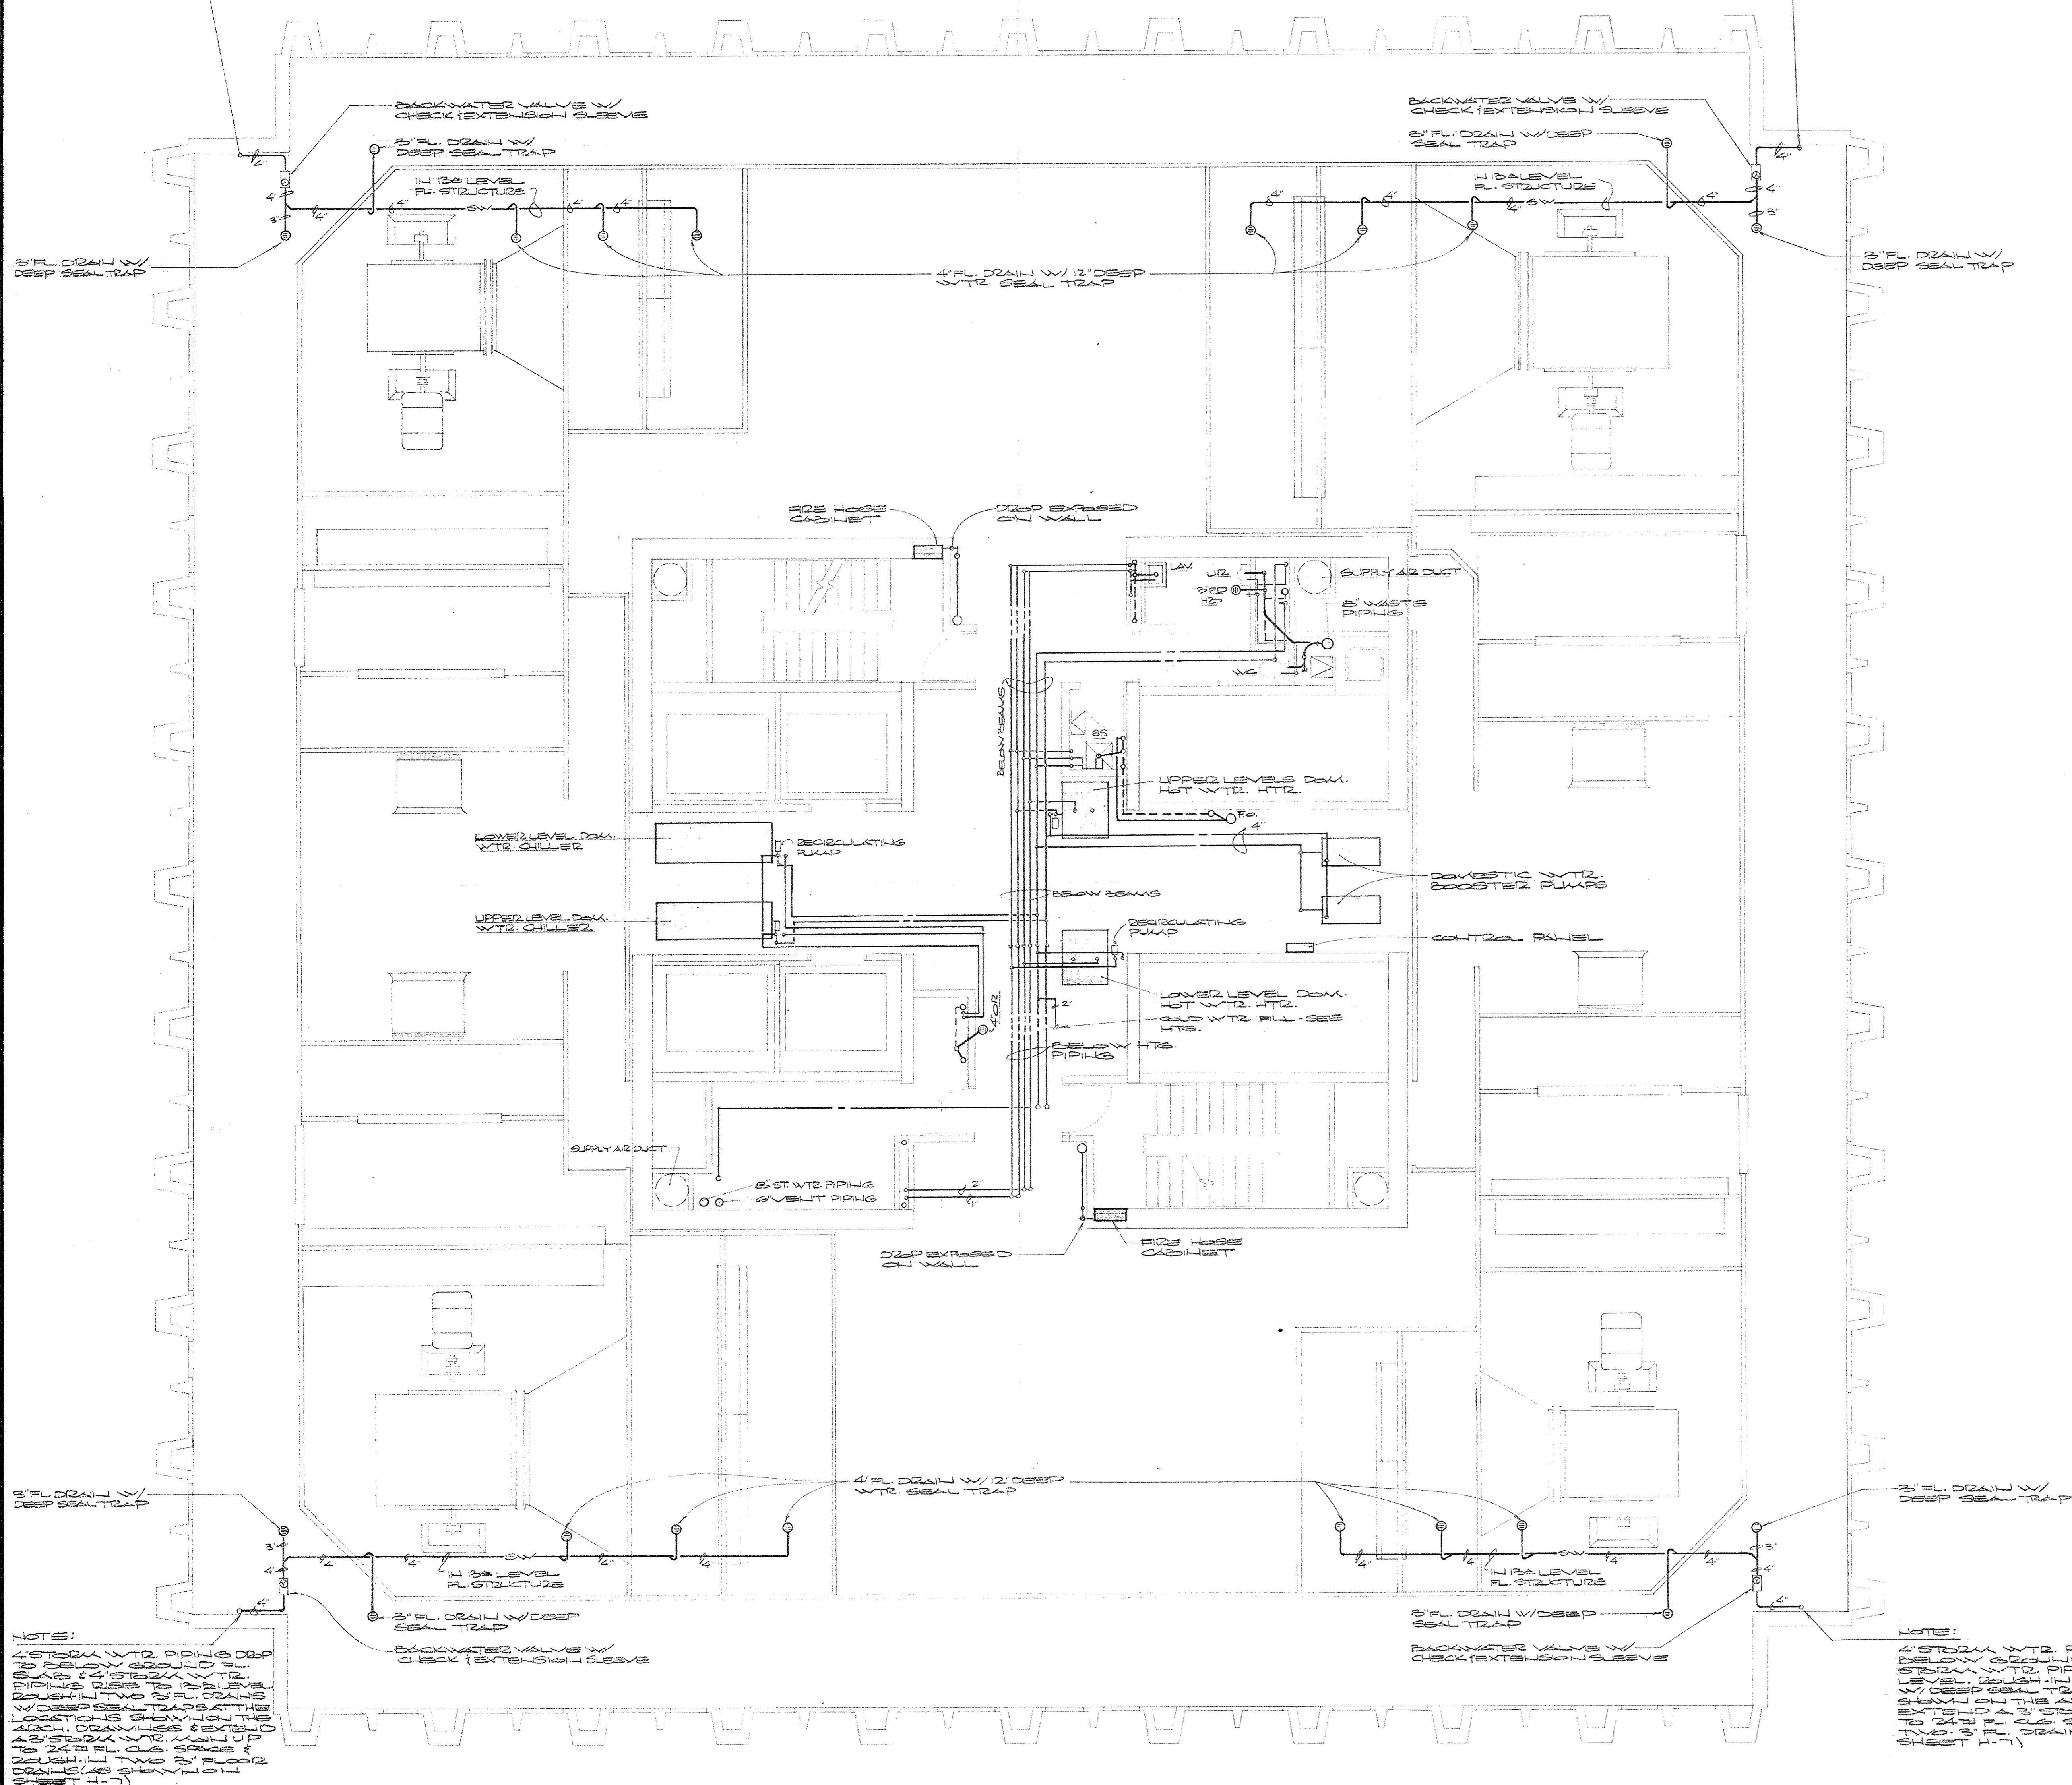


ENLARGED CODE PLAN - 13th LEVEL
 SCALE: 3/8" = 1'-0"

NOTE:
 4" STORM WTR. PIPING DROP TO BELOW
 GROUND FL. SHALL BE 4" STORM WTR. PIPING
 DROP TO 12" LEVEL (ROUGH-IN) TWO 2" PL.
 DRAINS W/ DEEP SEAL TRAPS AT THE LOCATIONS
 SHOWN ON THE ARCH. DRAWINGS (EXTEND UP
 AS STORM WTR. MAIN UP TO 24" FL. OR
 SPACE (ROUGH-IN) TWO 2" FL. DRAINS (AS
 SHOWN ON SHEET H-7)



NOTE:
 4" STORM WTR. PIPING DROP TO BELOW
 GROUND FL. SHALL BE 4" STORM WTR. PIPING
 DROP TO 12" LEVEL (ROUGH-IN) TWO 2" PL.
 DRAINS W/ DEEP SEAL TRAPS AT THE LOCATIONS
 SHOWN ON THE ARCH. DRAWINGS (EXTEND UP
 AS STORM WTR. MAIN UP TO 24" FL. OR
 SPACE (ROUGH-IN) TWO 2" FL. DRAINS (AS SHOWN ON
 SHEET H-7)

PLUMBING PLAN - 13th LEVEL
 SCALE: 3/8" = 1'-0"


AS-BUILT DRAWINGS
 DATE: JAN 73
 HUGG, CARTER & BLAKEMAN, INC.

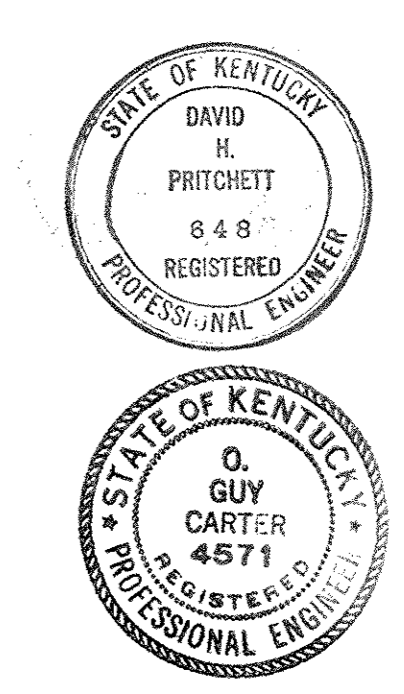

CAPITAL PLAZA OFFICE BUILDING FRANKFORT, KENTUCKY		
DRAWN BY SWIFT	PLUMBING PLANS 12A & 12B LEVELS	DATE 12/27/72
TRACED BY SWIFT	ARCHITECT EDWARD DURELL STONE	SCALE 3/8" = 1'-0"
CHECKED BY SWIFT	7 EAST 27TH STREET NEW YORK, N.Y.	COMM. NO. 12345
SECTOR NO.	ASSOCIATE ARCHITECTS & ENGINEERS LEE POTTER SMITH & ASSOCIATES FRANKFORT, KENTUCKY	DRAWING NO. P 5
APPROVED BY	ARCHITECT	DATE
APPROVED BY	AGENCY HEAD	DATE MAY 24 1973
APPROVED BY	OWNER	DATE

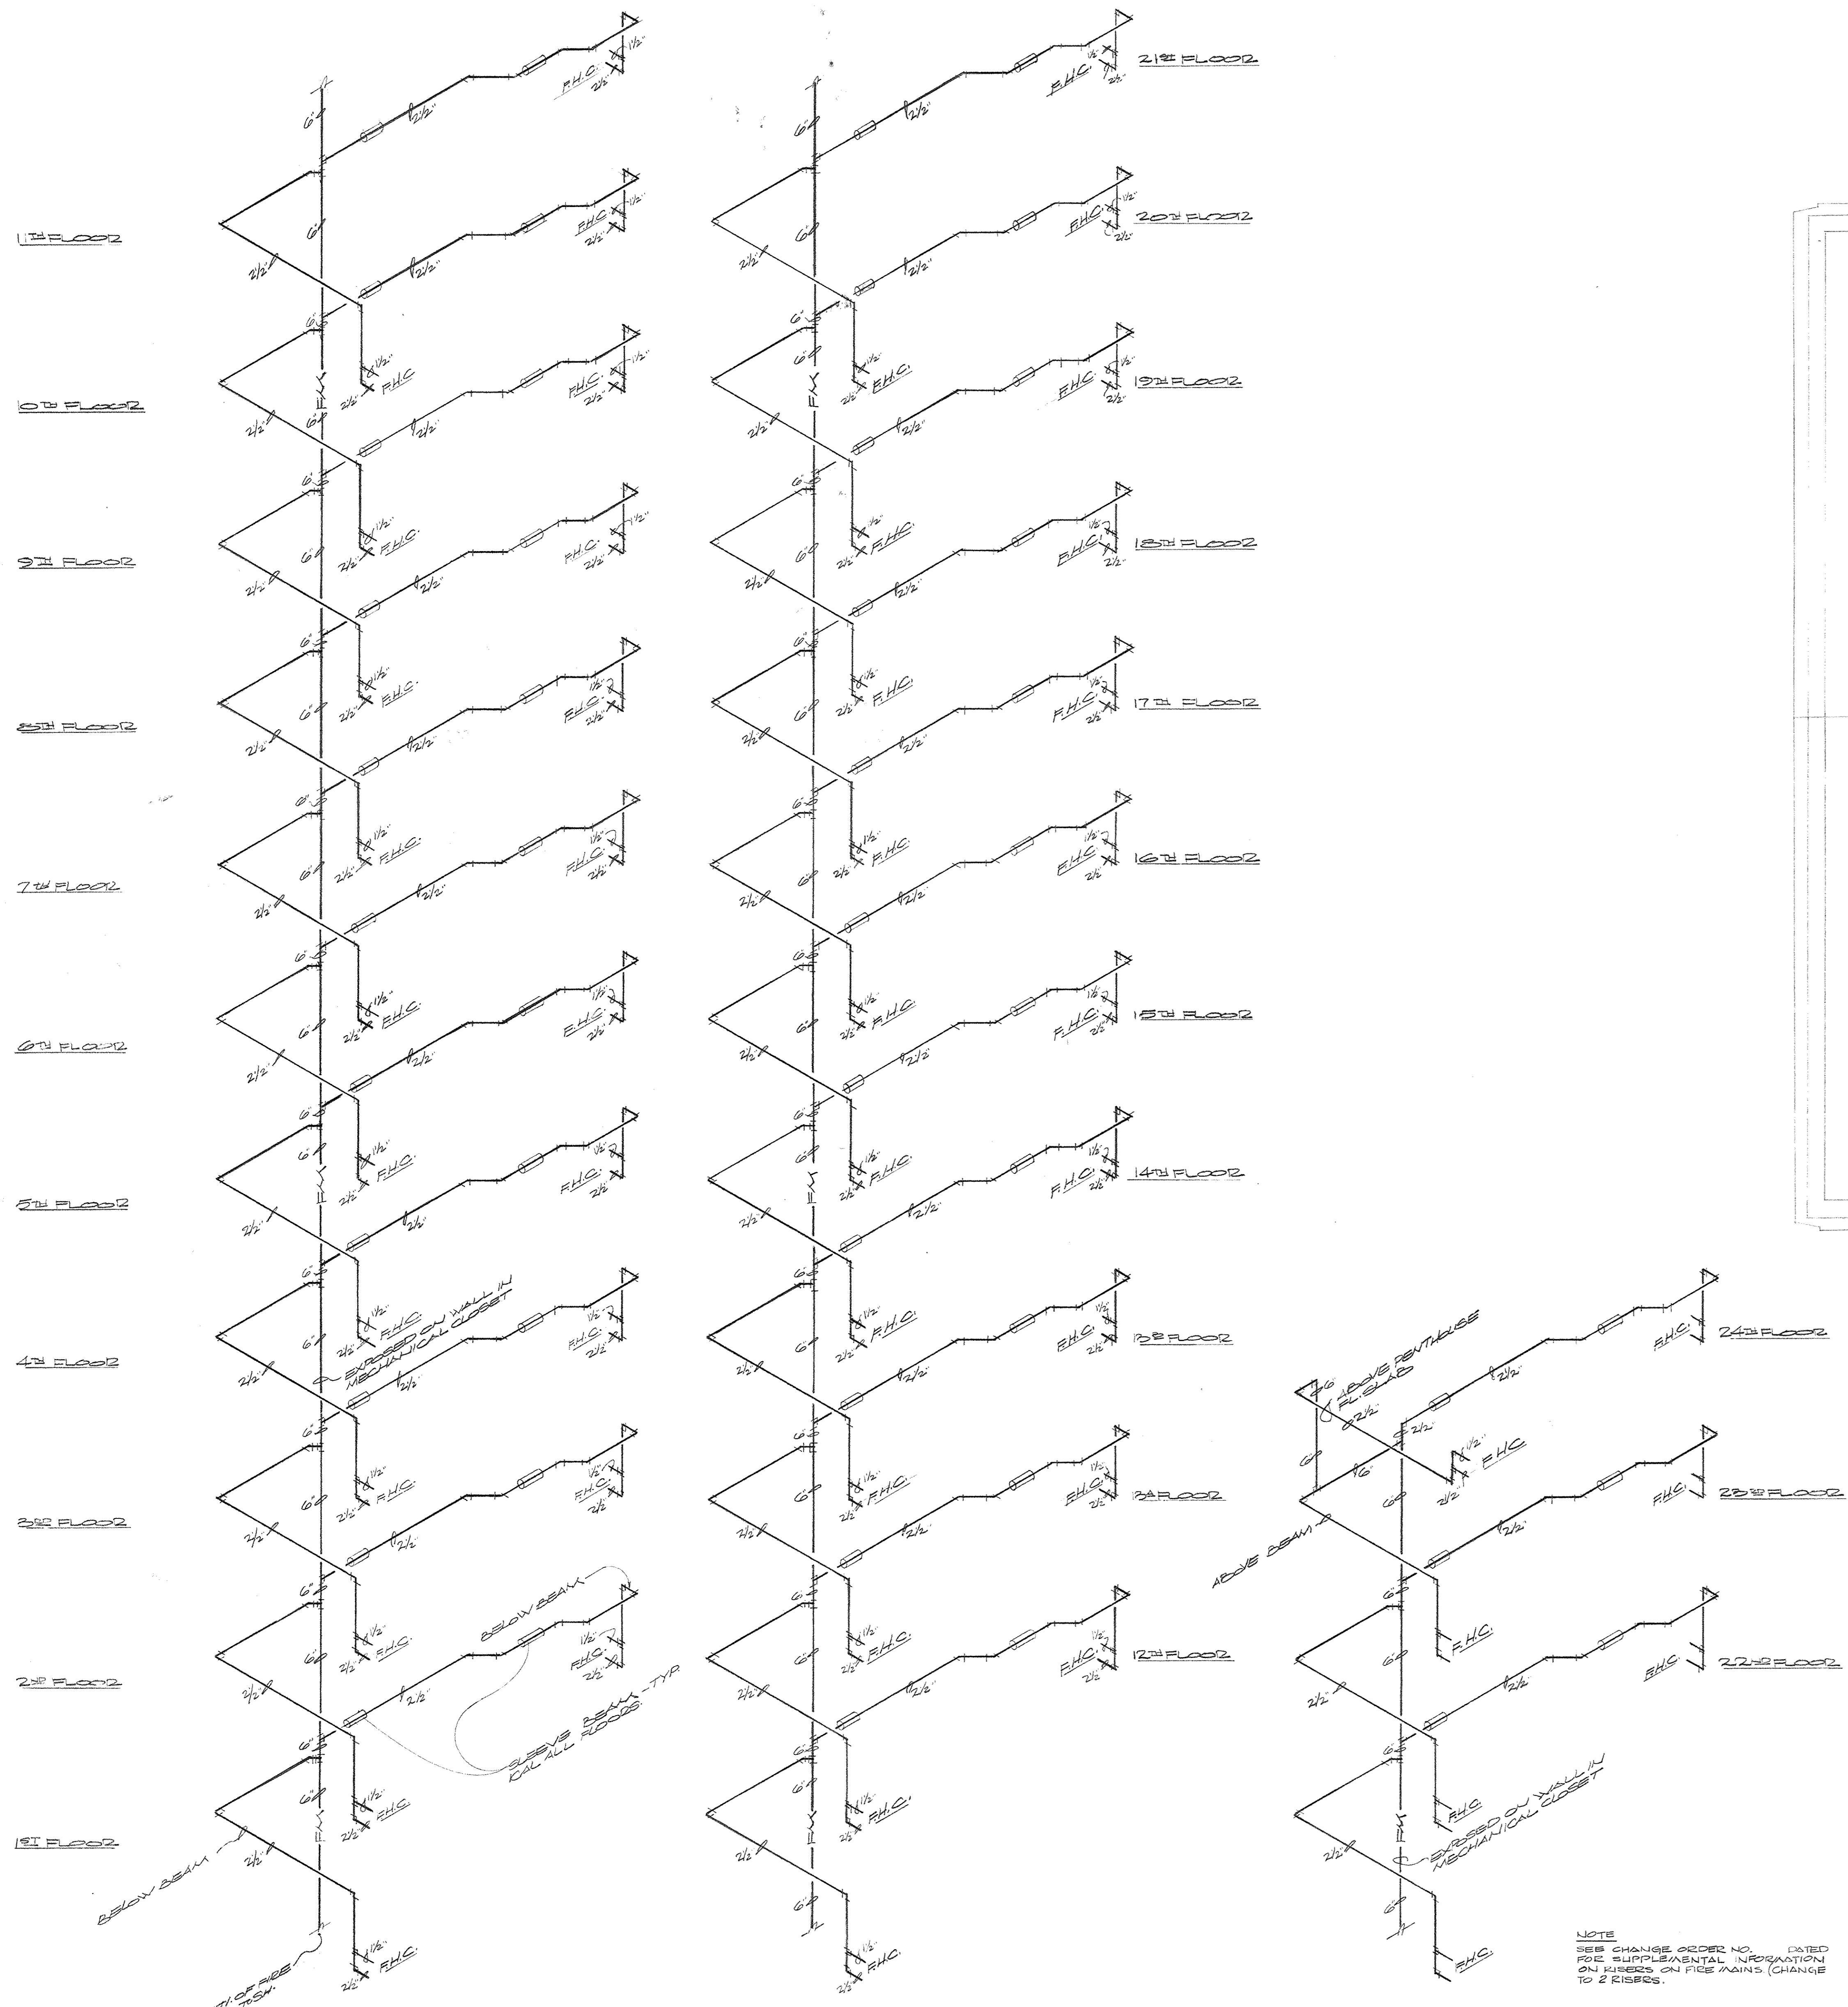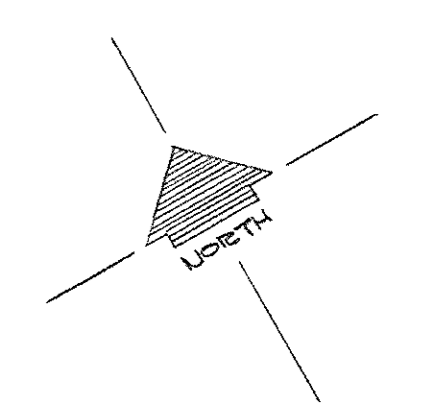

FIRE PROTECTION PIPING DIAGRAM - FIRST THROUGH PENTHOUSE FLOORS
1/8" SCALE

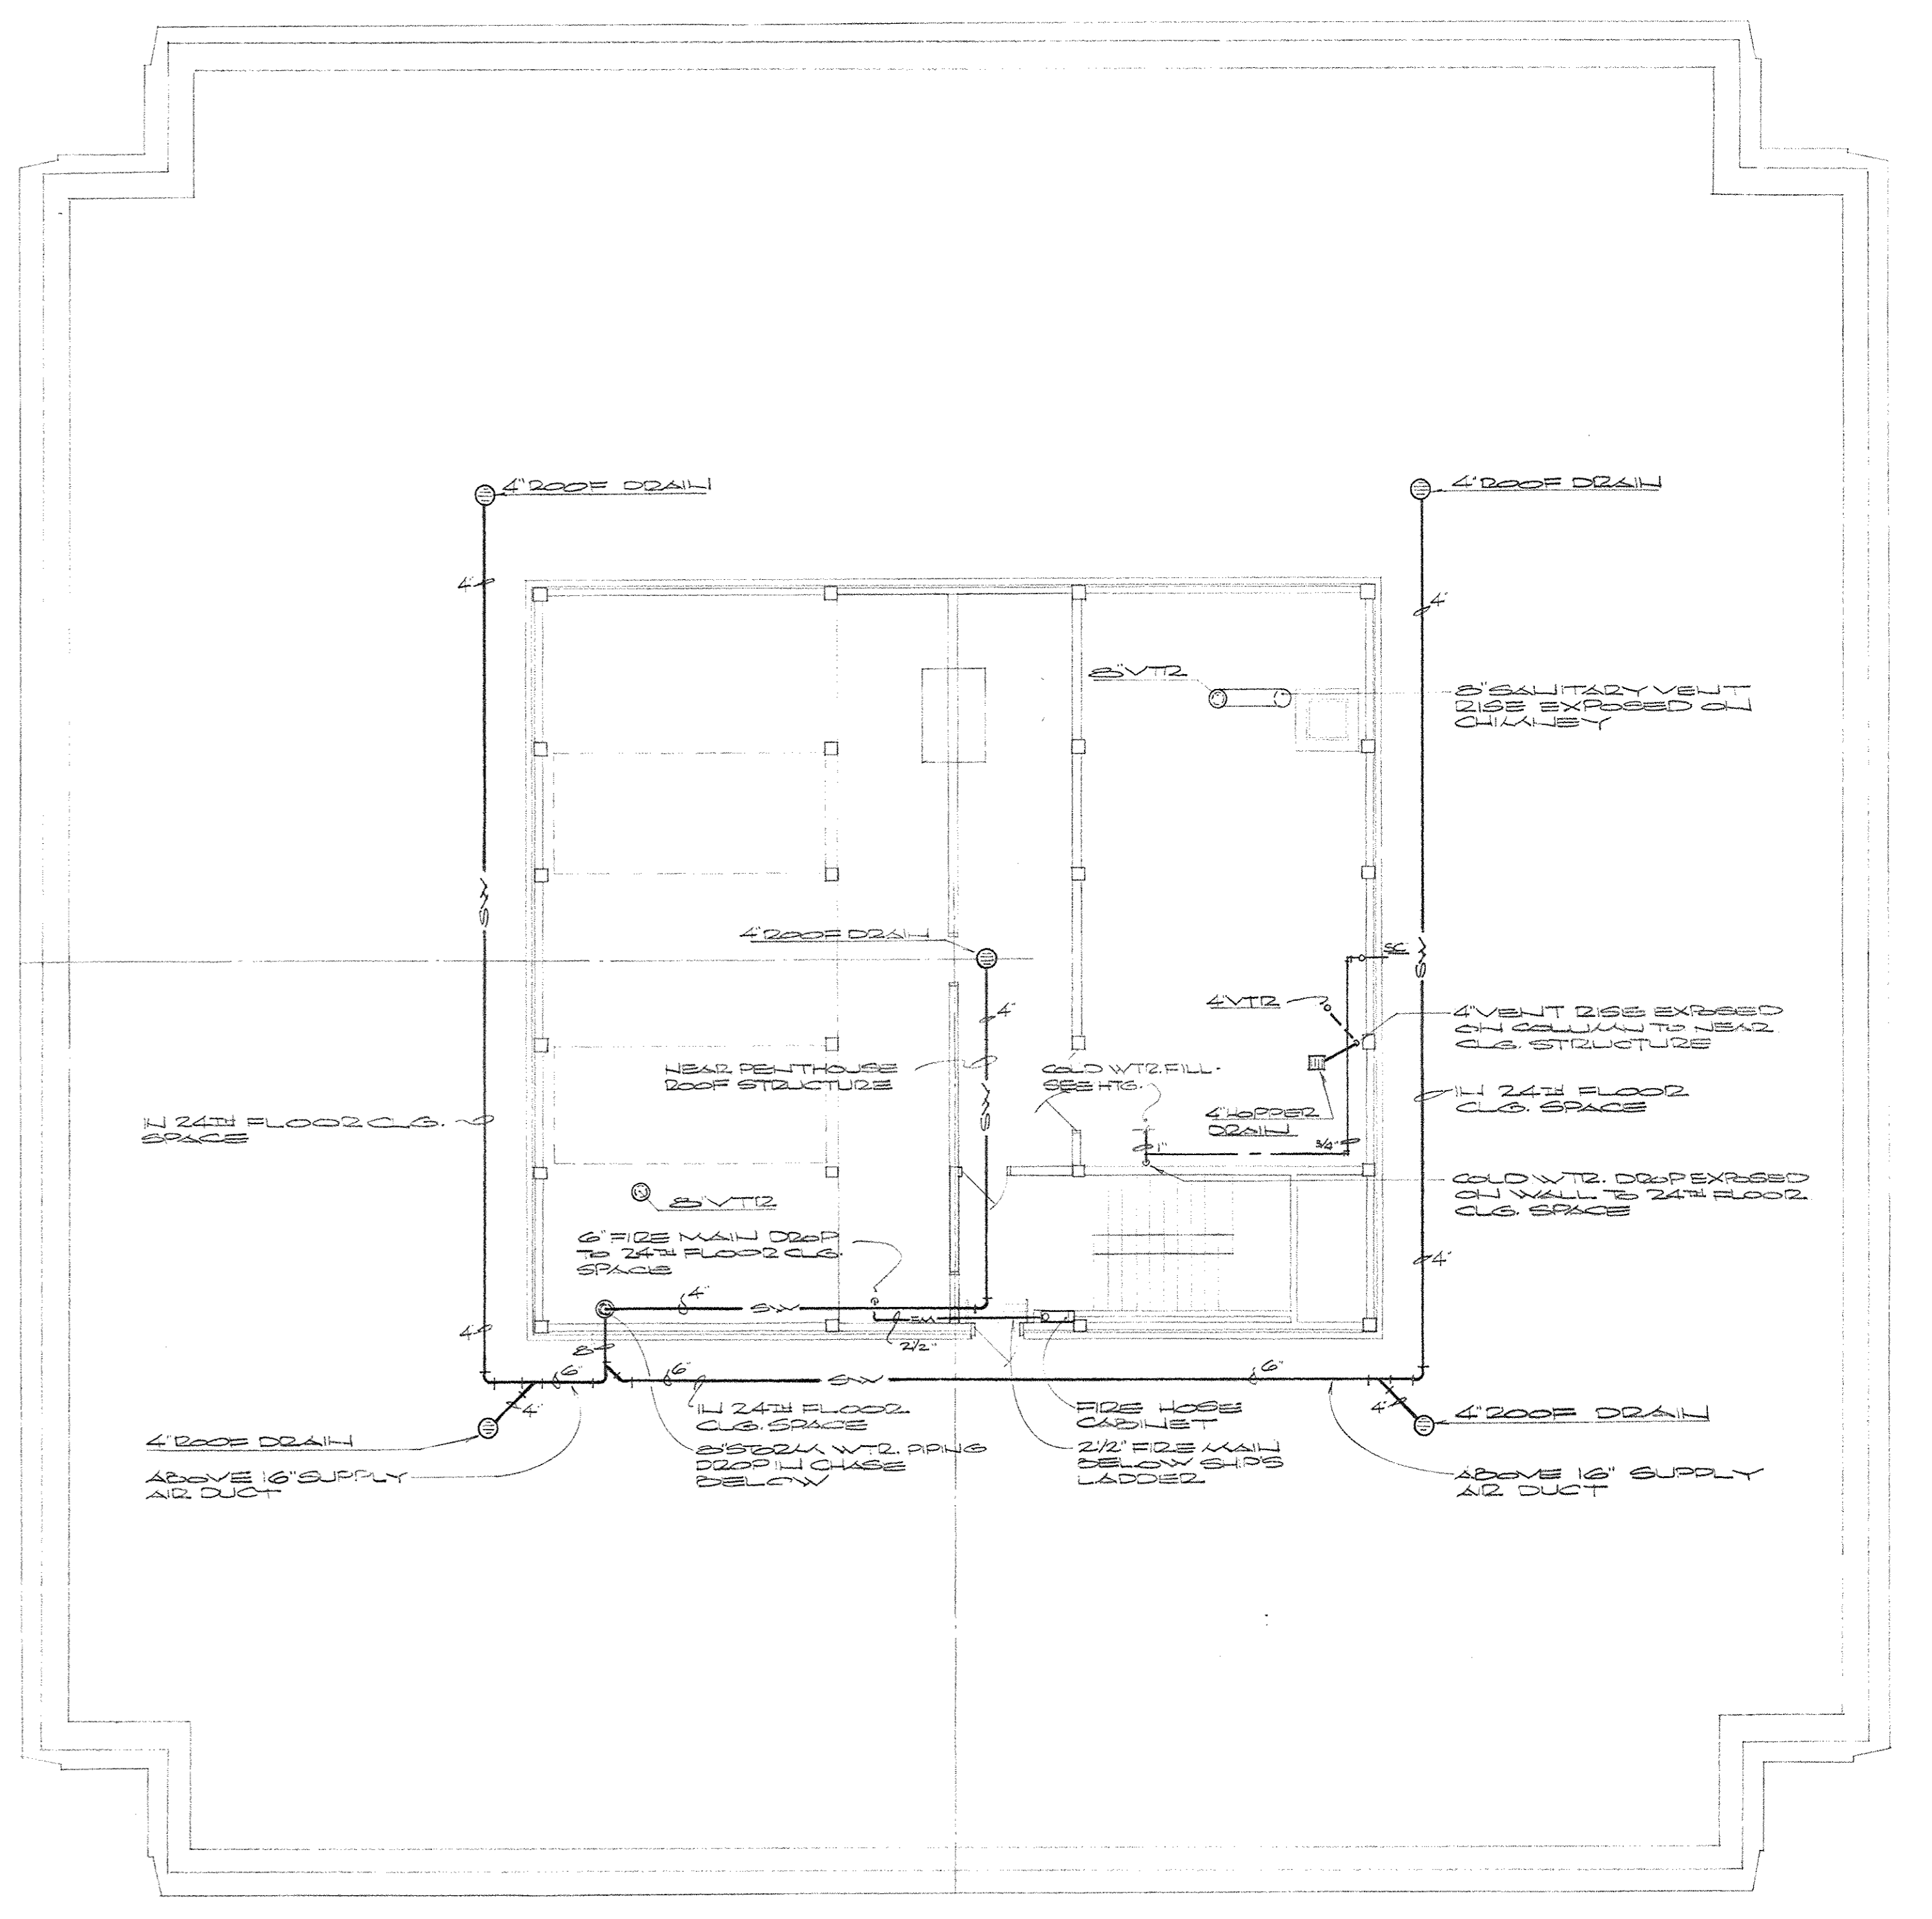


PLUMBING PLAN - PENTHOUSE AND ROOF
SCALE 3/8" = 1'-0"



NOTE
SEE CHANGE ORDER NO. DATED
FOR SUPPLEMENTAL INFORMATION
ON RISERS ON FIVE FLOORS (CHANGE
TO 2 RISERS).

AS-BUILT DRAWINGS
DATE: JAN 73
MUGG, CARYER & BLANKENHORN, INC.


CAPITAL PLAZA OFFICE BUILDING
FRANKFORT, KENTUCKY

DRAWN BY S.M.P.T.	PLUMBING PLAN - ROOF AND PENTHOUSE	DATE 15 MAY 67
TRACED BY S.M.P.T.	ARCHITECT	SCALE AS SHOWN
CHECKED BY S.M.P.T.	EDWARD DURELL STONE 7 EAST 67TH STREET NEW YORK N. Y.	COMM. NO. 5558-81-2
SECTOR NO.	ASSOCIATE ARCHITECTS & ENGINEERS LEE POTTER SMITH & ASSOCIATES 314 WILKINSON FRANKFORT, KENTUCKY	DRAWING NO. P 6 OF 14
APPROVED BY	COMMONWEALTH OF KENTUCKY DEPARTMENT OF FINANCE - ENGINEERING STAFF FRANKFORT, KENTUCKY	DATE
APPROVED BY	ARCHITECT	DATE
APPROVED BY	AGENCY HEAD <i>[Signature]</i>	DATE MAY 24 1967
APPROVED BY	OWNER	DATE

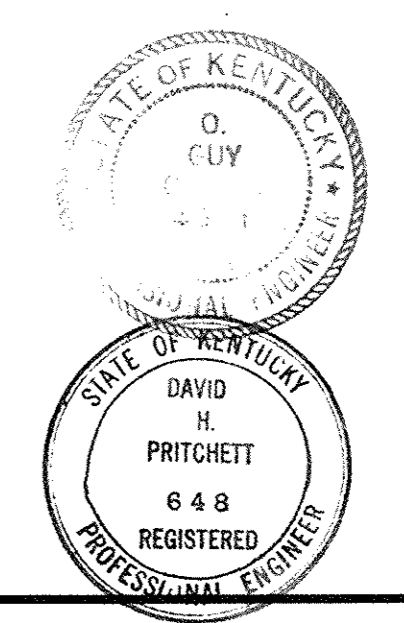


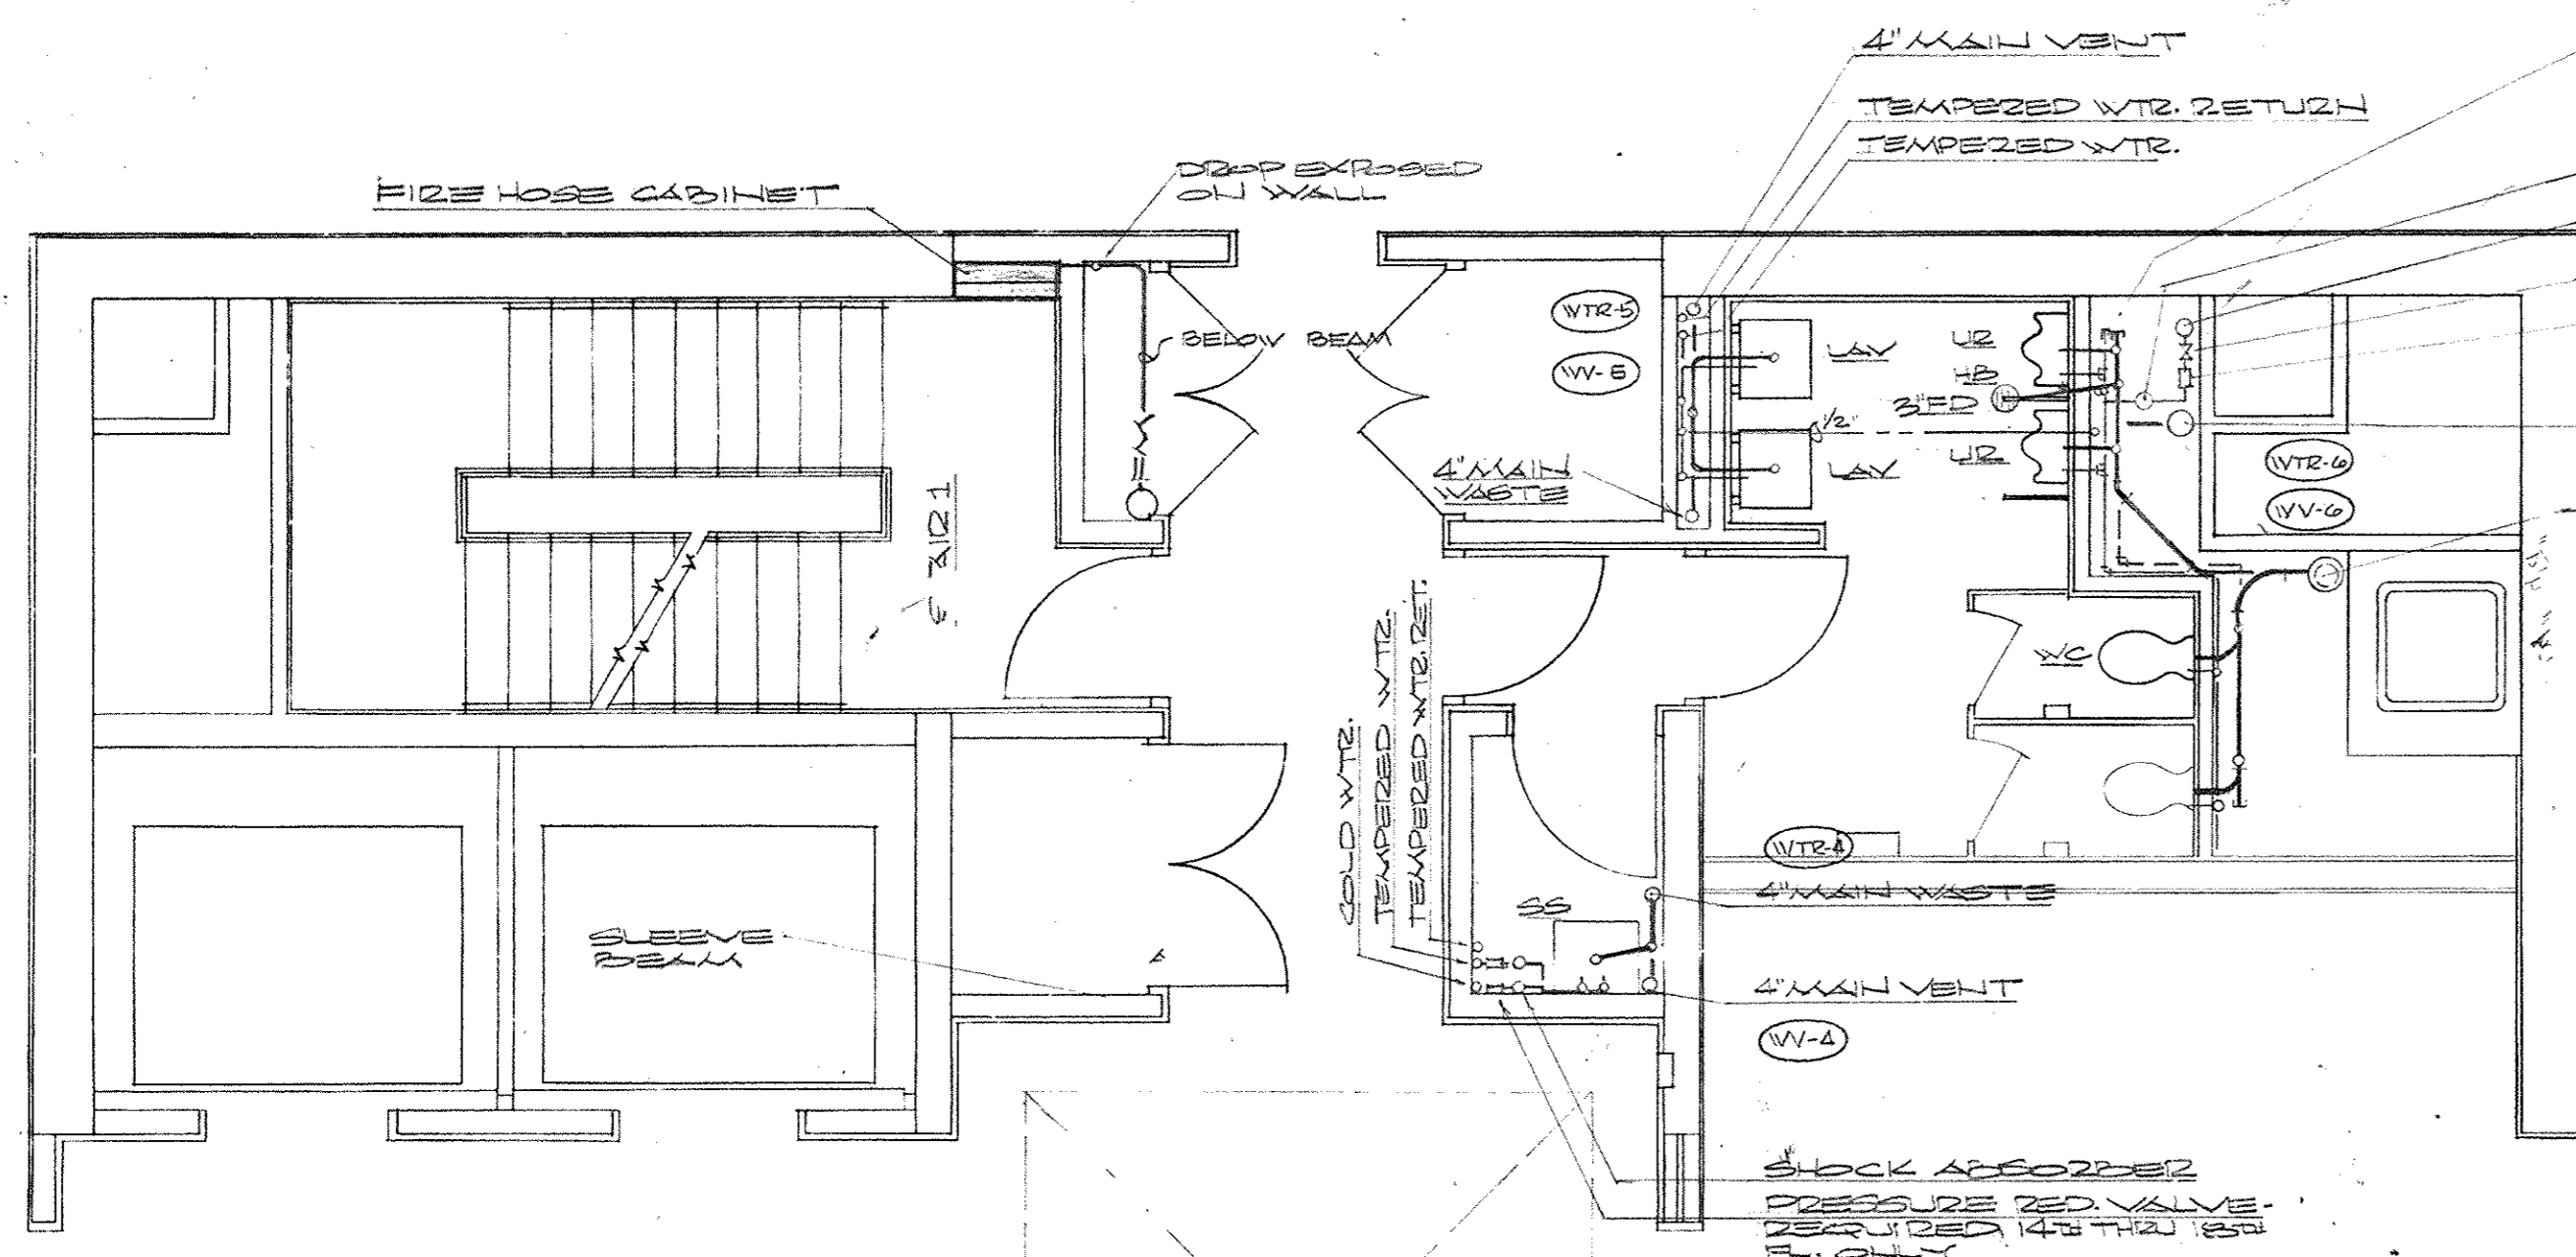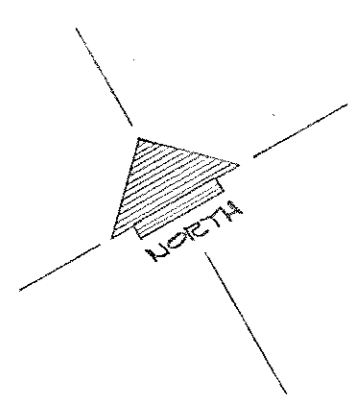

CAROFF 1\"/>

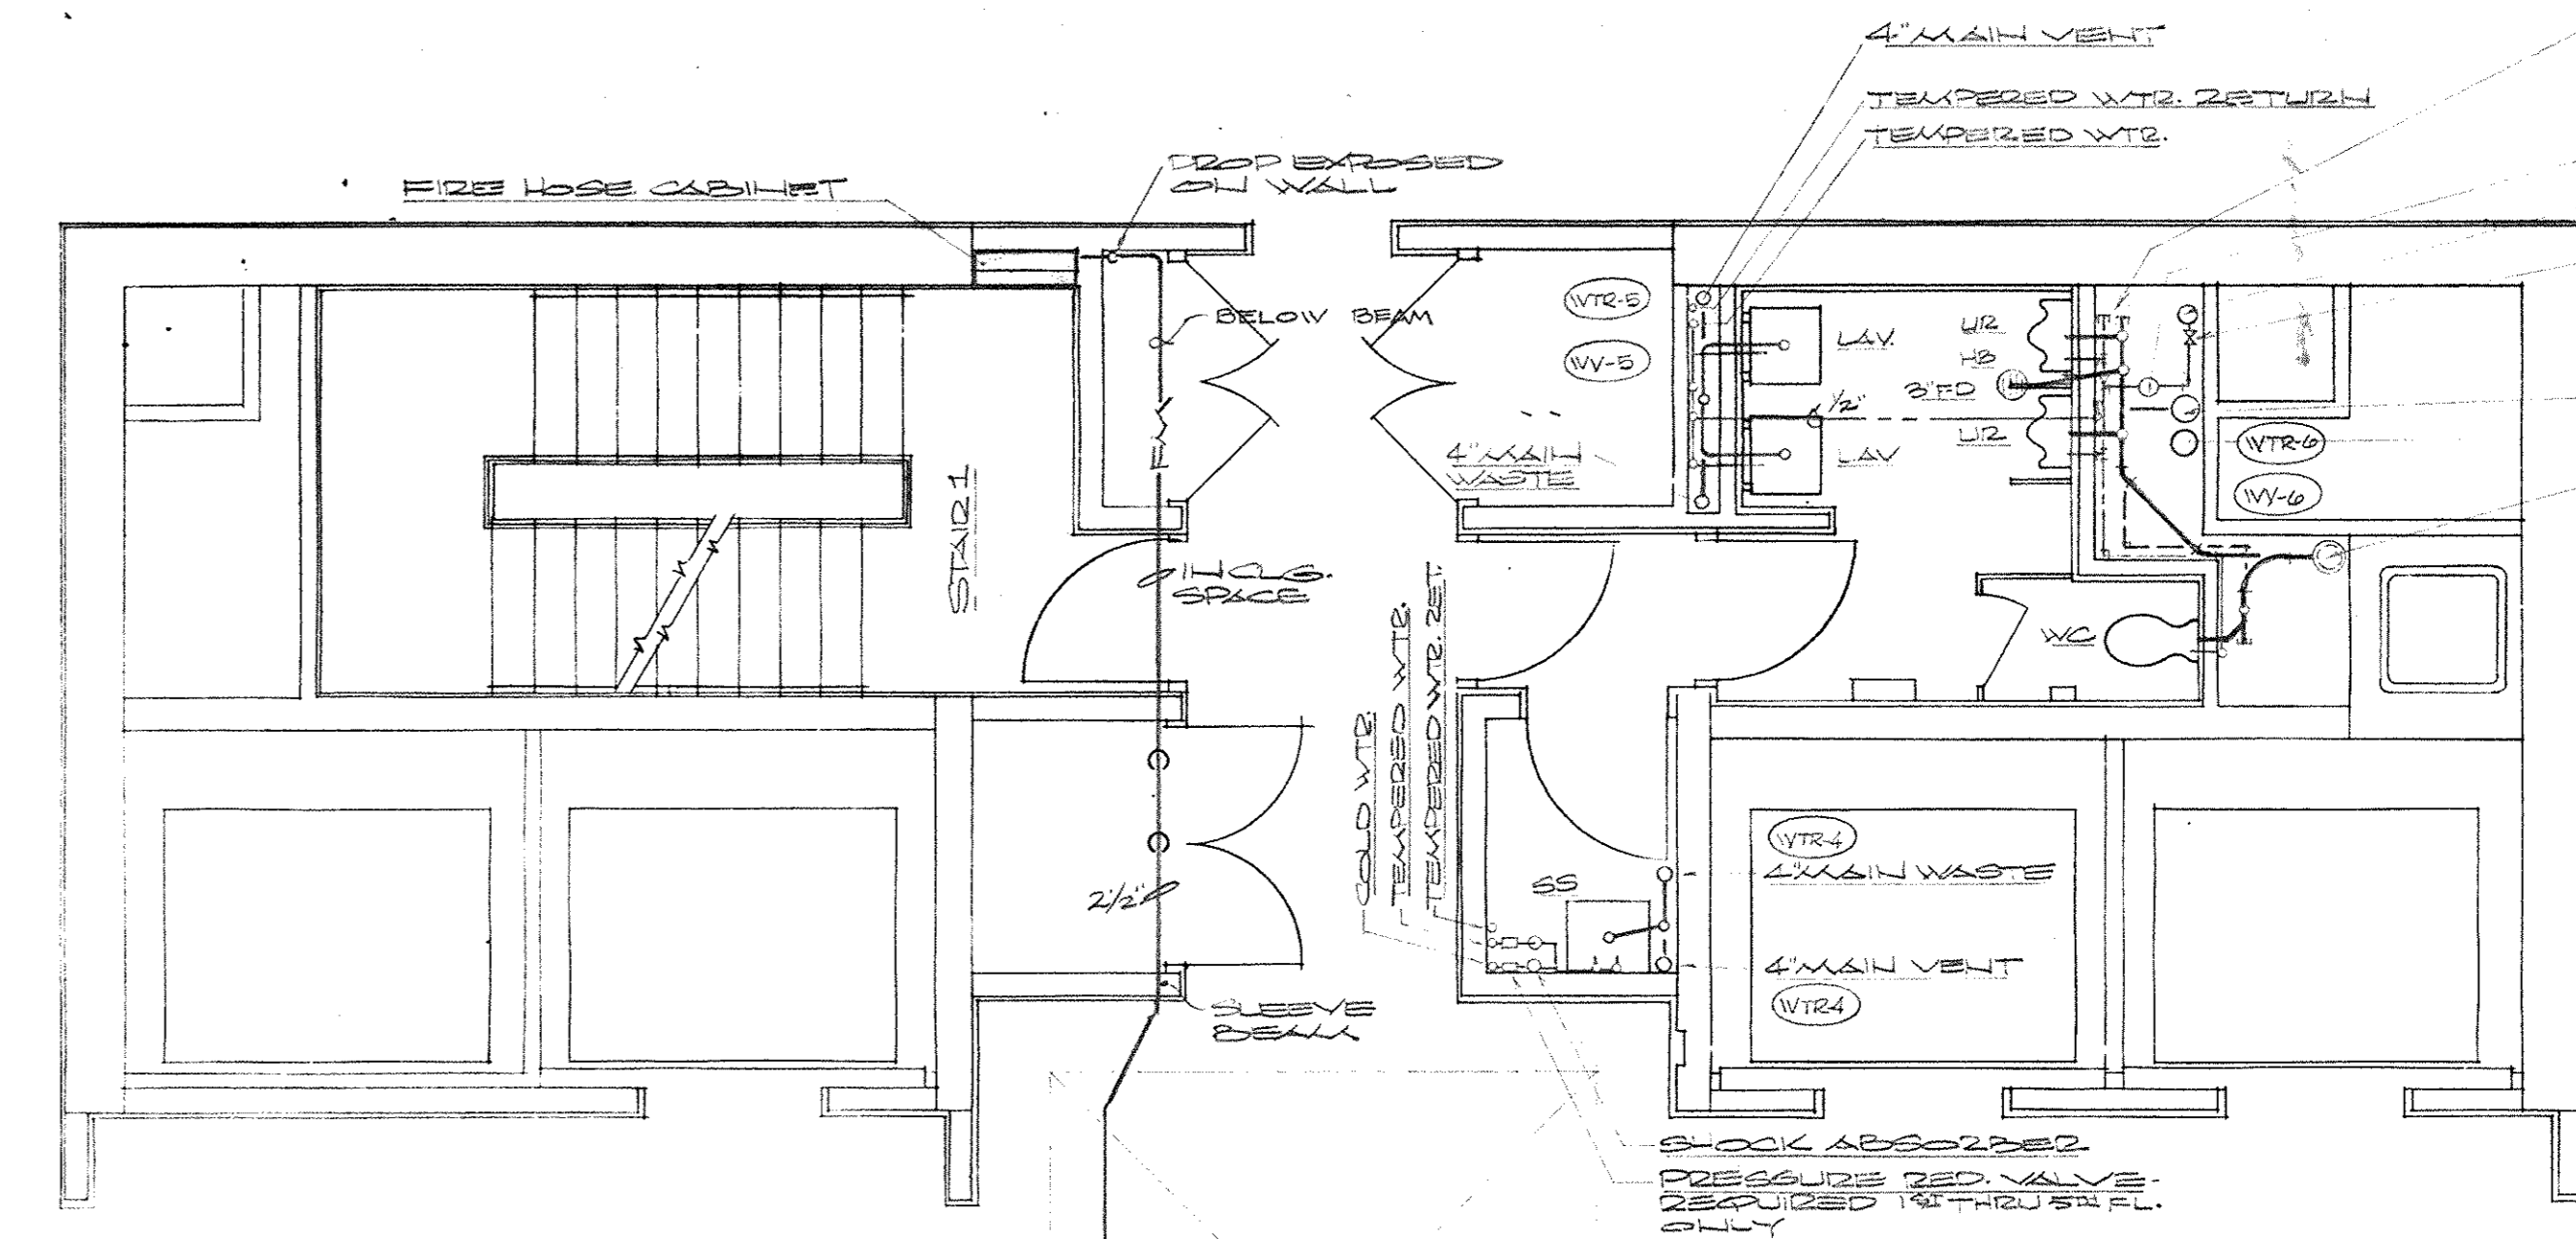


CAROFF 1\"/>

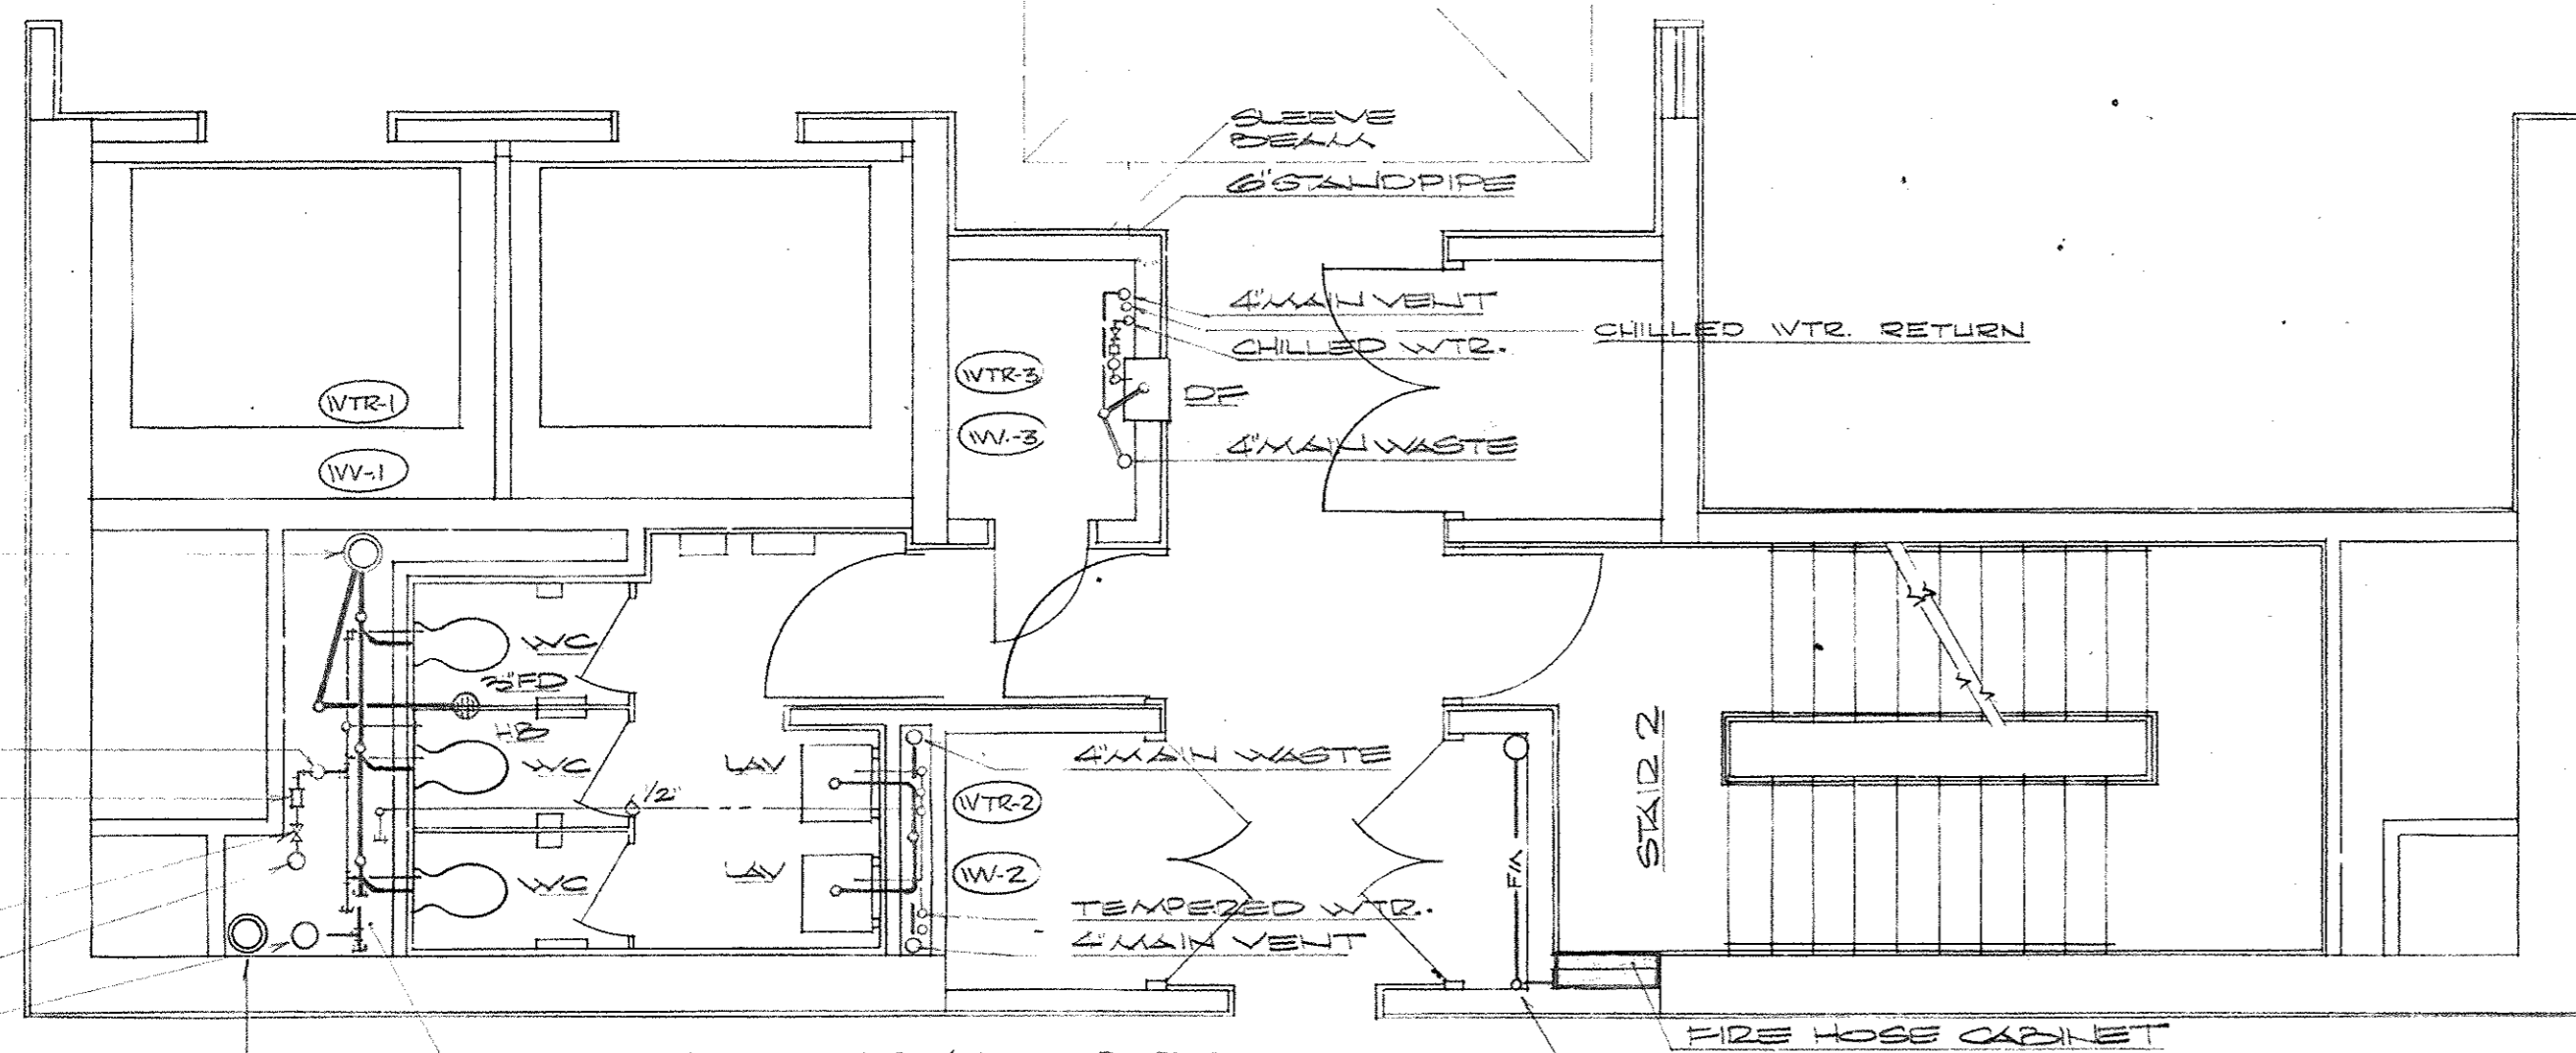


SHOCK ABSORBER
 POSSIBLE RED VALVE
 REQUIRED AT THIS END
 ONLY
 GATE VALVE
 COLD WTR MAIN
 4\"/>

PLUMBING PLAN - ENLARGED CORE - 14TH TO 23RD FLOOR
 SCALE: 1/4\"/>


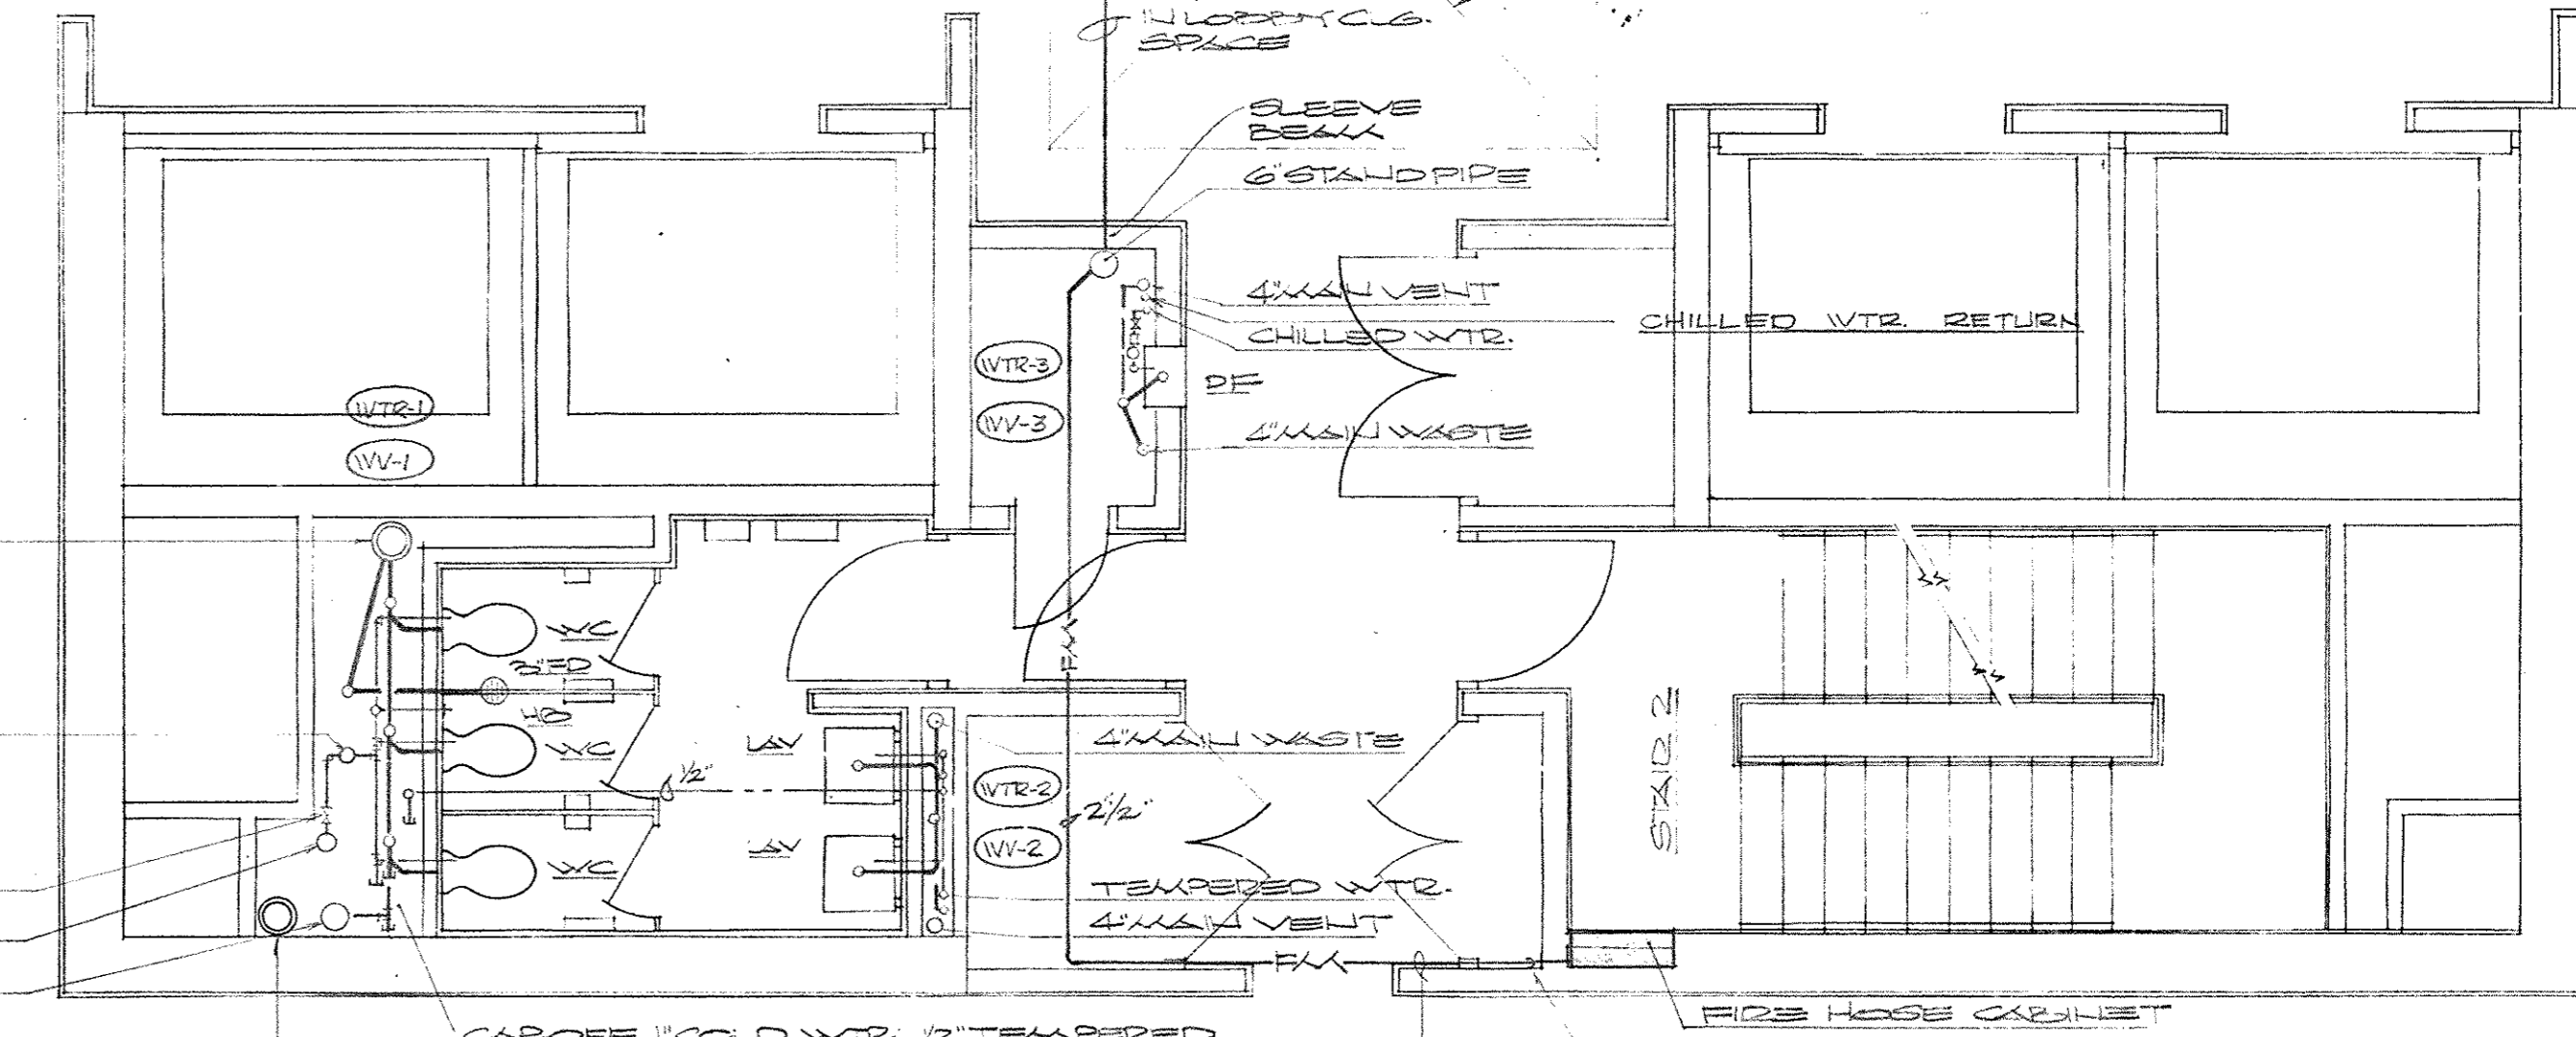


SHOCK ABSORBER
 GATE VALVE
 COLD WTR MAIN
 4\"/>

PLUMBING PLAN - ENLARGED CORE - 15TH TO 12TH FLOOR
 SCALE: 1/4\"/>

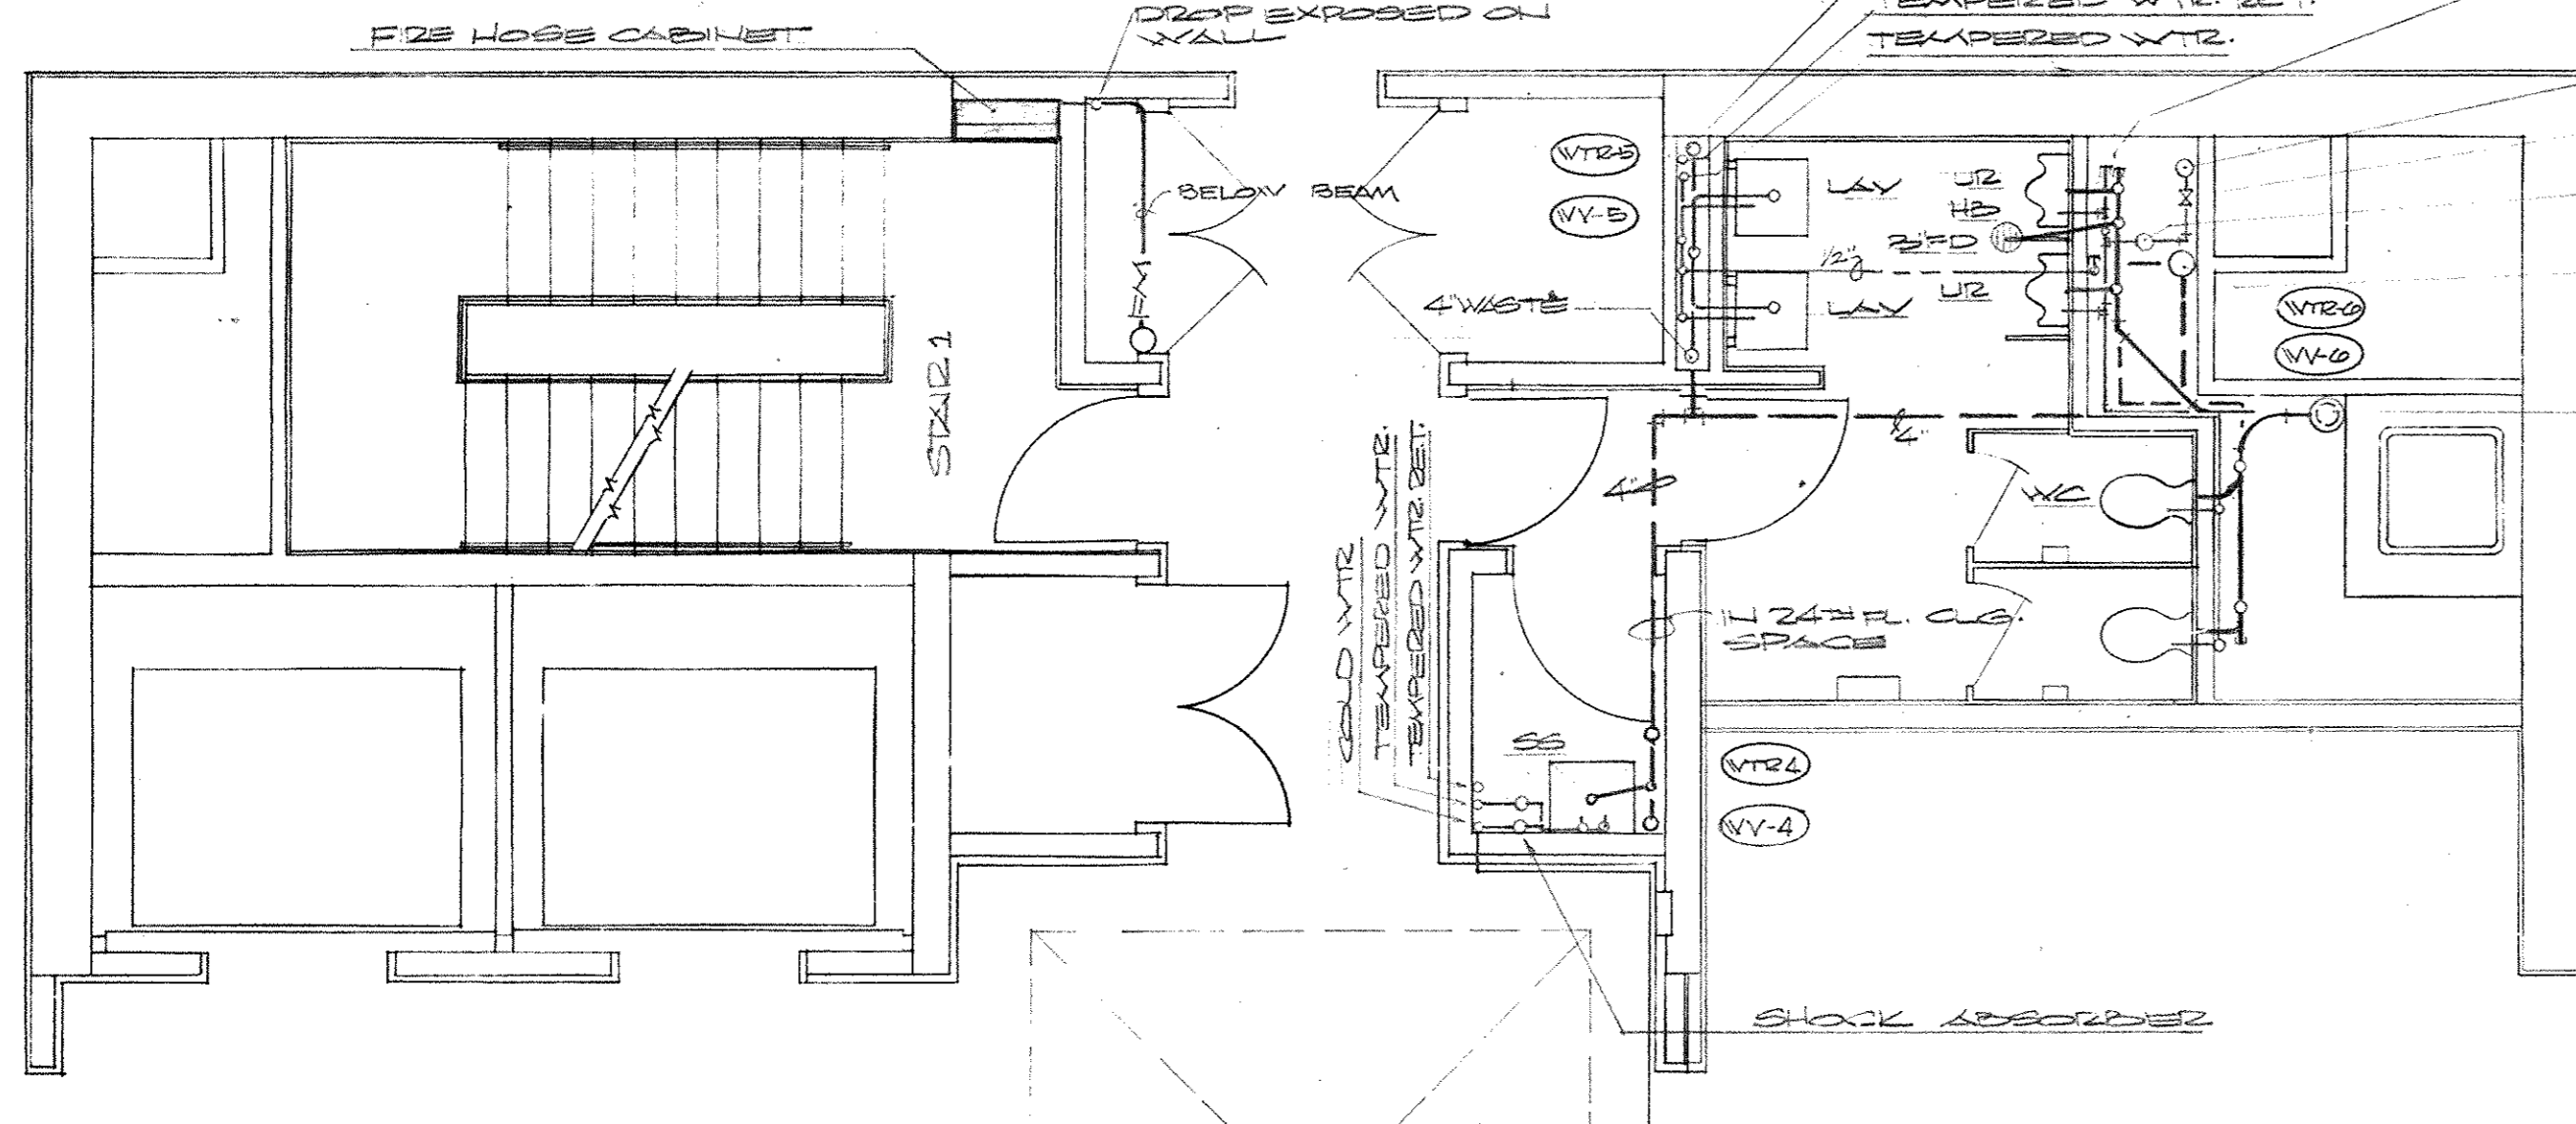

CAROFF 1\"/>

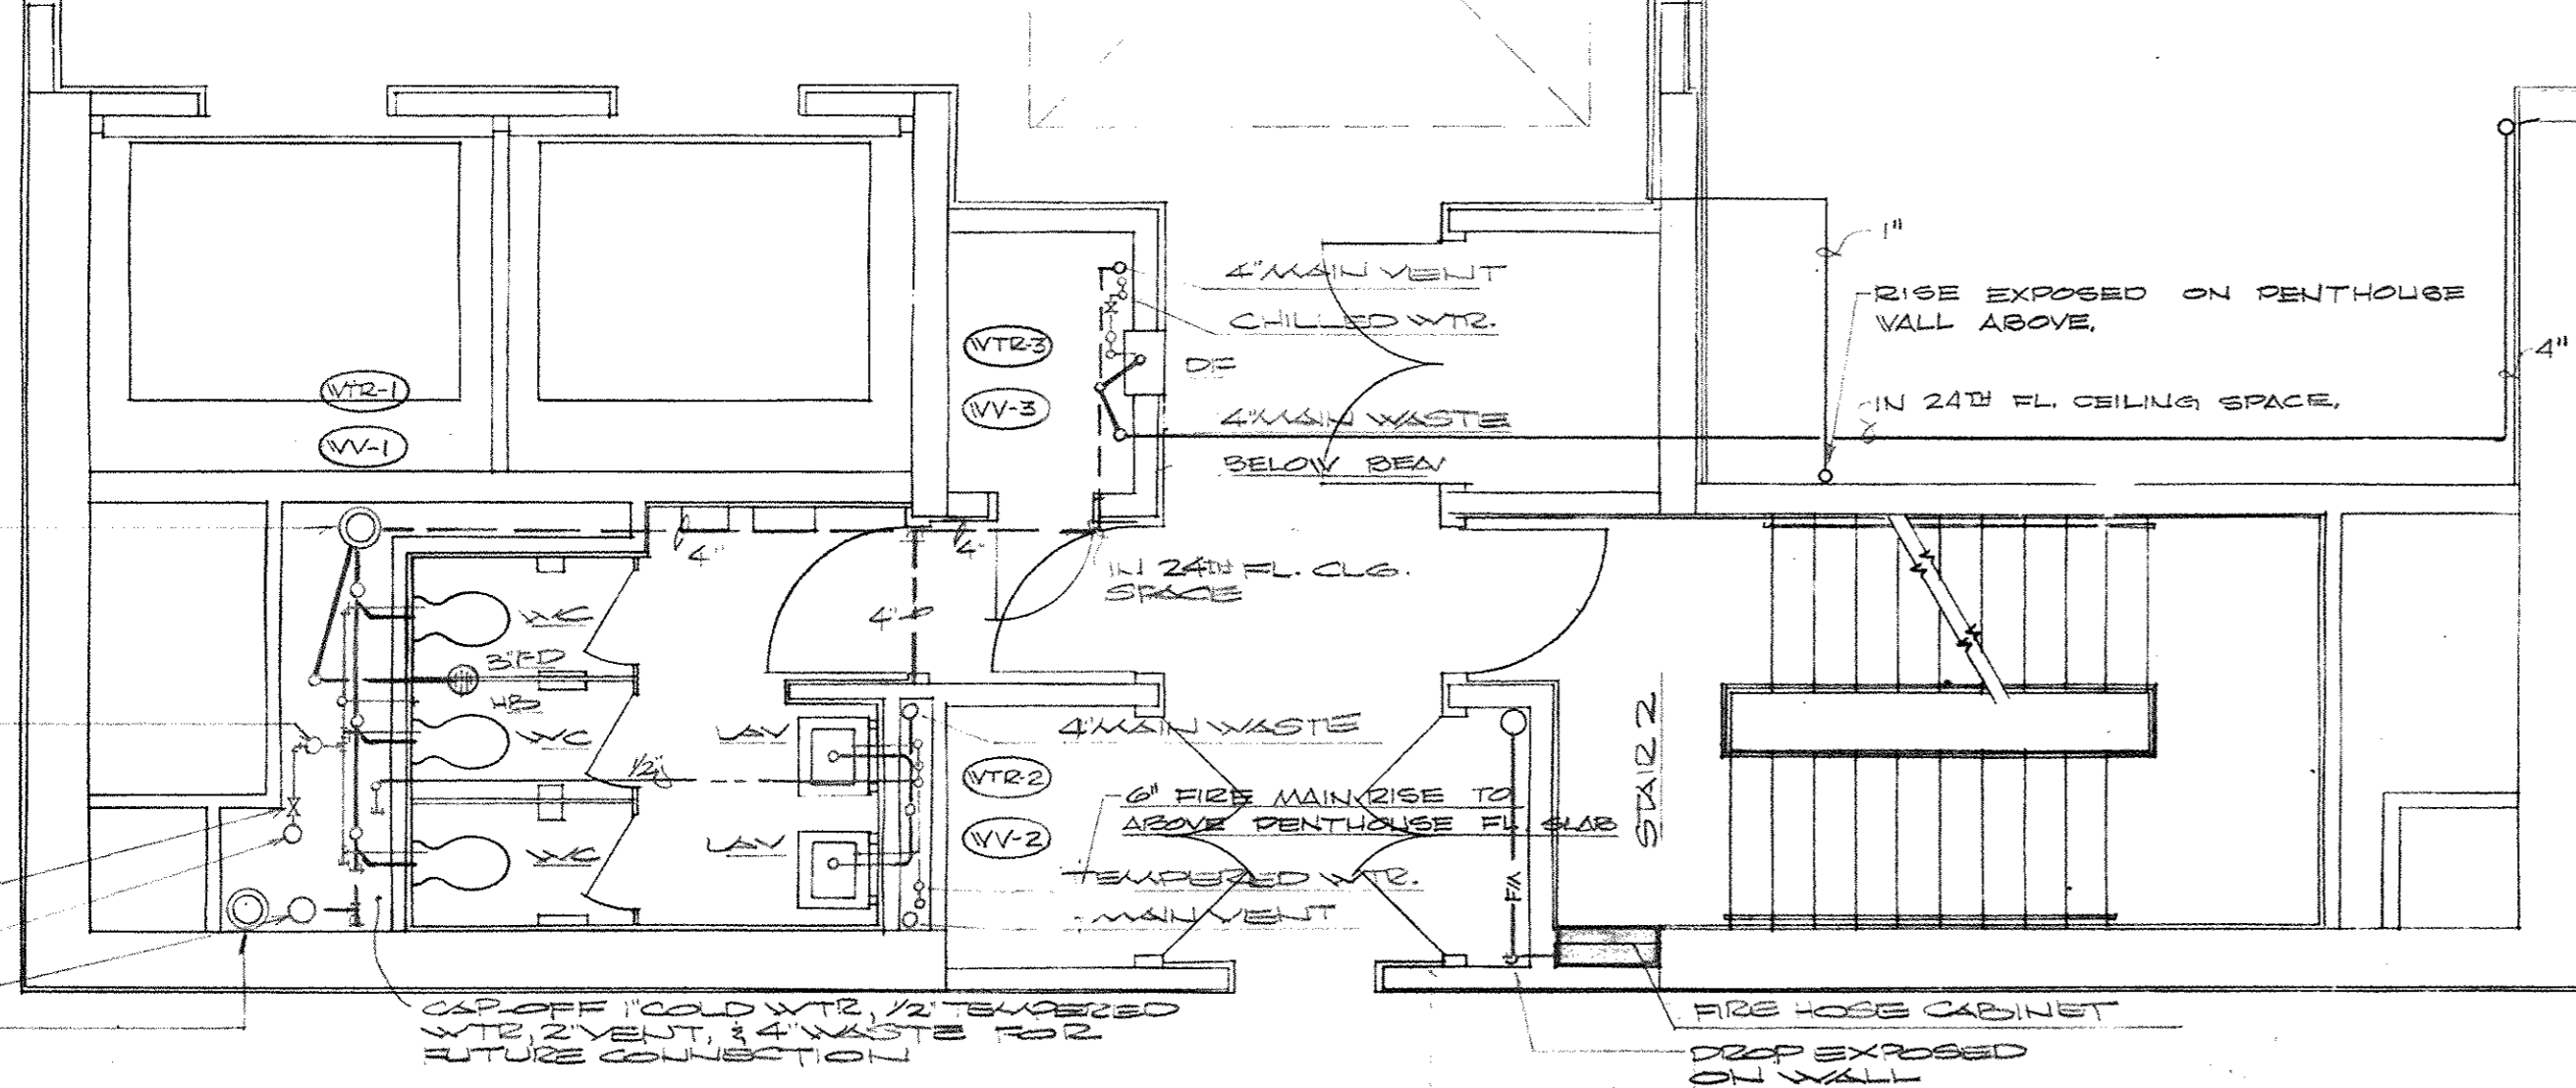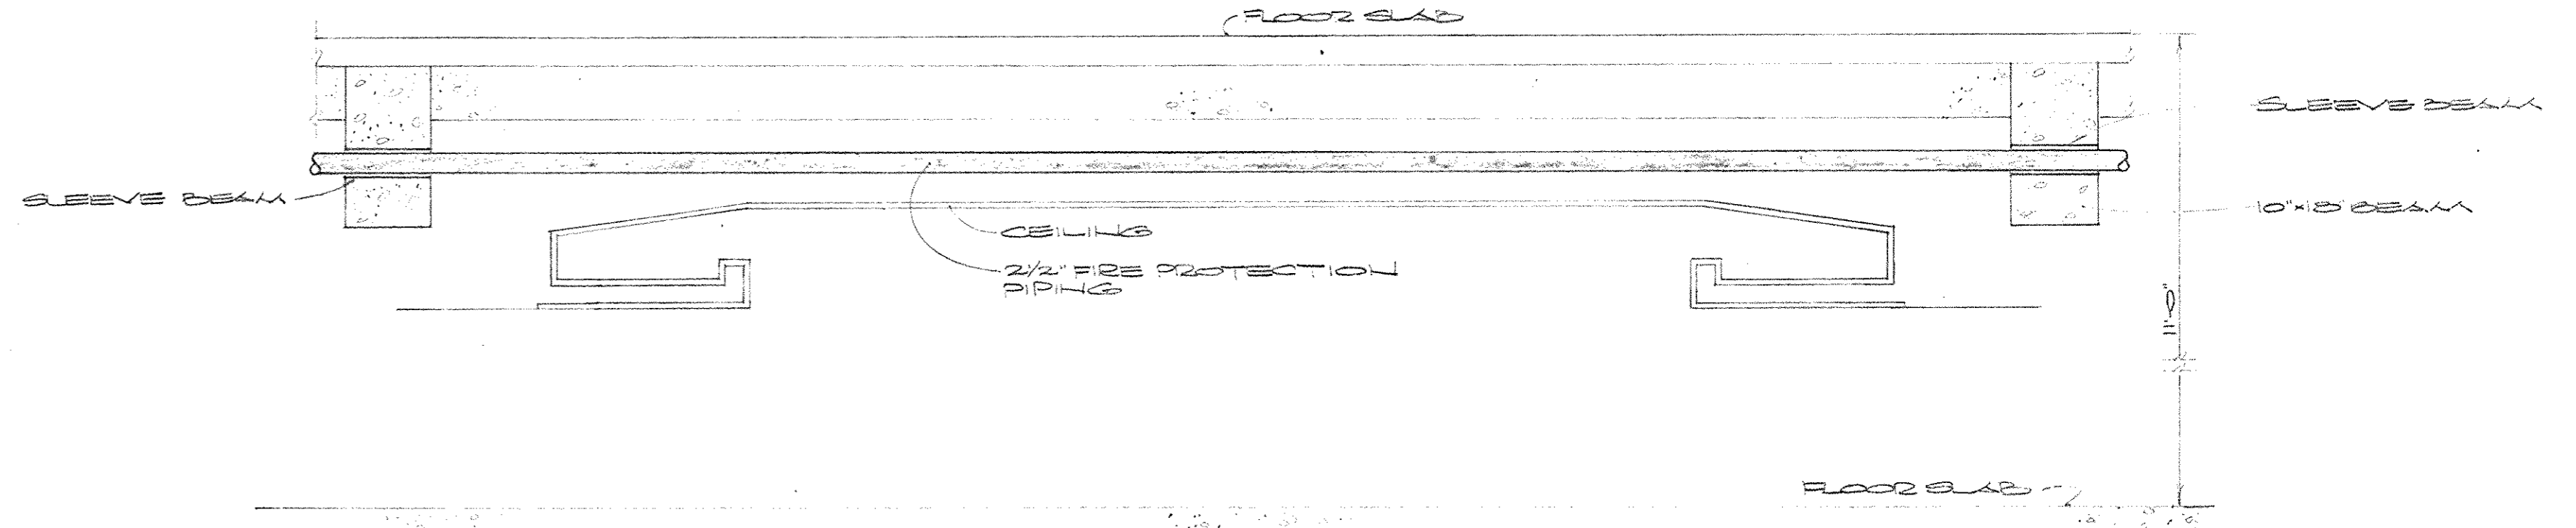


RISE TO HOPPER DRAIN
 IN PENTHOUSE ABOVE
 REFER TO SHT P-6

4\"/>

PLUMBING PLAN - ENLARGED CORE - 24TH FLOOR
 SCALE: 1/4\"/>


AS-BUILT DRAWINGS
 DATE: JAN 73
 HUGG, CARTER & BLAKEMAN, INC.

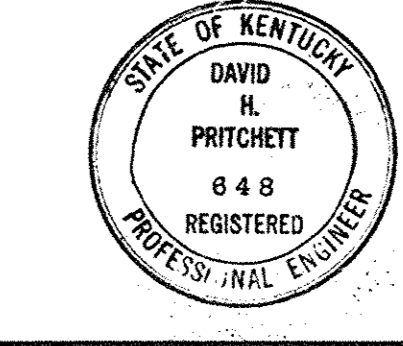

CAPITAL PLAZA OFFICE BUILDING		
FRANKFORT, KENTUCKY		
DRAWN BY	PLUMBING PLAN - ENLARGED CORES - 1ST THRU 24TH FLOOR	DATE
TRACED BY	EDWARD DURELL STONE	SCALE
CHECKED BY	7 EAST 6TH STREET NEW YORK, N. Y.	COMM. NO.
SECTOR NO.	ASSOCIATE ARCHITECTS & ENGINEERS	DRAWING NO.
	LEE POTTER SMITH & ASSOCIATES	P 7
	314 WILKINSON FRANKFORT, KENTUCKY	OF 12
	COMMONWEALTH OF KENTUCKY	
	DEPARTMENT OF FINANCE - ENGINEERING STAFF	
APPROVED BY	ARCHITECT	DATE
APPROVED BY	AGENCY HEAD	DATE
APPROVED BY	OWNER	DATE


CPA-107

NOTE:
 TO BE CONTINUED TO SHEET 101-11-11-12
 TO SANITARY WASTE & VENT PIPING
 DIAGRAMS, SHEET 101-11-11-12

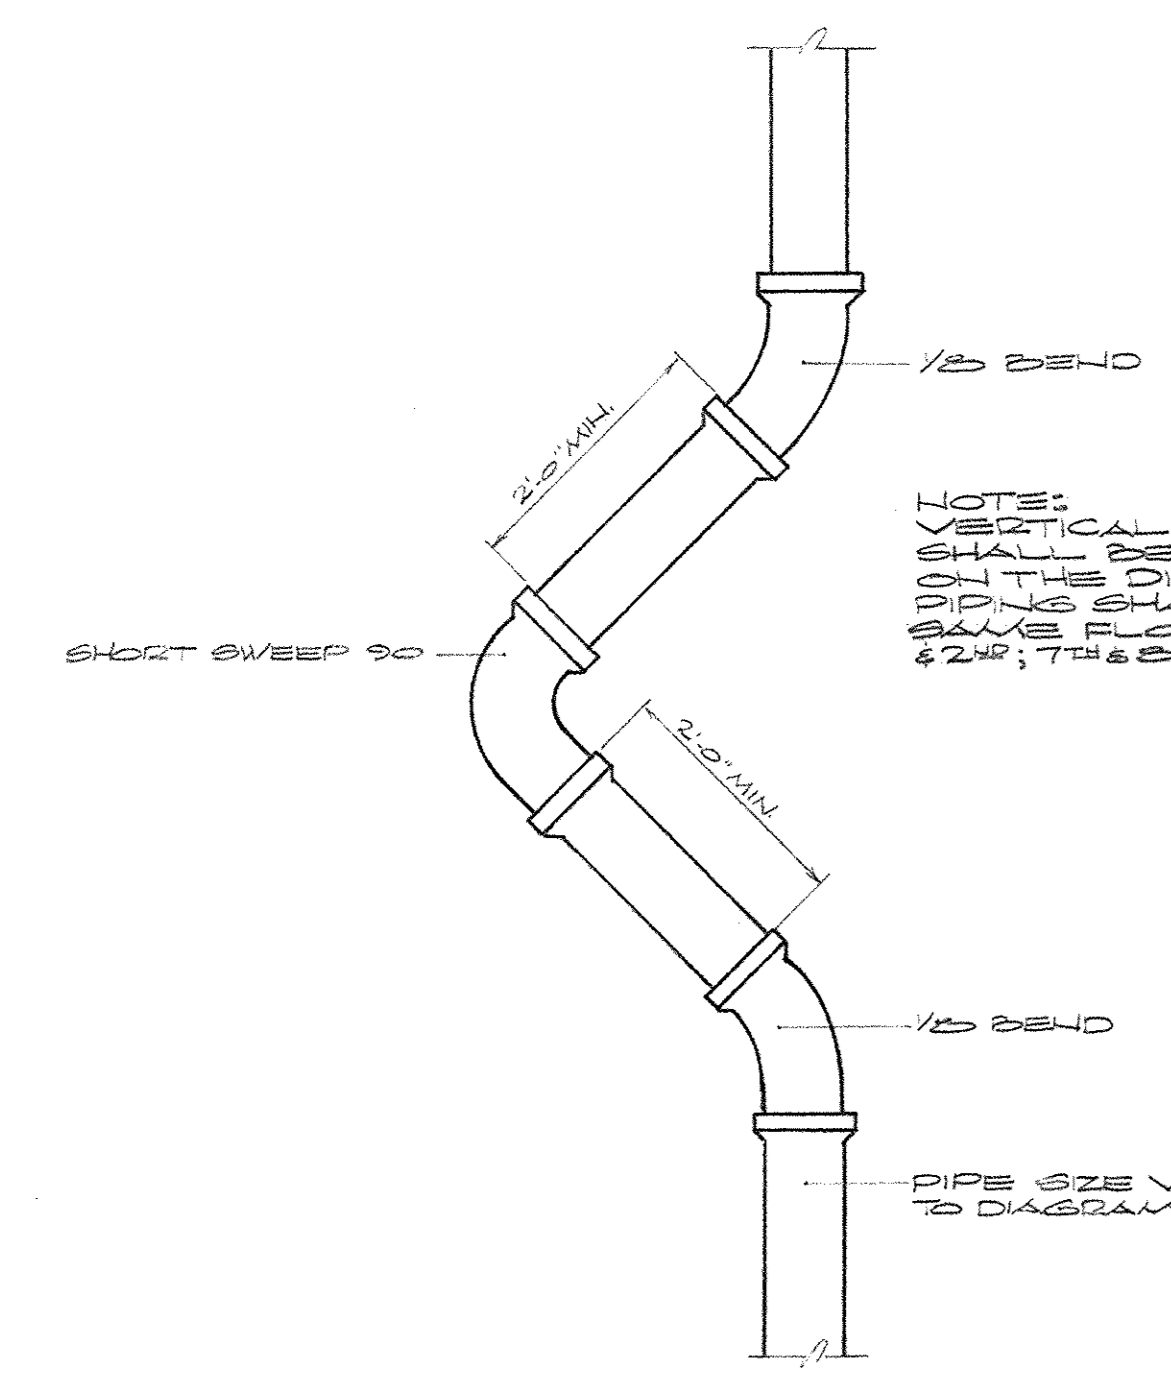


NOTE:
 VERTICAL SANITARY SEWER MAINS
 SHALL BE OFFSET WHERE SHOWN
 ON THIS DIAGRAM. STORM SEWER
 SHALL BE STRAIGHT AT THE
 SAME FLOOR LEVELS (BETWEEN 1ST
 & 2ND, 2ND & 3RD, 3RD & 4TH, 4TH & 5TH FLOORS)

DETAIL OF "OFF-SET" IN MAIN VERTICAL SEWER PIPING
 NO SCALE

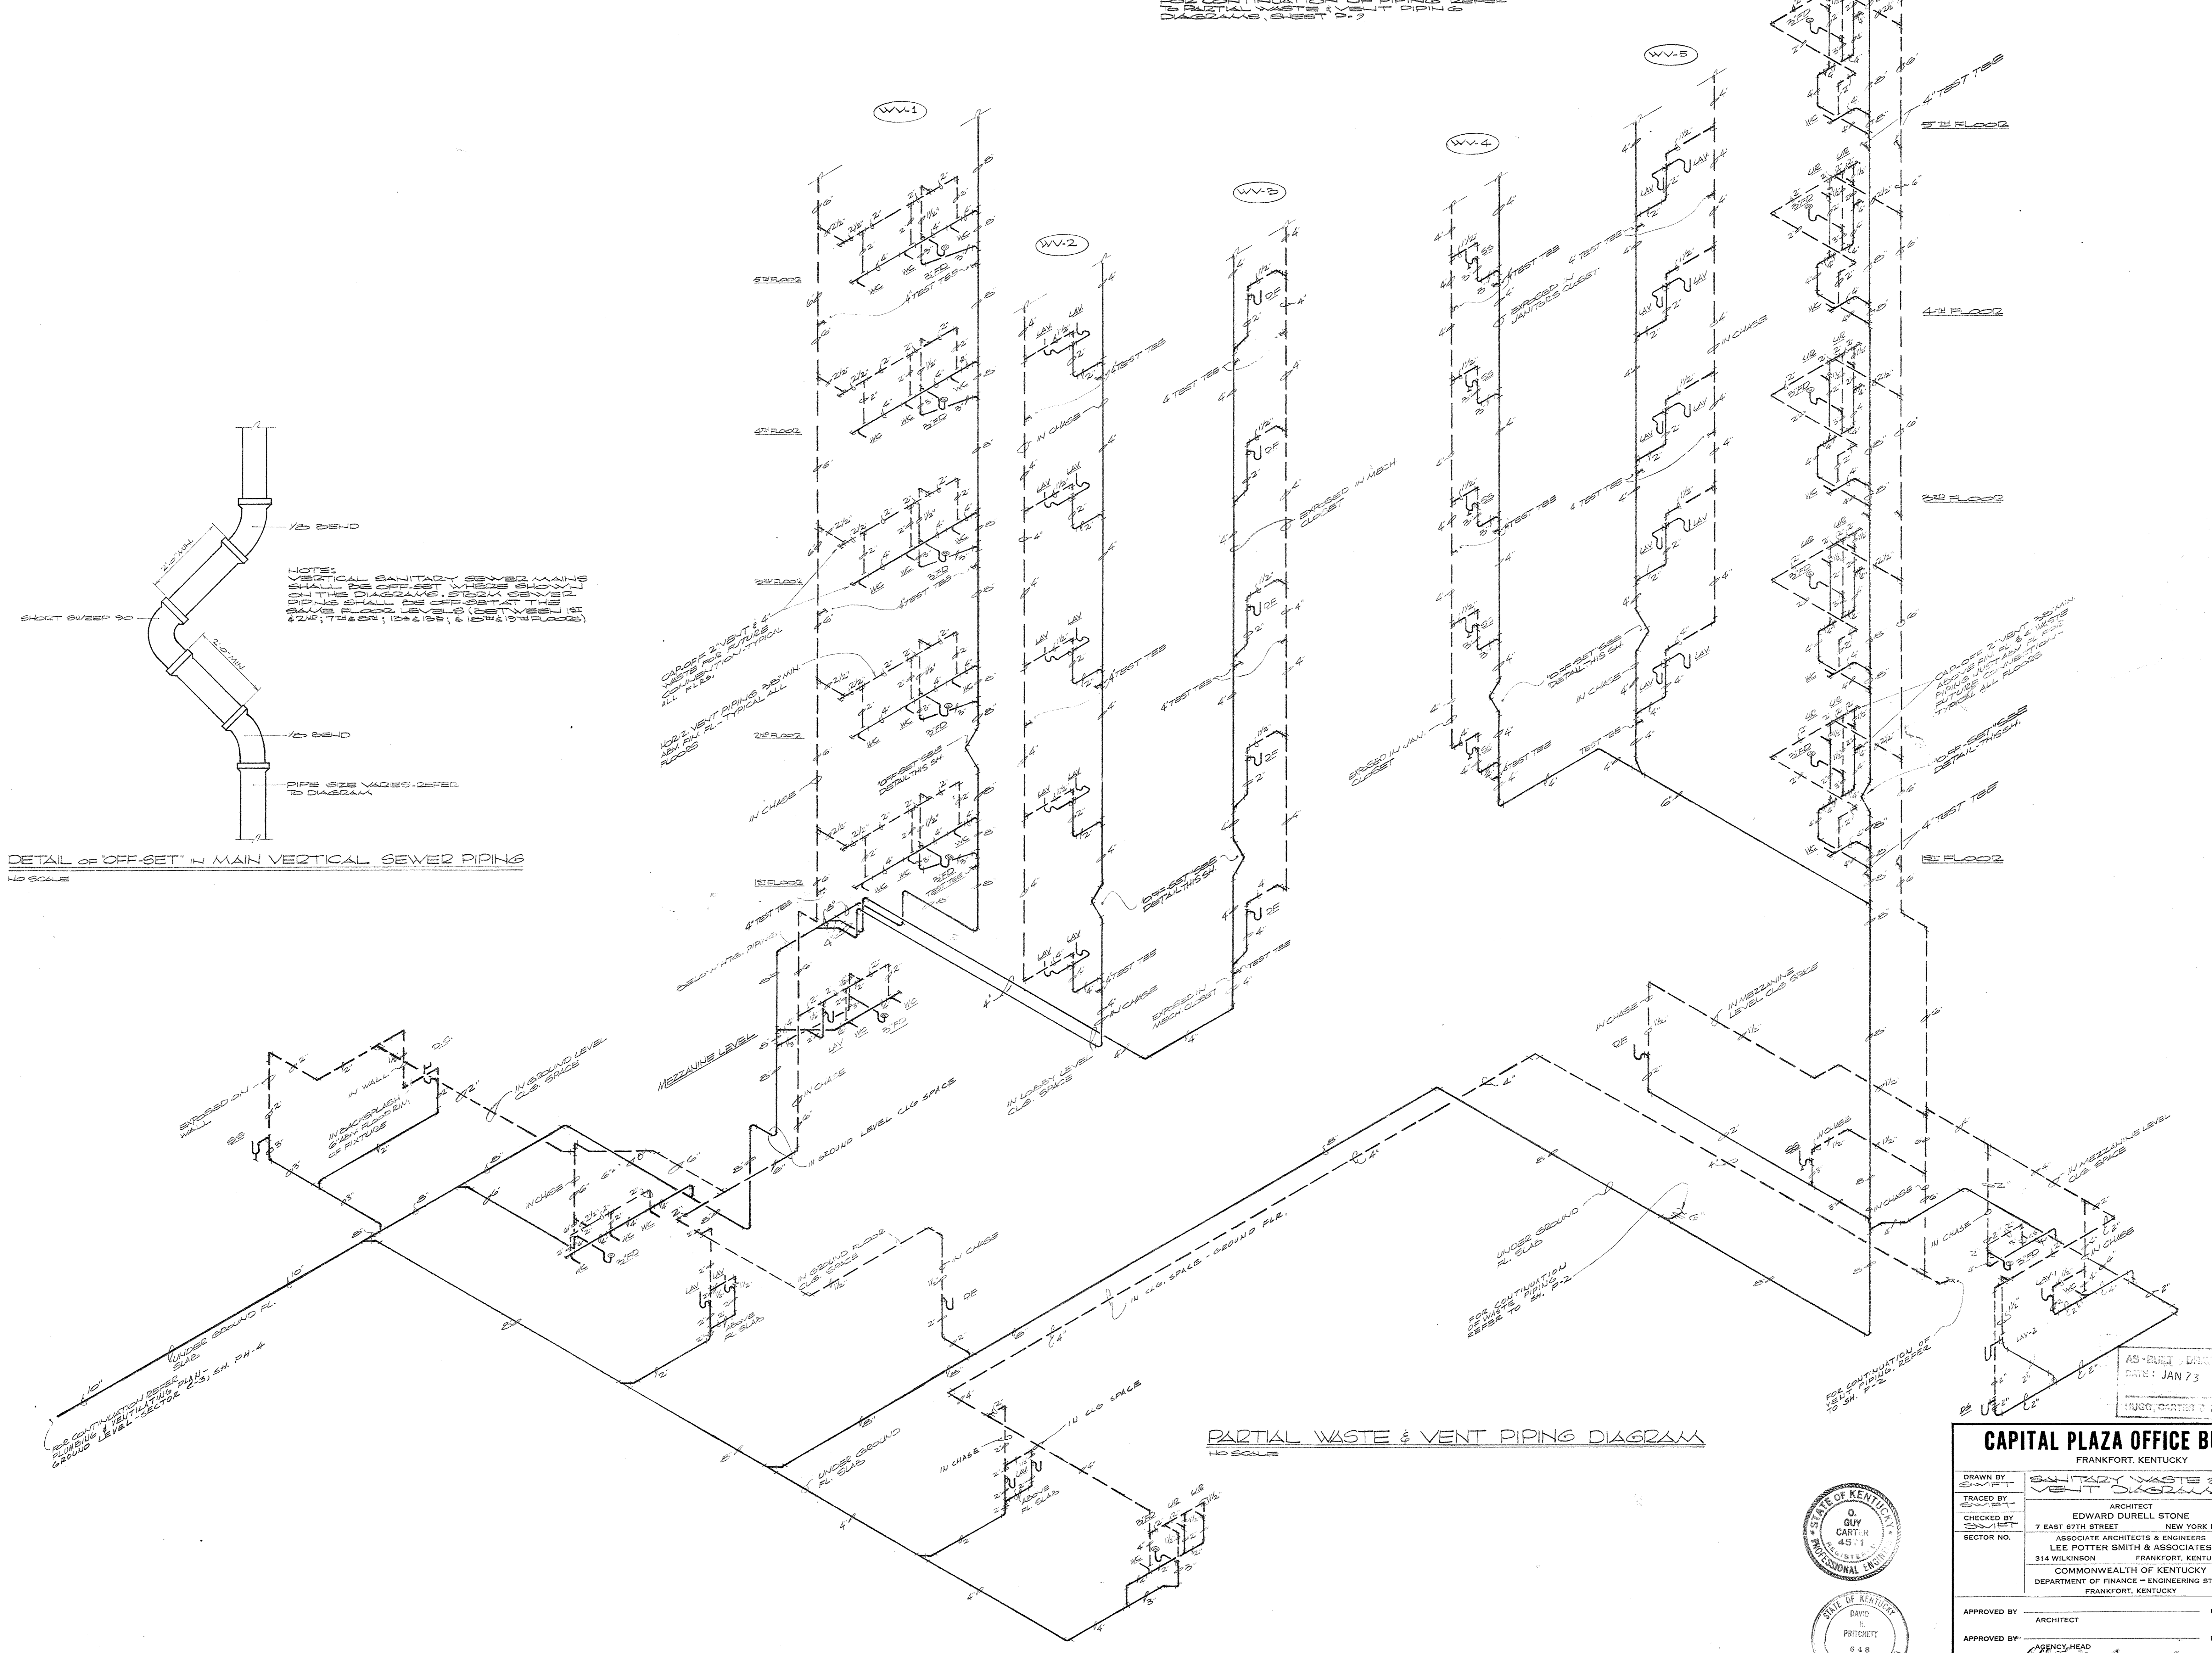


PARTIAL WASTE & VENT PIPING DIAGRAM
 NO SCALE

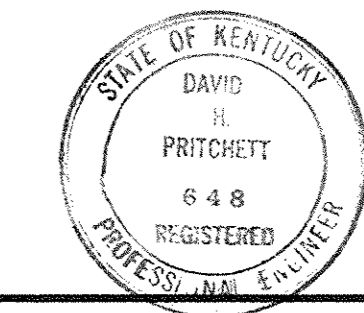

AS-BUILT DRAWING
 DATE: JAN 73
 PROJECT: CAPITAL PLAZA OFFICE BUILDING

CAPITAL PLAZA OFFICE BUILDING FRANKFORT, KENTUCKY		
DRAWN BY SMITH	ARCHITECT	DATE 12-MAY-67
TRACED BY SMITH	EDWARD DURELL STONE 7 EAST 67TH STREET NEW YORK N. Y.	SCALE AS SHOWN
CHECKED BY SMITH	ASSOCIATE ARCHITECTS & ENGINEERS LEE POTTER SMITH & ASSOCIATES 314 WILKINSON FRANKFORT, KENTUCKY	COMM. NO. 500000
SECTOR NO.	COMMONWEALTH OF KENTUCKY DEPARTMENT OF FINANCE - ENGINEERING STAFF FRANKFORT, KENTUCKY	DRAWING NO. P 8 OF 11
APPROVED BY ARCHITECT	DATE	
APPROVED BY AGENCY HEAD	DATE	
APPROVED BY OWNER	DATE	MAY 24 1967


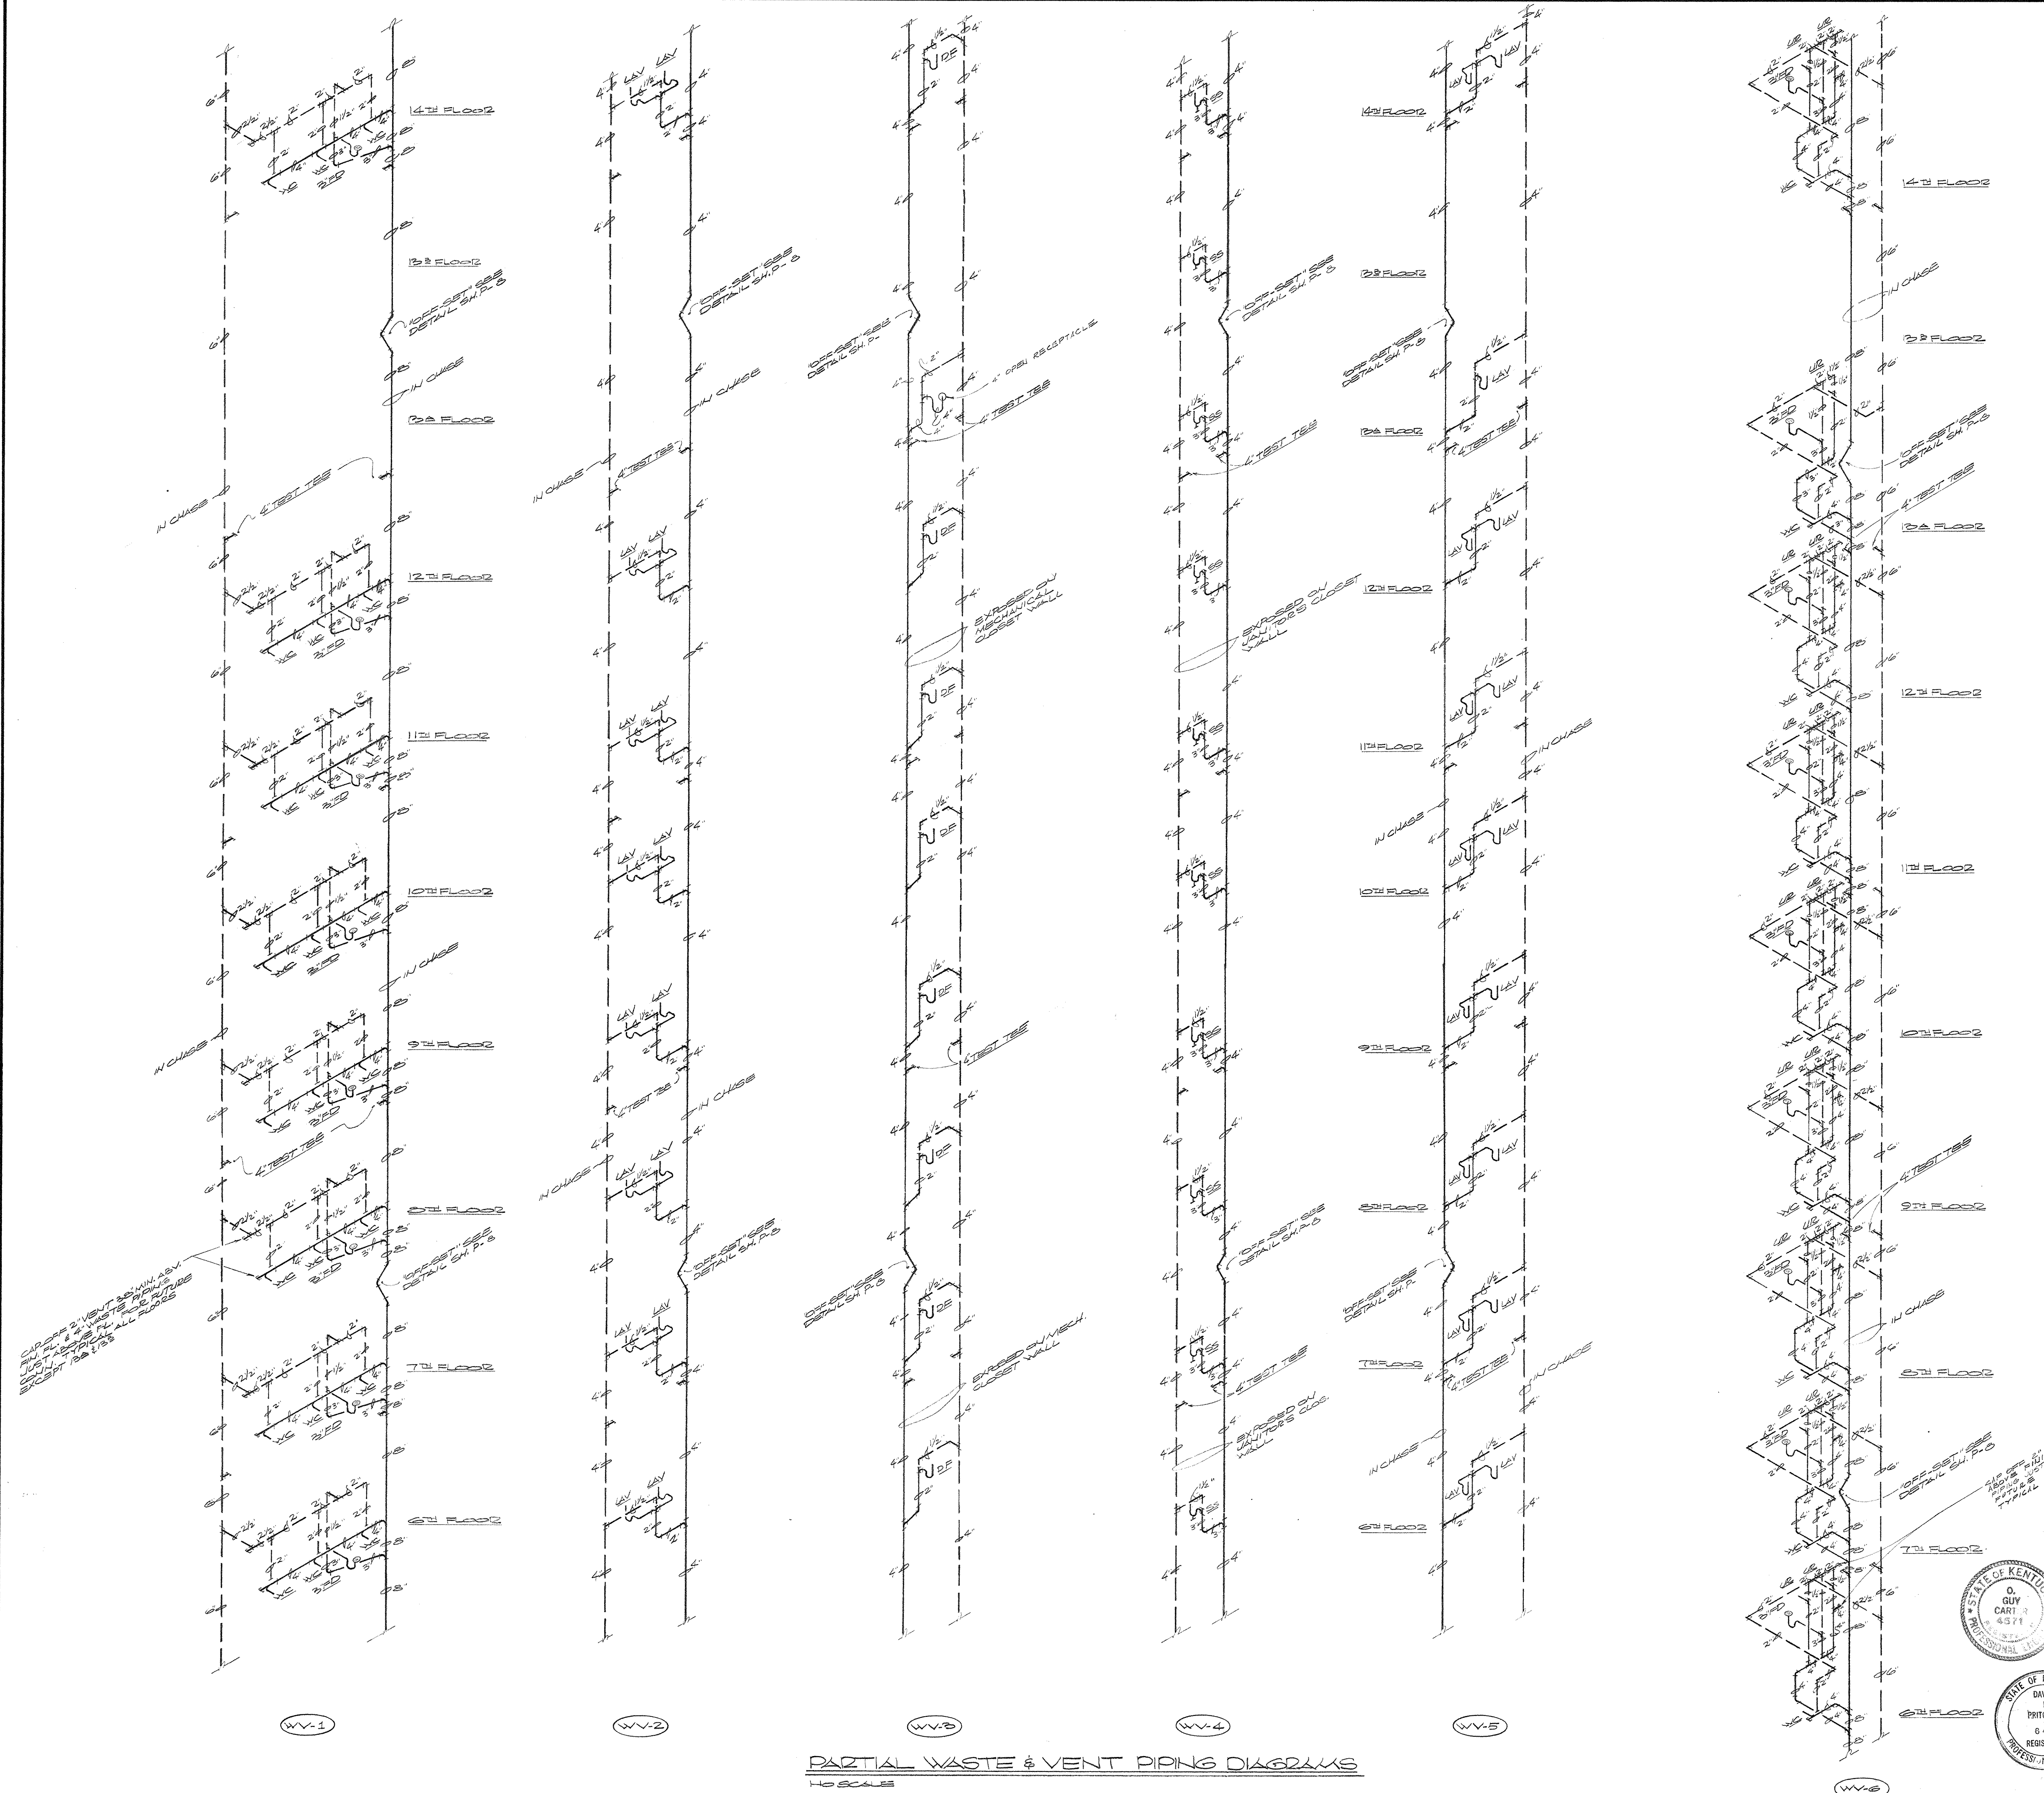


NOTE:
FOR CONTINUATION OF WASTE AND
VENT PIPING - REFER TO
SHEETS P-6 & P-7D


NO. OF RISERS 28
NO. OF VENTS 28
TOTAL LENGTH 13,124 FT.

AS-BUILT DRAWINGS
DATE: JAN 79
HUGG, CORNER & BLACKMAN, INC.

PARTIAL WASTE & VENT PIPING DIAGRAMS
NO SCALE

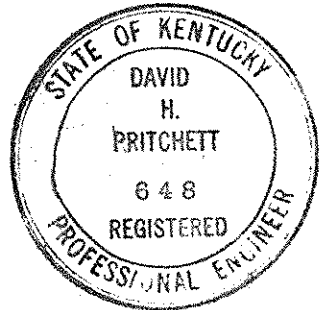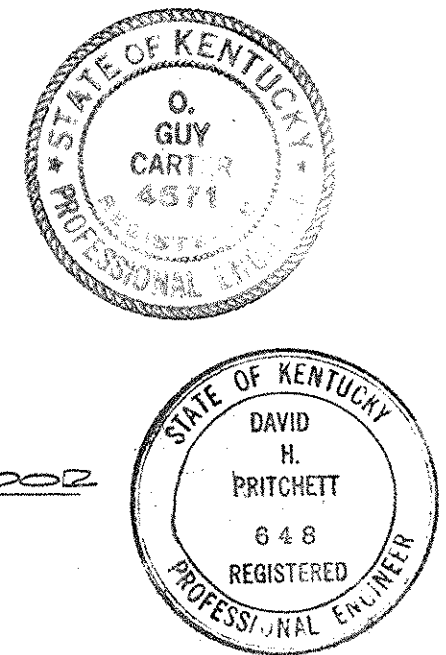


CAPITAL PLAZA OFFICE BUILDING FRANKFORT, KENTUCKY		
DRAWN BY SWIFT	PARTIAL WASTE & VENT PIPING DIAGRAMS GENERAL	DATE 12/27/57
TRACED BY SWIFT	ARCHITECT EDWARD DURELL STONE 7 EAST 67TH STREET NEW YORK, N.Y.	SCALE 1/8" = 1'-0"
CHECKED BY SWIFT	ASSOCIATE ARCHITECTS & ENGINEERS LEE POTTER SMITH & ASSOCIATES 314 WILKINSON FRANKFORT, KENTUCKY	COMM. NO. 2222
SECTOR NO.	COMMONWEALTH OF KENTUCKY DEPARTMENT OF FINANCE - ENGINEERING STAFF FRANKFORT, KENTUCKY	DRAWING NO. P 9 OF 12
APPROVED BY ARCHITECT	DATE	
APPROVED BY AGENCY HEAD	DATE	
APPROVED BY OWNER	DATE	MAY 8 & 1967

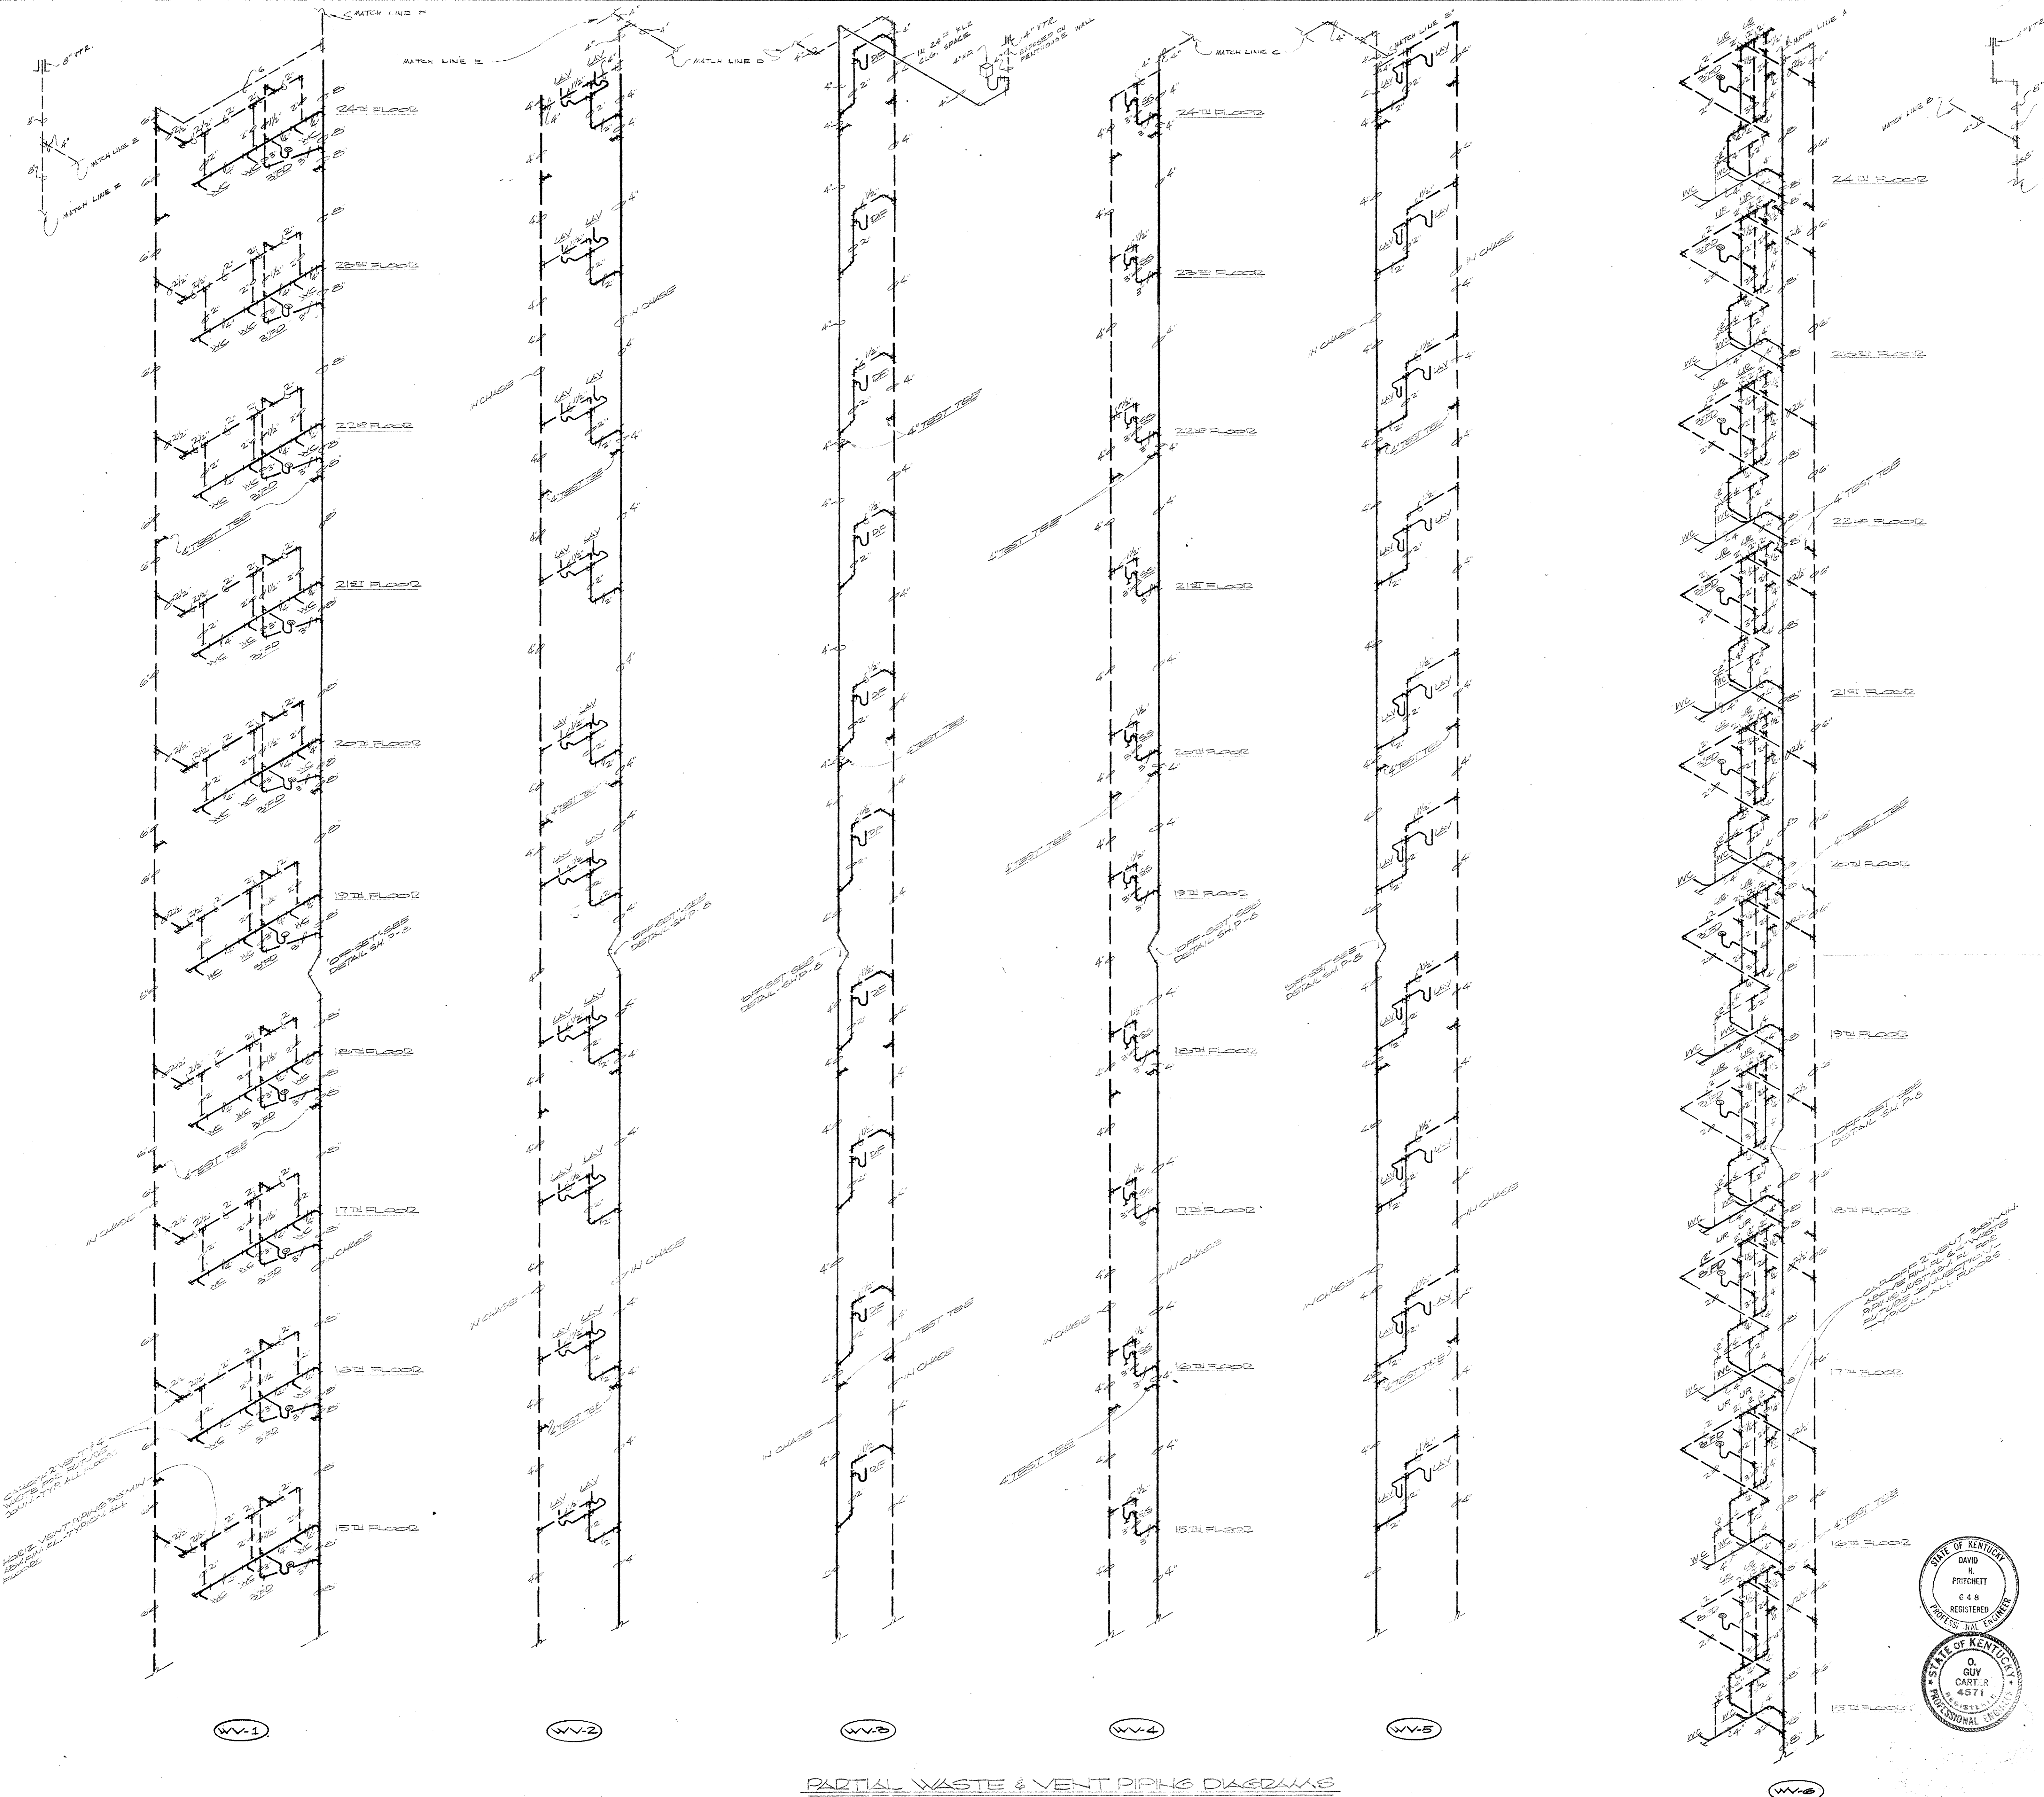

NOTE: FOR CONTINUATION OF PIPING REFER TO SHEET P-9

AS-BUILT DRAWINGS
DATE: JAN 73
HUGG, CARTER & BLANKEN, INC.

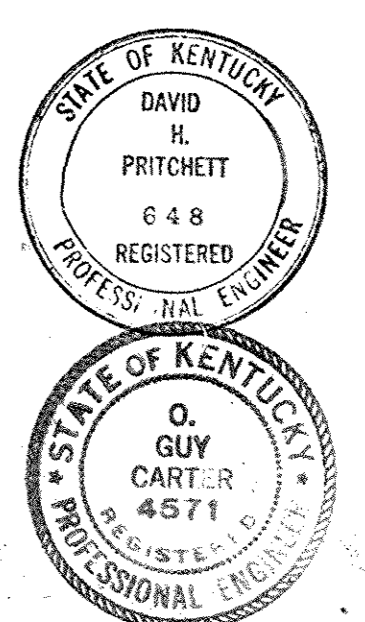


CAPITAL PLAZA OFFICE BUILDING
FRANKFORT, KENTUCKY

DRAWN BY SMIT	PARTIAL WASTE & VENT PIPING DIAGRAMS	DATE 12/28/72
TRACED BY SMIT	EDWARD DURELL STONE ARCHITECT 7 EAST 87TH STREET NEW YORK, N.Y.	SCALE AS SHOWN
CHECKED BY SMIT	LEE POTTER SMITH & ASSOCIATES 314 WILKINSON FRANKFORT, KENTUCKY	COMM. NO. 5000
SECTOR NO.	COMMONWEALTH OF KENTUCKY DEPARTMENT OF FINANCE - ENGINEERING STAFF FRANKFORT, KENTUCKY	DRAWING NO. P 10 OF 14

APPROVED BY	ARCHITECT	DATE
APPROVED BY	AGENCY HEAD	DATE
APPROVED BY	OWNER	DATE


PARTIAL WASTE & VENT PIPING DIAGRAMS
12-28-72

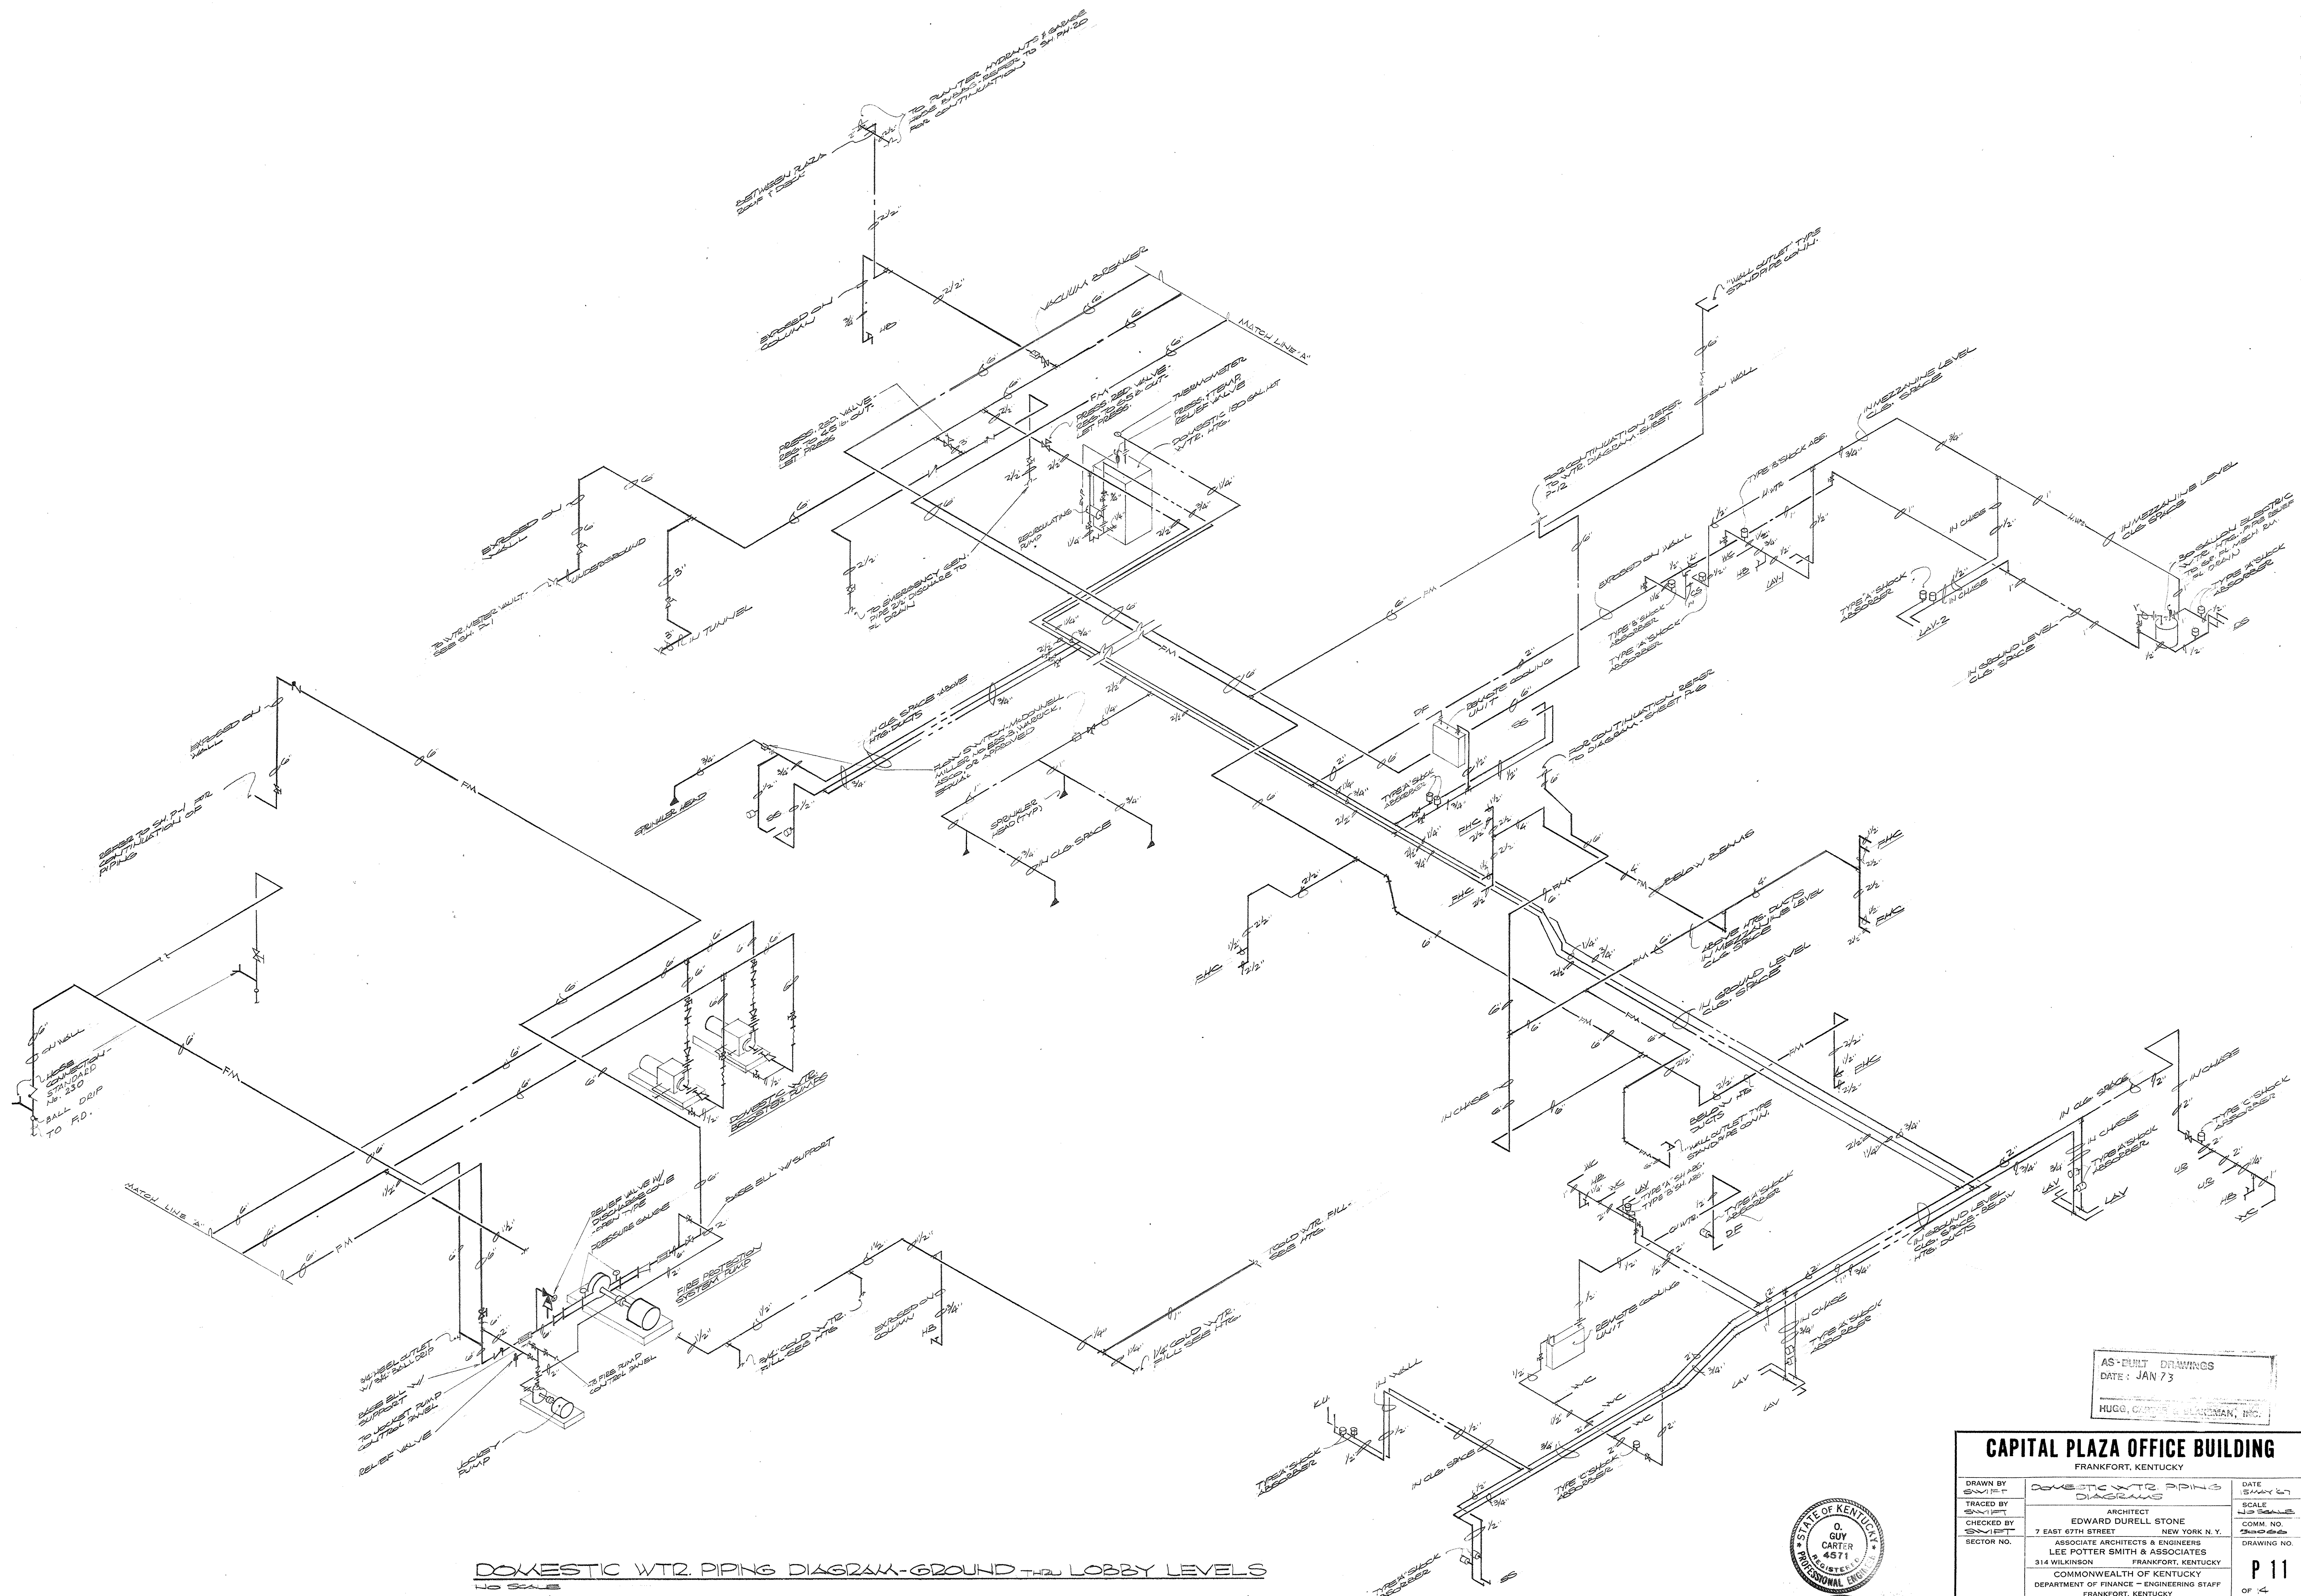


DOMESTIC WTR. PIPING DIAGRAM-GROUND & LOBBY LEVELS
NO SCALE

AS-BUILT DRAWINGS
DATE: JAN 73
HUGG, CARTER & SLAYMAN, INC.

CAPITAL PLAZA OFFICE BUILDING FRANKFORT, KENTUCKY		
DRAWN BY SMITH	DOMESTIC WTR. PIPING DIAGRAM	DATE 12/28/72
CHECKED BY SMITH	ARCHITECT	SCALE 1/4" = 1'-0"
SECTOR NO.	EDWARD DURELL STONE 7 EAST 67TH STREET NEW YORK, N.Y.	COMM. NO. 2000
	ASSOCIATE ARCHITECTS & ENGINEERS	DRAWING NO. P 11
	LEE POTTER SMITH & ASSOCIATES 314 WILKINSON FRANKFORT, KENTUCKY	OF 14
	COMMONWEALTH OF KENTUCKY DEPARTMENT OF FINANCE - ENGINEERING STAFF FRANKFORT, KENTUCKY	
APPROVED BY ARCHITECT	DATE	
APPROVED BY AGENCY HEAD	DATE	
APPROVED BY OWNER	DATE	MAY 24 1967

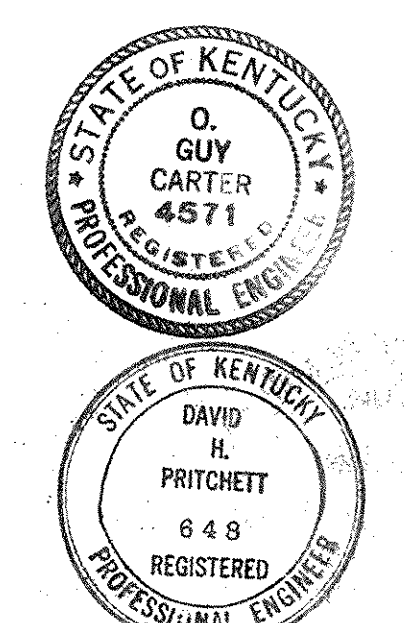


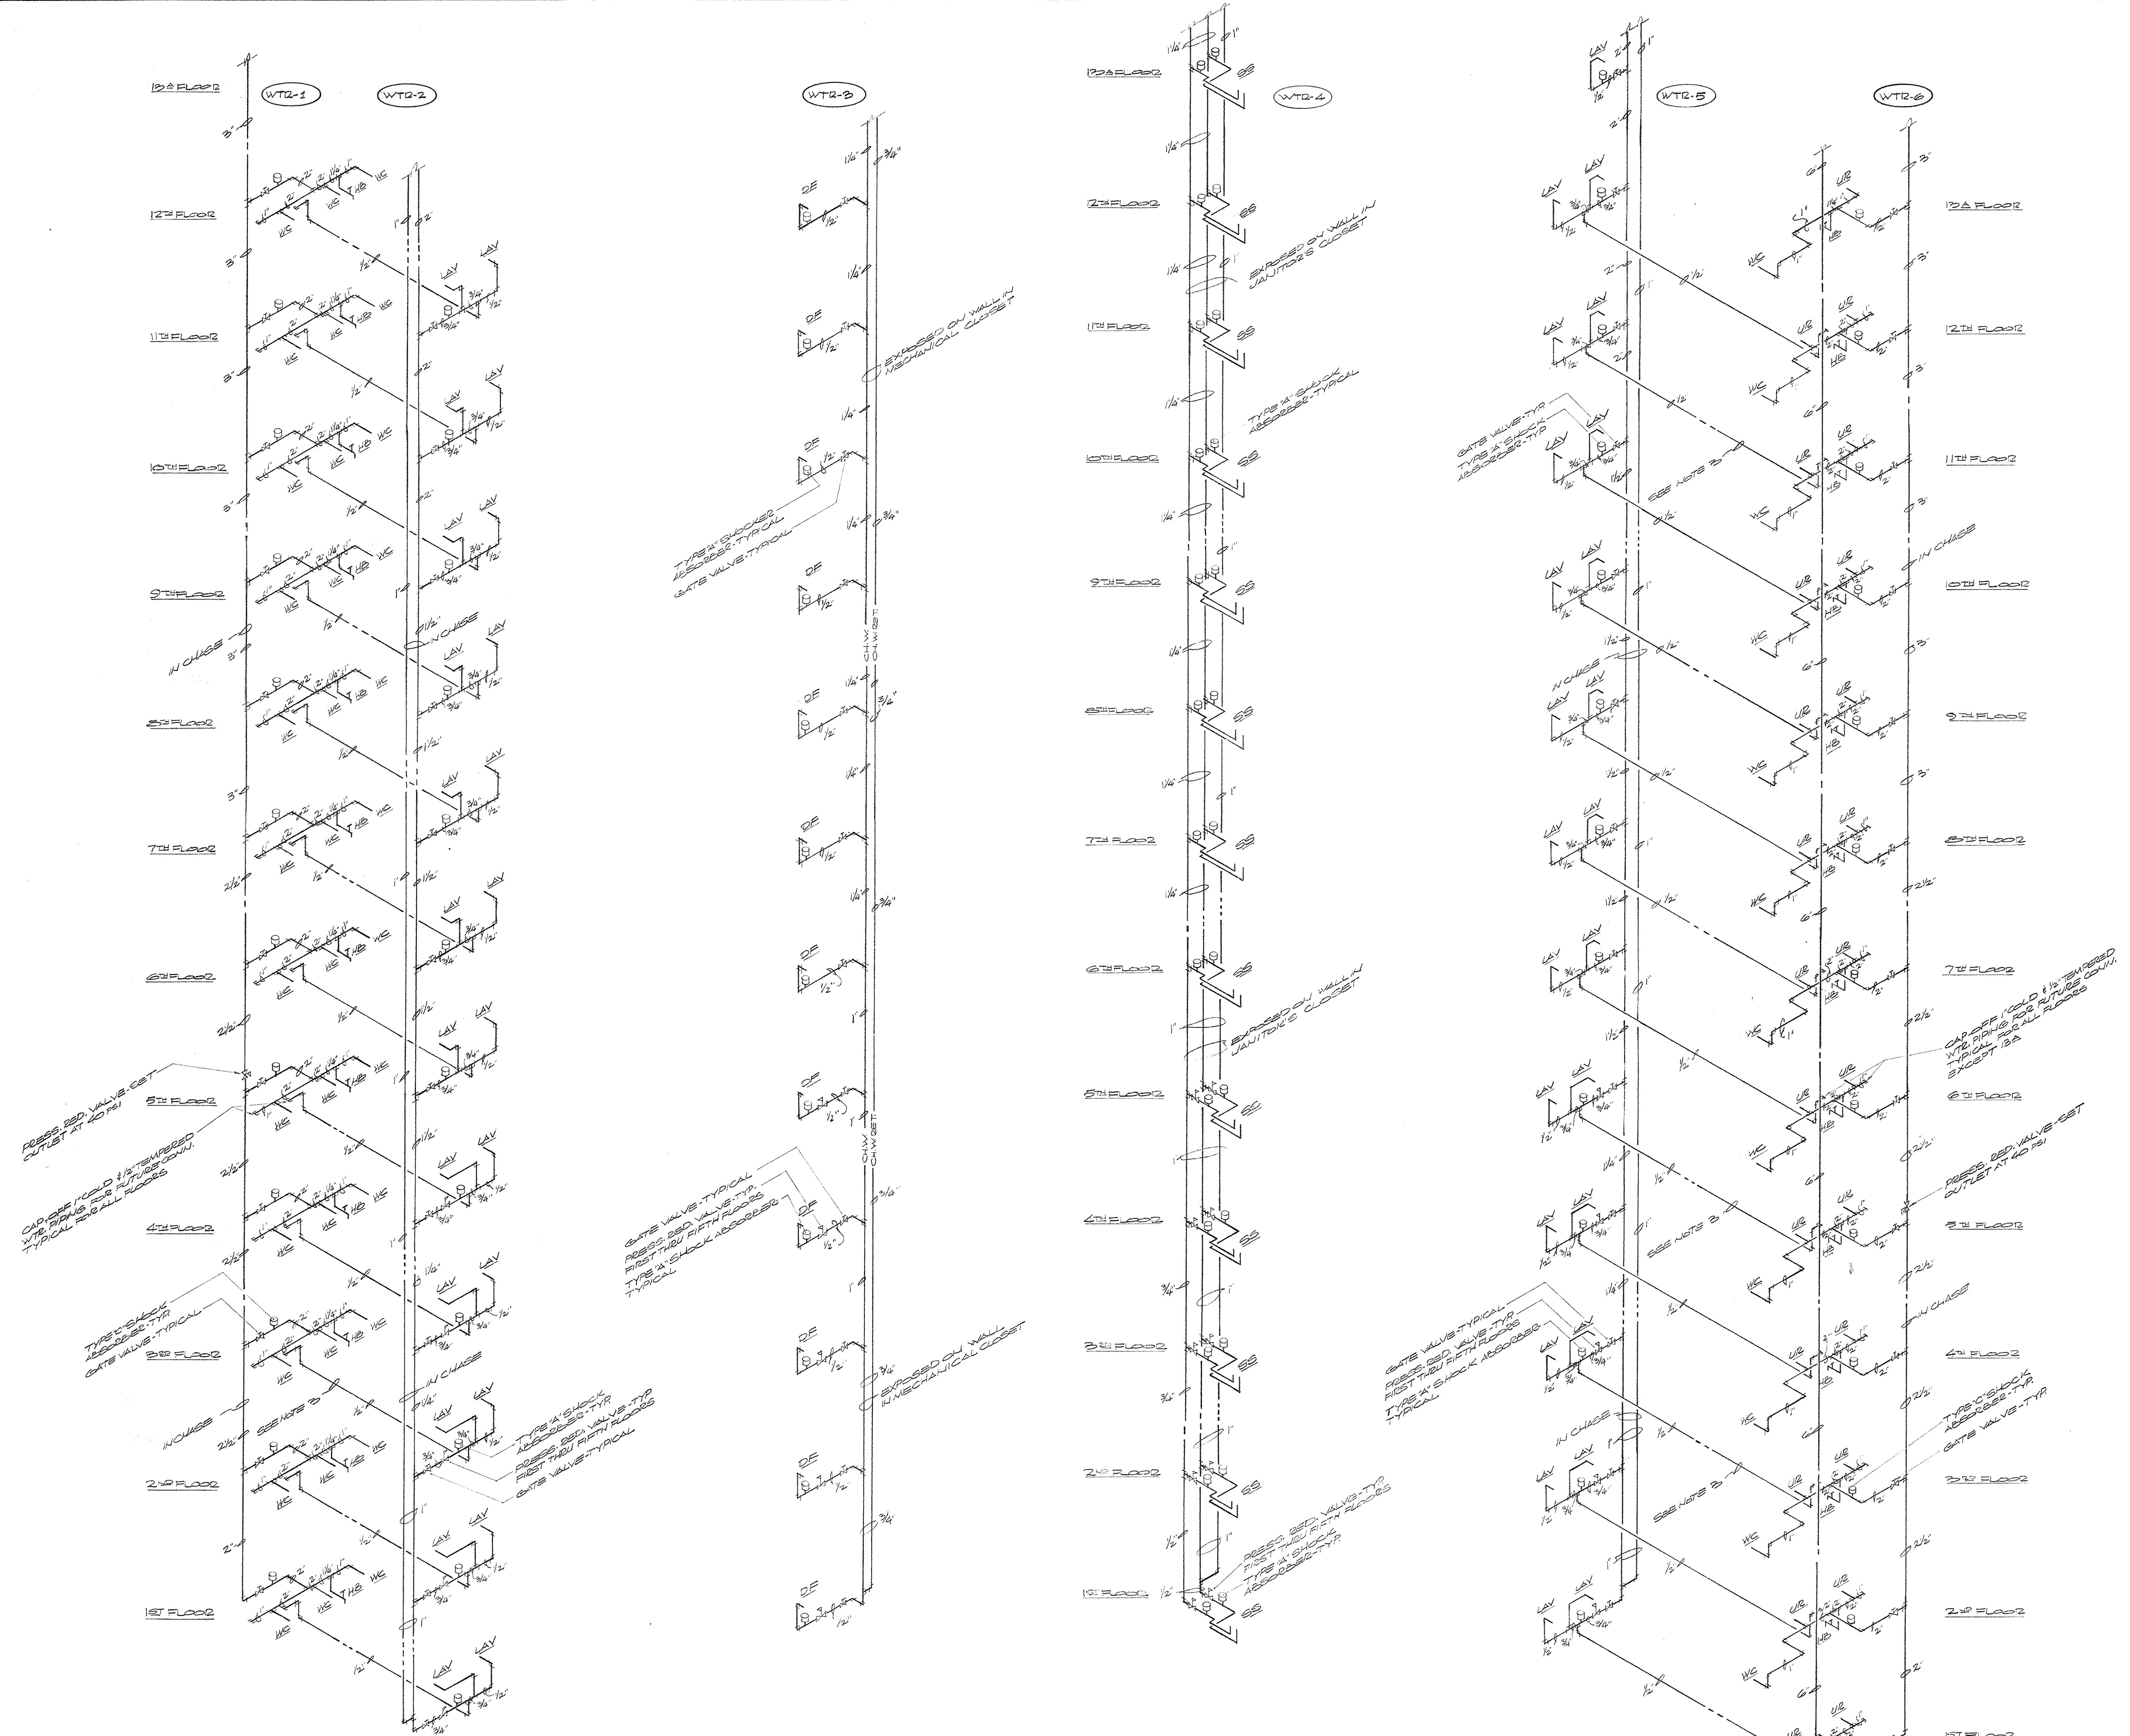

PARTIAL DOMESTIC WTR PIPING DIAGRAM
NO SCALE

- NOTE:
1. PRESS. RED. VALVES SHALL BE INSTALLED ON TEMPERED WTR BRANCHES SERVING FIXTURES ON THE FIFTH THROUGH EIGHTH FLOORS & ON WTR MAINS OUTLET FROM PRESS. CHAMBER SET AT 50 PSI UNLESS OTHERWISE NOTED.
 2. FOR CONTINUATION OF PIPE REFER TO CAPITAL DOMESTIC WTR PIPING DIAGRAM SHEET P-1.
 3. ALL TEMPERED WTR BRANCHES EXTENDING ABOVE TO LET ROOFS & BEING CAPPED OFF FOR FUTURE CONSTRUCTION SHALL BE INSTALLED IN THE CEILING SPACE OF THE TO LET ROOM BELOW.
 4. FOR INDIVIDUAL BRANCH SIZES SERVING FIXTURES REFER TO FIXTURE SCHEDULES THIS SHEET.

AS-BUILT DRAWINGS
DATE: JAN 73
L. S. CARTER & BLAKEMAN, INC.

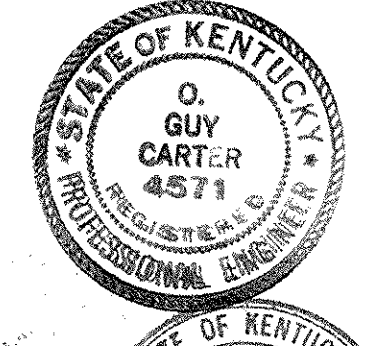

CAPITAL PLAZA OFFICE BUILDING FRANKFORT, KENTUCKY		
DRAWN BY SWIFT	DOMESTIC WATER PIPING DIAGRAM	DATE 15 MAY 67
TRACED BY SWIFT	ARCHITECT EDWARD DURELL STONE	SCALE 1/8" = 1'-0"
CHECKED BY SWIFT	7 EAST 6TH STREET NEW YORK N. Y.	COMM. NO. 20000
SECTOR NO.	ASSOCIATE ARCHITECTS & ENGINEERS LEE POTTER SMITH & ASSOCIATES 314 WILKINSON FRANKFORT, KENTUCKY	DRAWING NO. P 12 OF 14
APPROVED BY	ARCHITECT	DATE
APPROVED BY	AGENCY HEAD L. S. CARTER	DATE MAY 24 1967
APPROVED BY	OWNER	DATE

FIXTURE SCHEDULE


FIXTURE	ABBREV	COLD WTR. CONN.	TEMPERED WTR. CONN. (OPF)	CHILLED WTR. CONN.	T2AP SIZE	REMARKS
WATER CLOSET	WC	1"			4"	WALL HUNG
URINAL	UR	1"			INTERM.	WALL HUNG
LAVATORY	LAV	1/2"	3/8"		1/2"	WALL HUNG
SERVICE SINK	SS	1/2"	1/2"		2"	SIZE 24" x 20"
DRINKING FOUNTAIN	DF			3/8"	1/2"	WALL MTD
QUICK SINK	QS	1/2" x 3/8"	3/8" HOT WATER		4"	LOCATED IN ZEM. M. 14
KITCHEN SINK	KU	1/2"	1/2"		1 1/2"	FLUSH ACCESS & SIGHT ONLY
SINK	SO	3/4"				
HOT WATER	HW	1/2"				
FLOOR DRAIN	FD				1/2"	
HOT WATER	HW		HOT WATER		4"	
DOUBLE SINK	DS	1/2"	1/2"		1 1/2"	COUNTER TOP INSTALL - DETAILED M. 19
LAVATORY-1	LAV-1	3/8"	3/8"		1/2"	LOCATED IN ZEM. M. 14
LAVATORY-2	LAV-2	3/8"	3/8"		1/2"	COUNTER TOP INSTALL - DETAILED M. 18

PIPING & SYMBOL LEGEND

---	SANITARY SEWER PIPING
---	VENT PIPING
---	STEAM WTR. PIPING
---	RELEASE VALVE PIPING
---	COLD WTR. PIPING
---	TEMPERED WTR. PIPING (OPF)
---	TEMPERED WTR. RETURN PIPING
---	CHILLED WTR. PIPING
---	CHILLED WTR. RETURN PIPING
---	FIRE PROTECTION PIPING
---	HOT WTR. PIPING (140°F) (LOCATED AT MEZZANINE LEVEL ONLY)
⊗	GATE VALVE
⊗	PRESSURE REDUCING VALVE
⊗	GLOBE VALVE
⊗	CHECK VALVE
⊗	UNION
⊗	ESSENTIAL REDUCER
⊗	THERMOPUR BALANCED INSULATING UNIONS
⊗	THERMOMETER
⊗	SHOCK ABSORBER


SCHEDULE OF SHOCK ABSORBERS

TYPE	FIXTURE UNIT CAPACITY	COLLECTION SIZE
A	1-11	3/4"
B	2-22	1"
C	30-60	1 1/2"

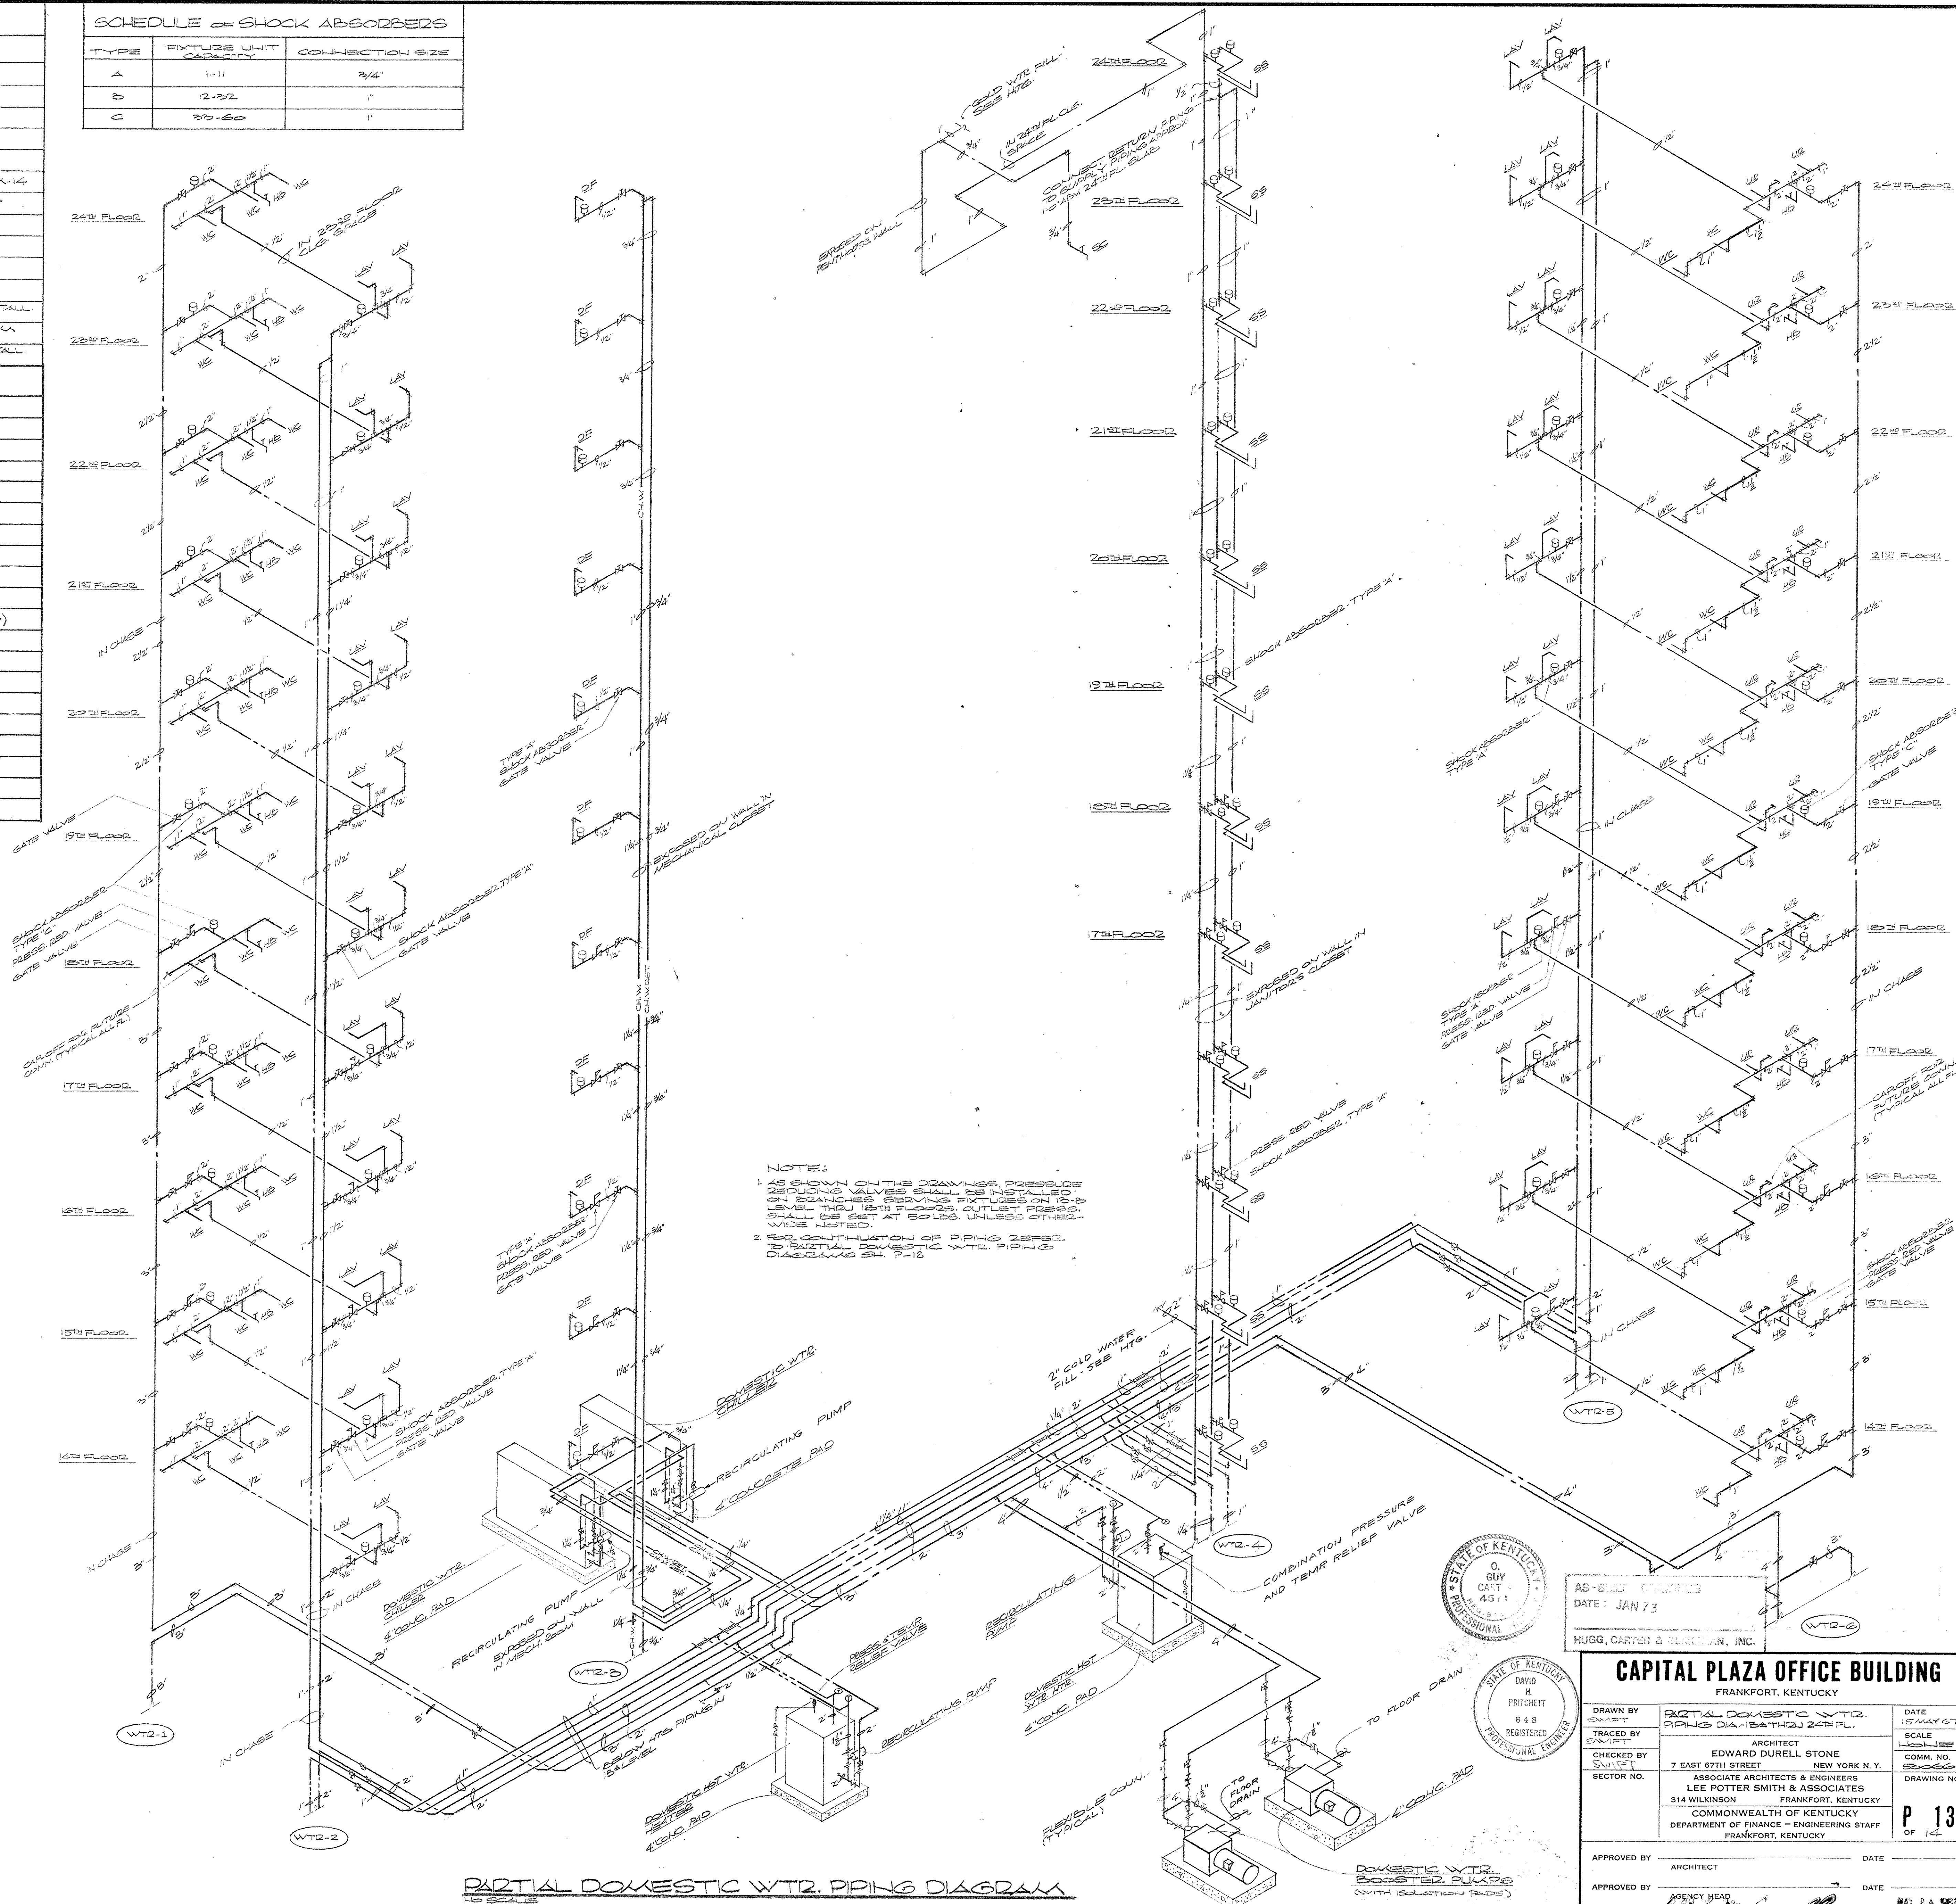

PARTIAL DOMESTIC WTR. PIPING DIAGRAM
NO SCALE

NOTE:
1. AS SHOWN ON THE DRAWINGS, PRESSURE REDUCING VALVES SHALL BE INSTALLED ON BRANCHES SERVING FIXTURES ON THE LEVEL THAT THEY ARE SET, UNLESS OTHERWISE NOTED.
2. THE CONTINUATION OF PIPE SHALL BE SHOWN BY THE DOTTED LINE.

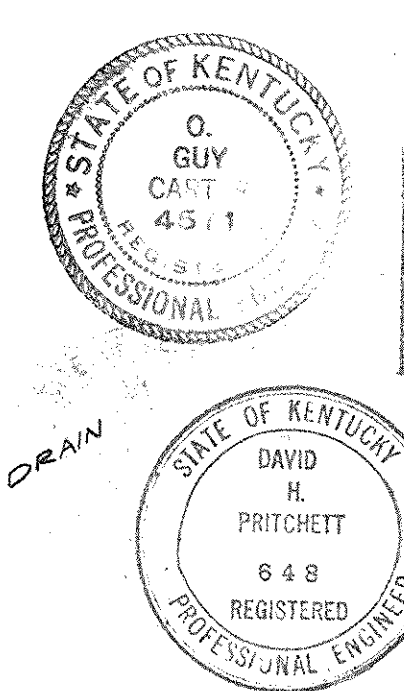


AS-BUILT DRAWING
DATE: JAN 73
HUGG, CARTER & BERKMAN, INC.


CAPITAL PLAZA OFFICE BUILDING
FRANKFORT, KENTUCKY

DRAWN BY	DAVID W. PRITCHETT	DATE	12 MAY 67
CHECKED BY	EDWARD DURELL STONE	SCALE	AS SHOWN
SECTOR NO.	7 EAST 67TH STREET FRANKFORT, KENTUCKY	COMM. NO.	6000
	ASSOCIATE ARCHITECTS & ENGINEERS LEE POTTER SMITH & ASSOCIATES 314 WILKINSON FRANKFORT, KENTUCKY	DRAWING NO.	P 13 OF 14


APPROVED BY: ARCHITECT DATE: _____
APPROVED BY: AGENCY HEAD DATE: _____
APPROVED BY: OWNER DATE: _____

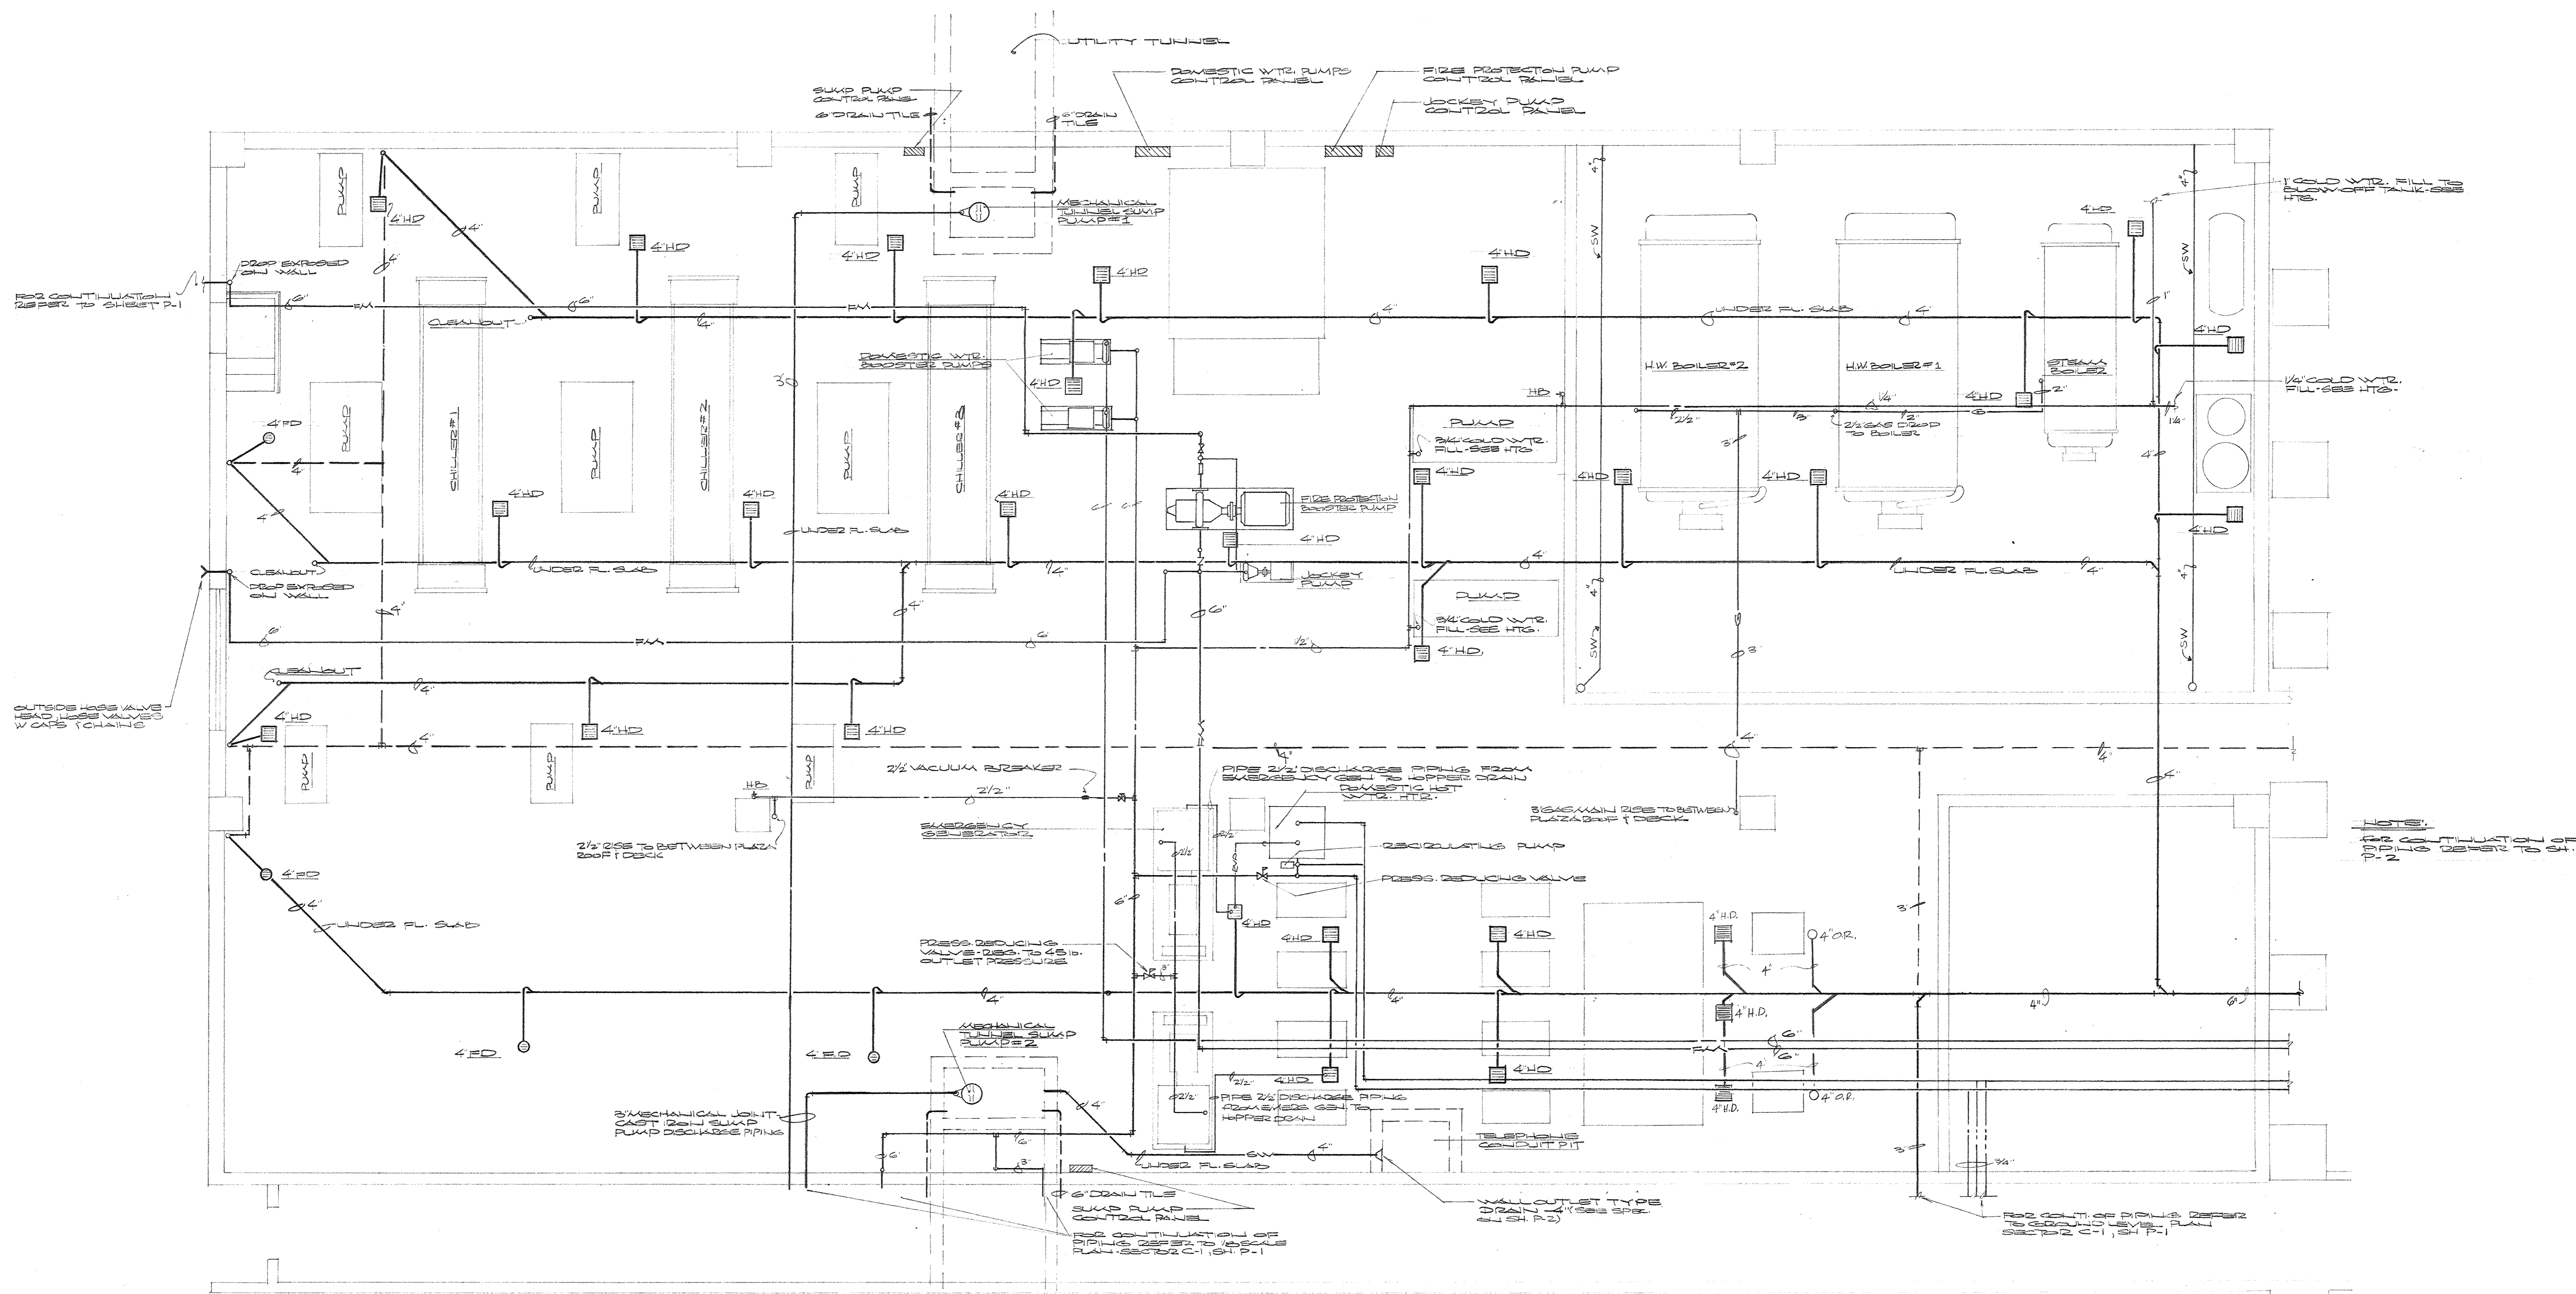

PLUMBING PLAN-MECHANICAL ROOM-SECTOR C-1
SCALE: 1/4" = 1'-0"


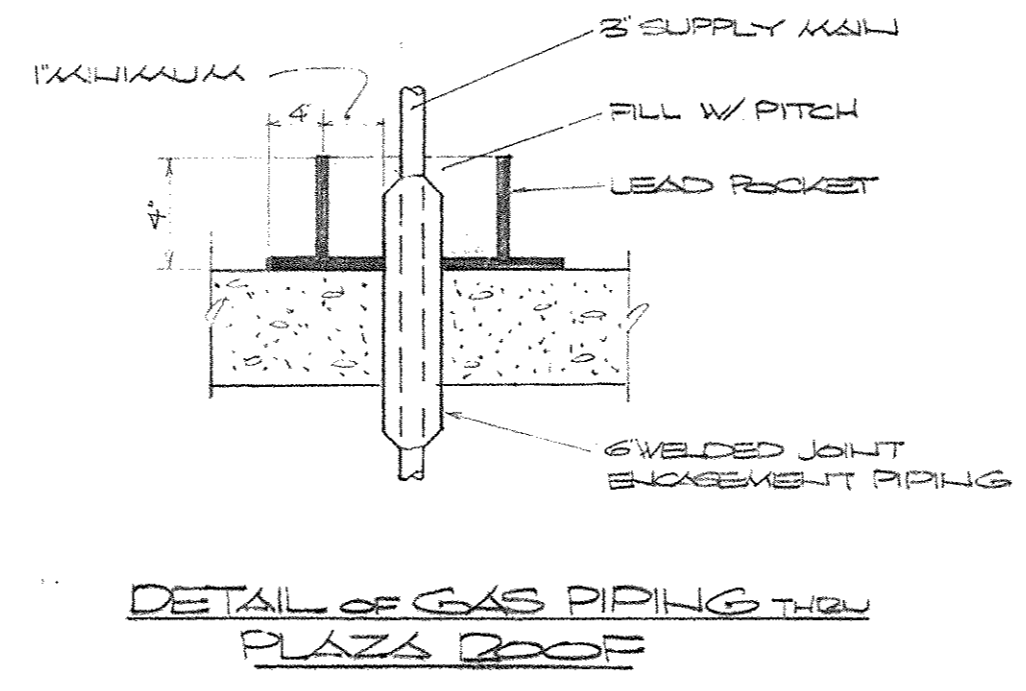


DETAIL OF GAS PIPING TO PLAZA ROOF
NO SCALE

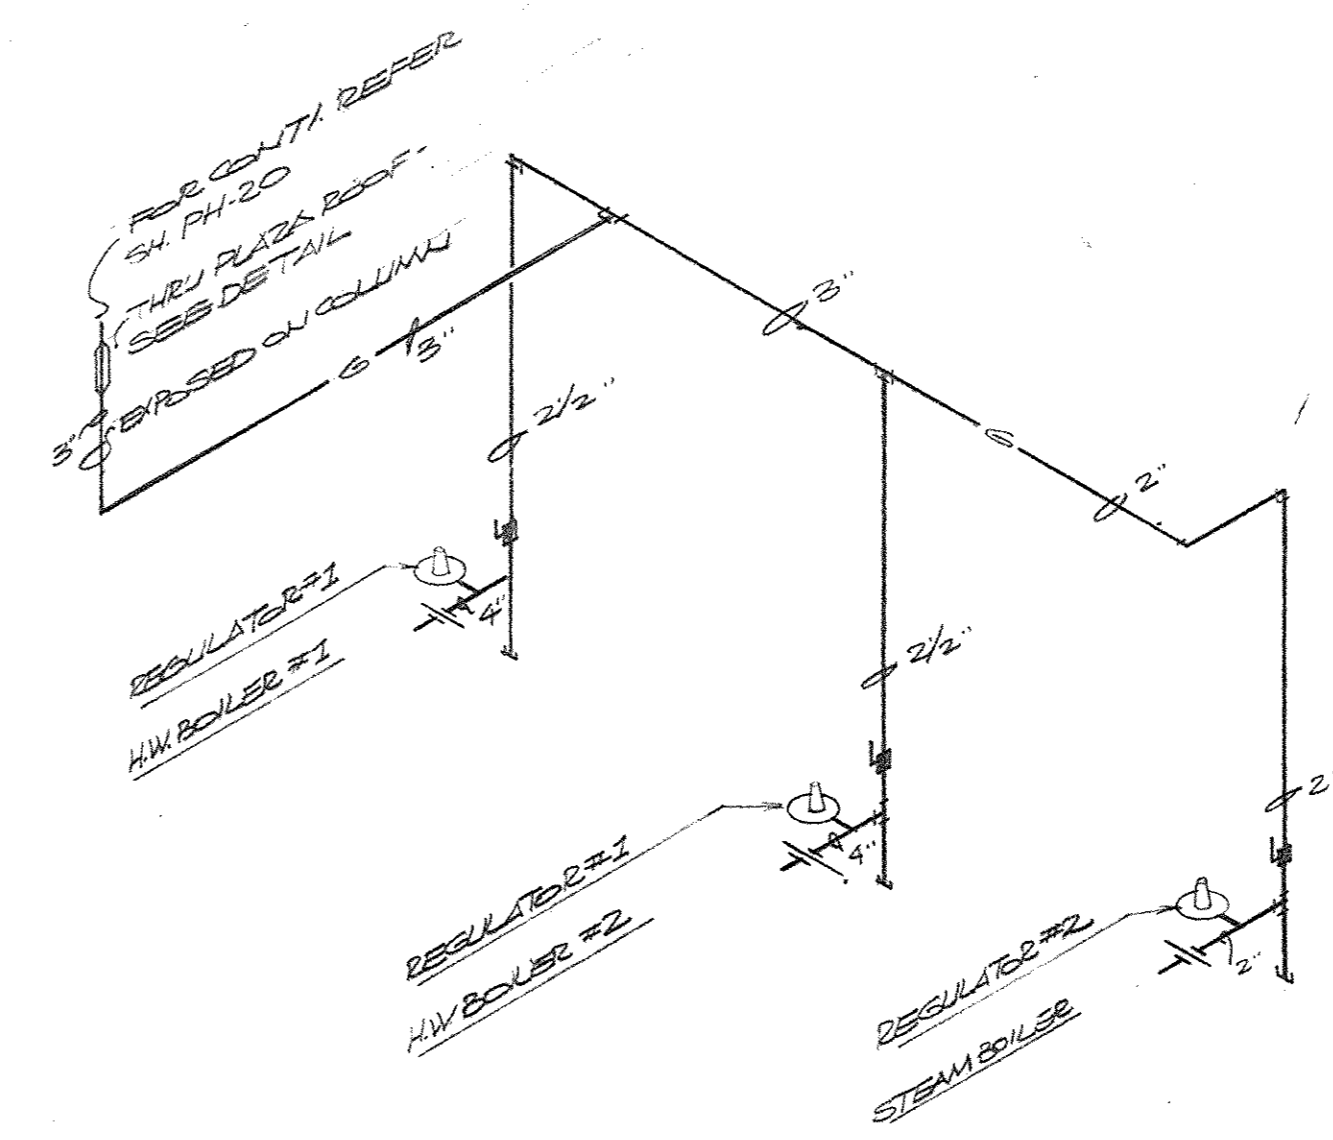

GAS PIPING DIAGRAM
NO SCALE

- GENERAL NOTES**
- REGULATOR #1 - FISHED, 2" TYPE 66 GAS REG WITH 2" BODY (12002) REGULATOR SHALL HAVE A CAPACITY OF 14,000 FT³/HR WITH A 5 LB INLET PRESSURE & 1/2" WC. OUTLET PRESSURE. REGULATOR SHALL BE COMPLETE WITH 2" ZEPH GAS VALVE & 2" DIAPHRAGM ASSEMBLY.
 - REGULATOR #2 - FISHED, 1/2" 6202 GAS REG WITH 1/2" BODY (13400) REGULATOR SHALL HAVE A CAPACITY OF 5000 FT³/HR WITH A 5 LB INLET PRESSURE & 1" WC. OUTLET PRESSURE. REGULATOR SHALL BE THE INTERNAL GLOBE TYPE.

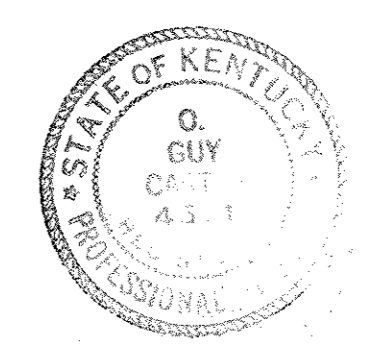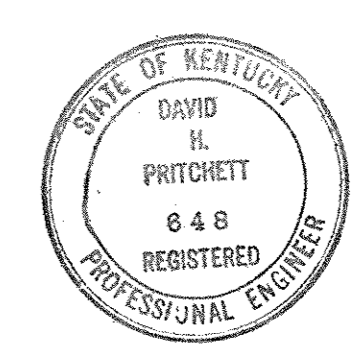

CAPITAL PLAZA OFFICE BUILDING FRANKFORT, KENTUCKY		
DRAWN BY SM/PT	MECHANICAL ROOM PLAN	DATE 12/21/67
TRACED BY SM/PT	ARCHITECT	SCALE AS SHOWN
CHECKED BY SM/PT	EDWARD DURELL STONE 7 EAST 67TH STREET NEW YORK, N. Y.	COMM. NO. 60000
SECTOR NO.	ASSOCIATE ARCHITECTS & ENGINEERS LEE POTTER SMITH & ASSOCIATES 314 WILKINSON FRANKFORT, KENTUCKY COMMONWEALTH OF KENTUCKY DEPARTMENT OF FINANCE - ENGINEERING STAFF FRANKFORT, KENTUCKY	DRAWING NO. P 14 OF 14
APPROVED BY ARCHITECT	DATE	
APPROVED BY AGENCY HEAD <i>[Signature]</i>	DATE MAY 24 1968	
APPROVED BY OWNER	DATE	