


REFLECTED CEILING PLAN
 SCALE: 1/4" = 1'-0"

AREA 1A


ID-E-103
 sheet 1/4" = 1'-0"
 scale
 date 2-20-83

project
 CAPITAL PLAZA
 FRANKFORT KENTUCKY HOTEL
 PLAZA'S REFLECTED CEILING PLAN

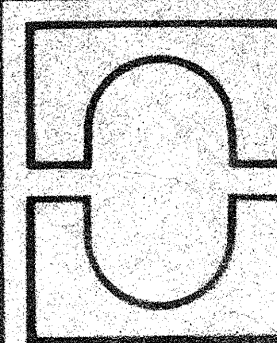

MORRIS-POWELL ASSOCIATES, INC.
 interior designers consultants
 4500 biscayne boulevard suite 20
 miami, florida 33137
 (305) 576-6551

project no.
 revisions
 (1) 1-1-83

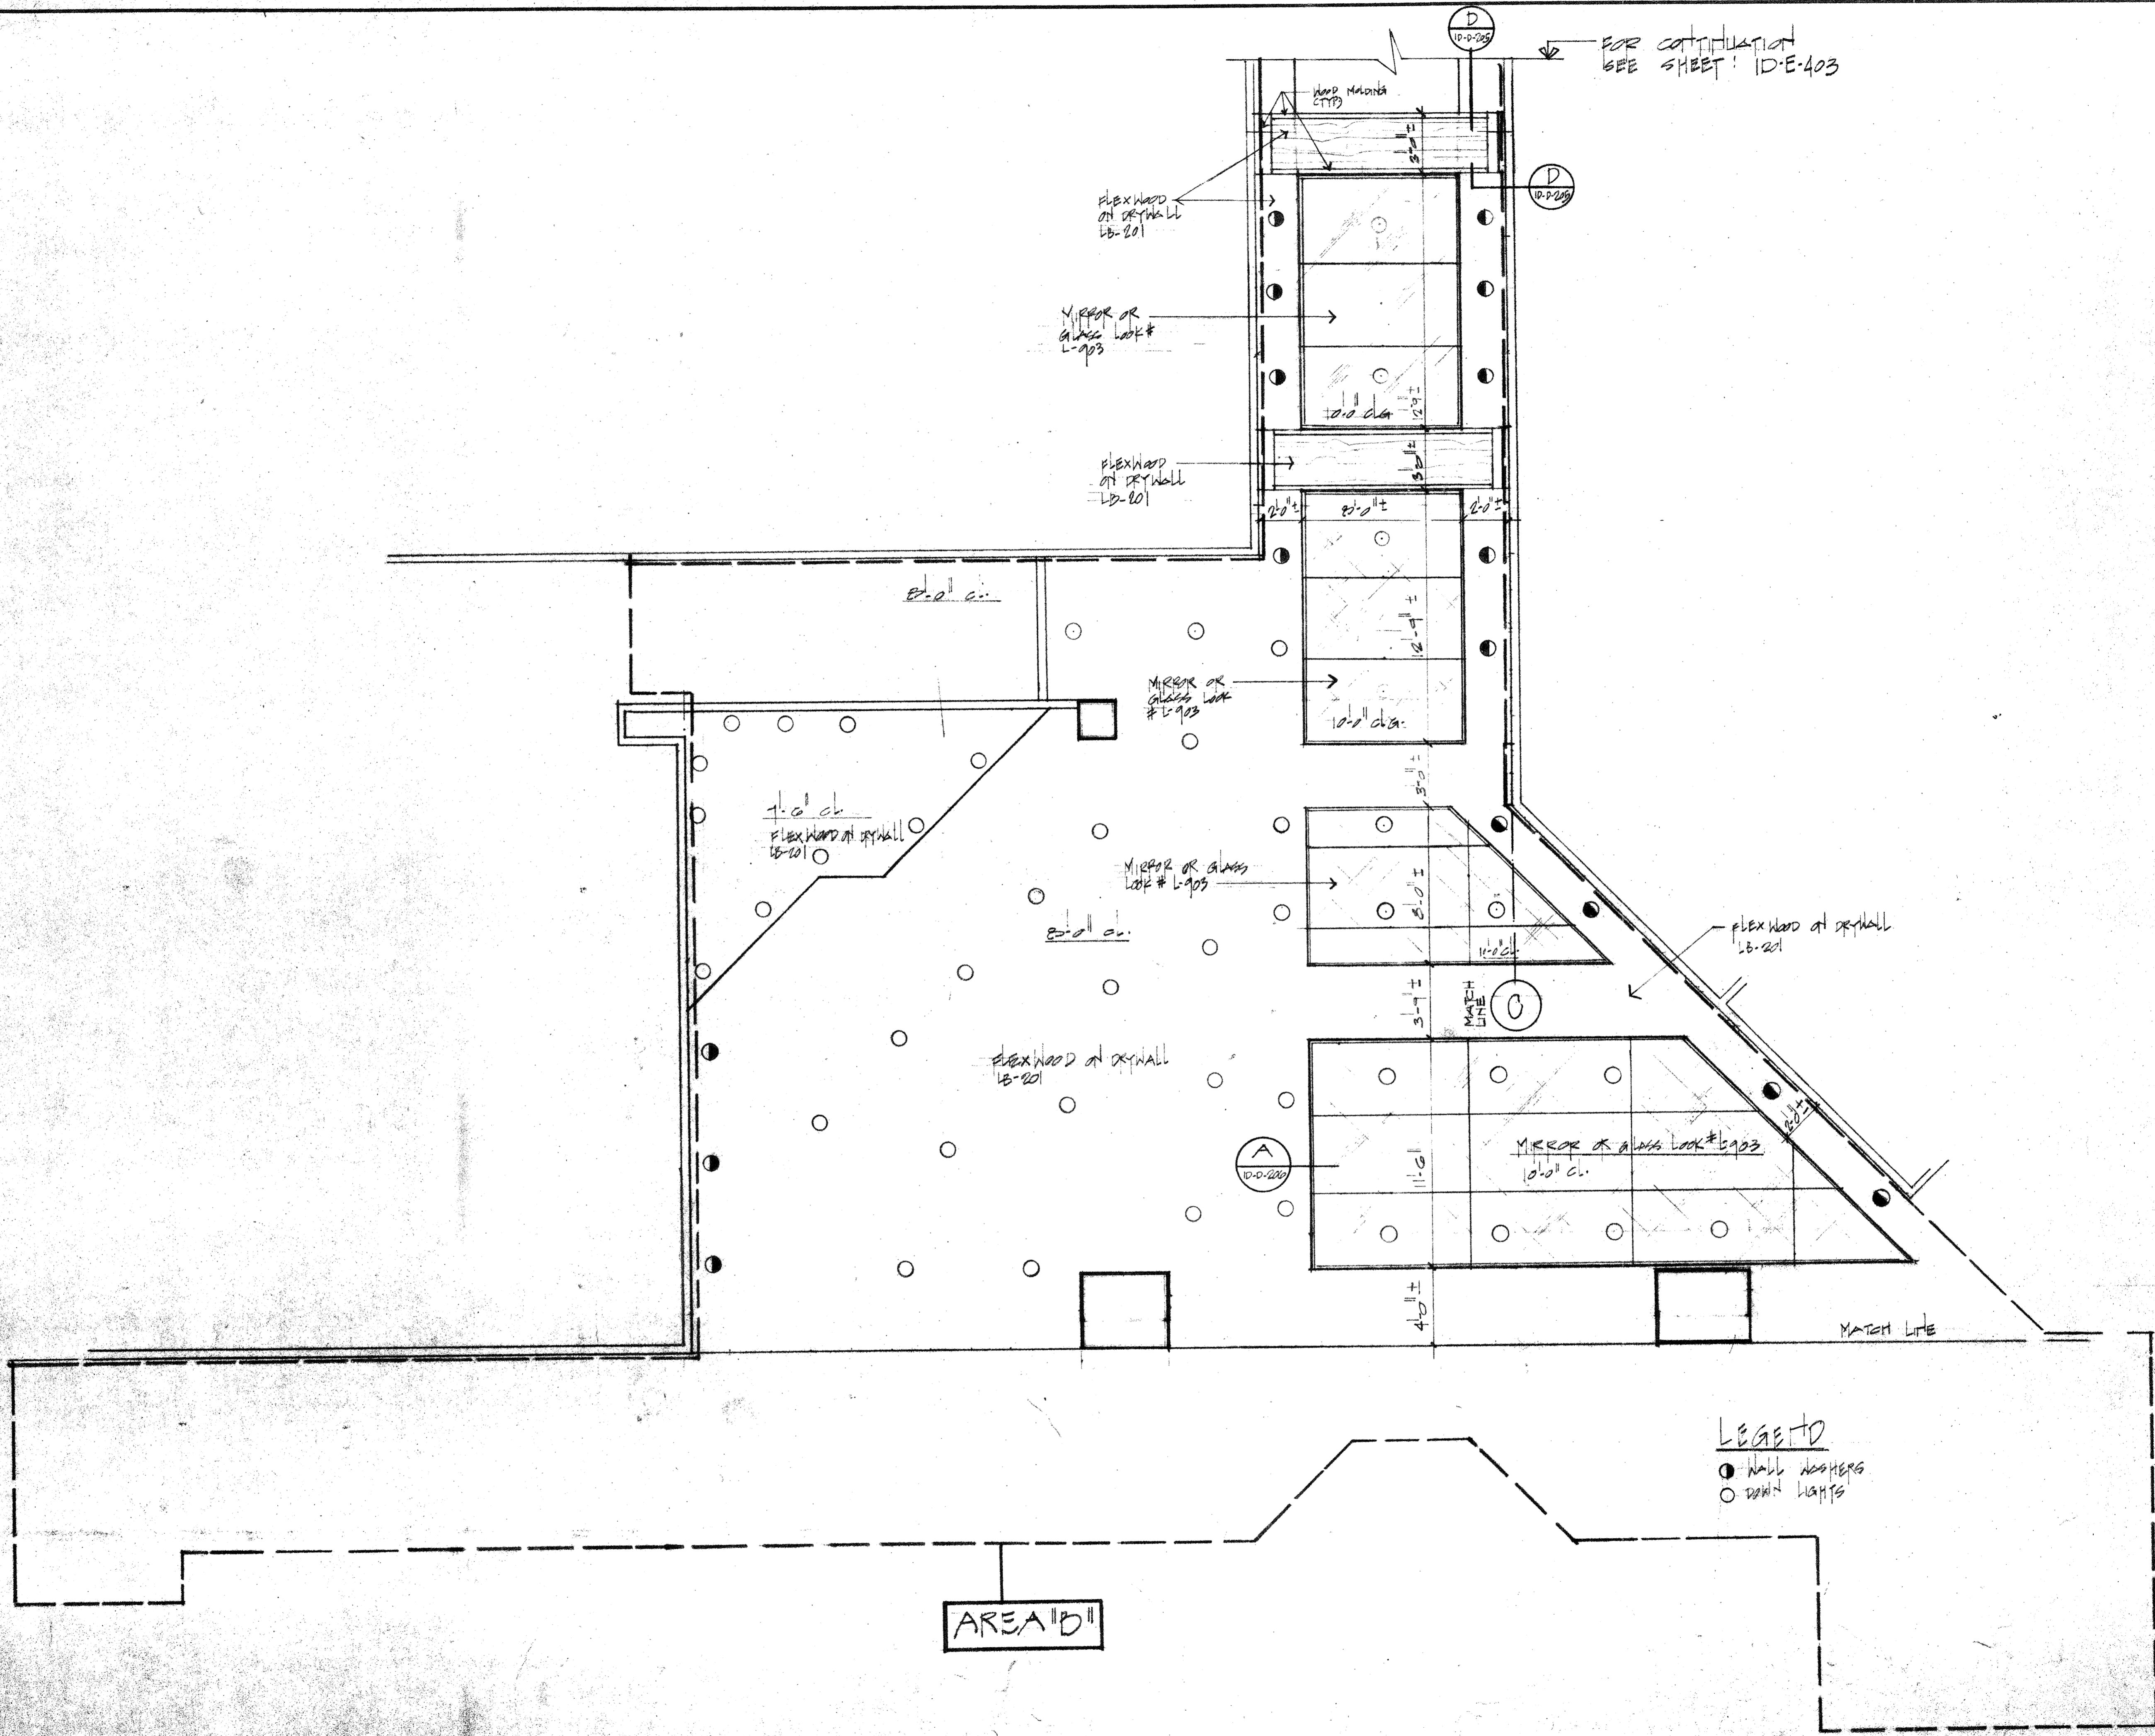


AREA "D"

LEGEND
 ● WALL LIGHTS
 ○ DOWN LIGHTS


ID-E-204
 sheet
 scale
 date

project
 CAPITAL PLAZA HOTEL
 FRANKLIN AVENUE
 MIAMI, FLORIDA

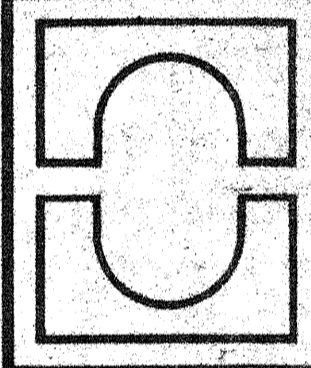

MORRIS-POWELL ASSOCIATES, INC.
 interior designers consultants
 4500 biscayne boulevard suite 200
 miami, florida 33137
 (305) 576-6551

project no.
 revisions
 1) 4-25-52
 2) 7-7-53
 3) 8-12-53

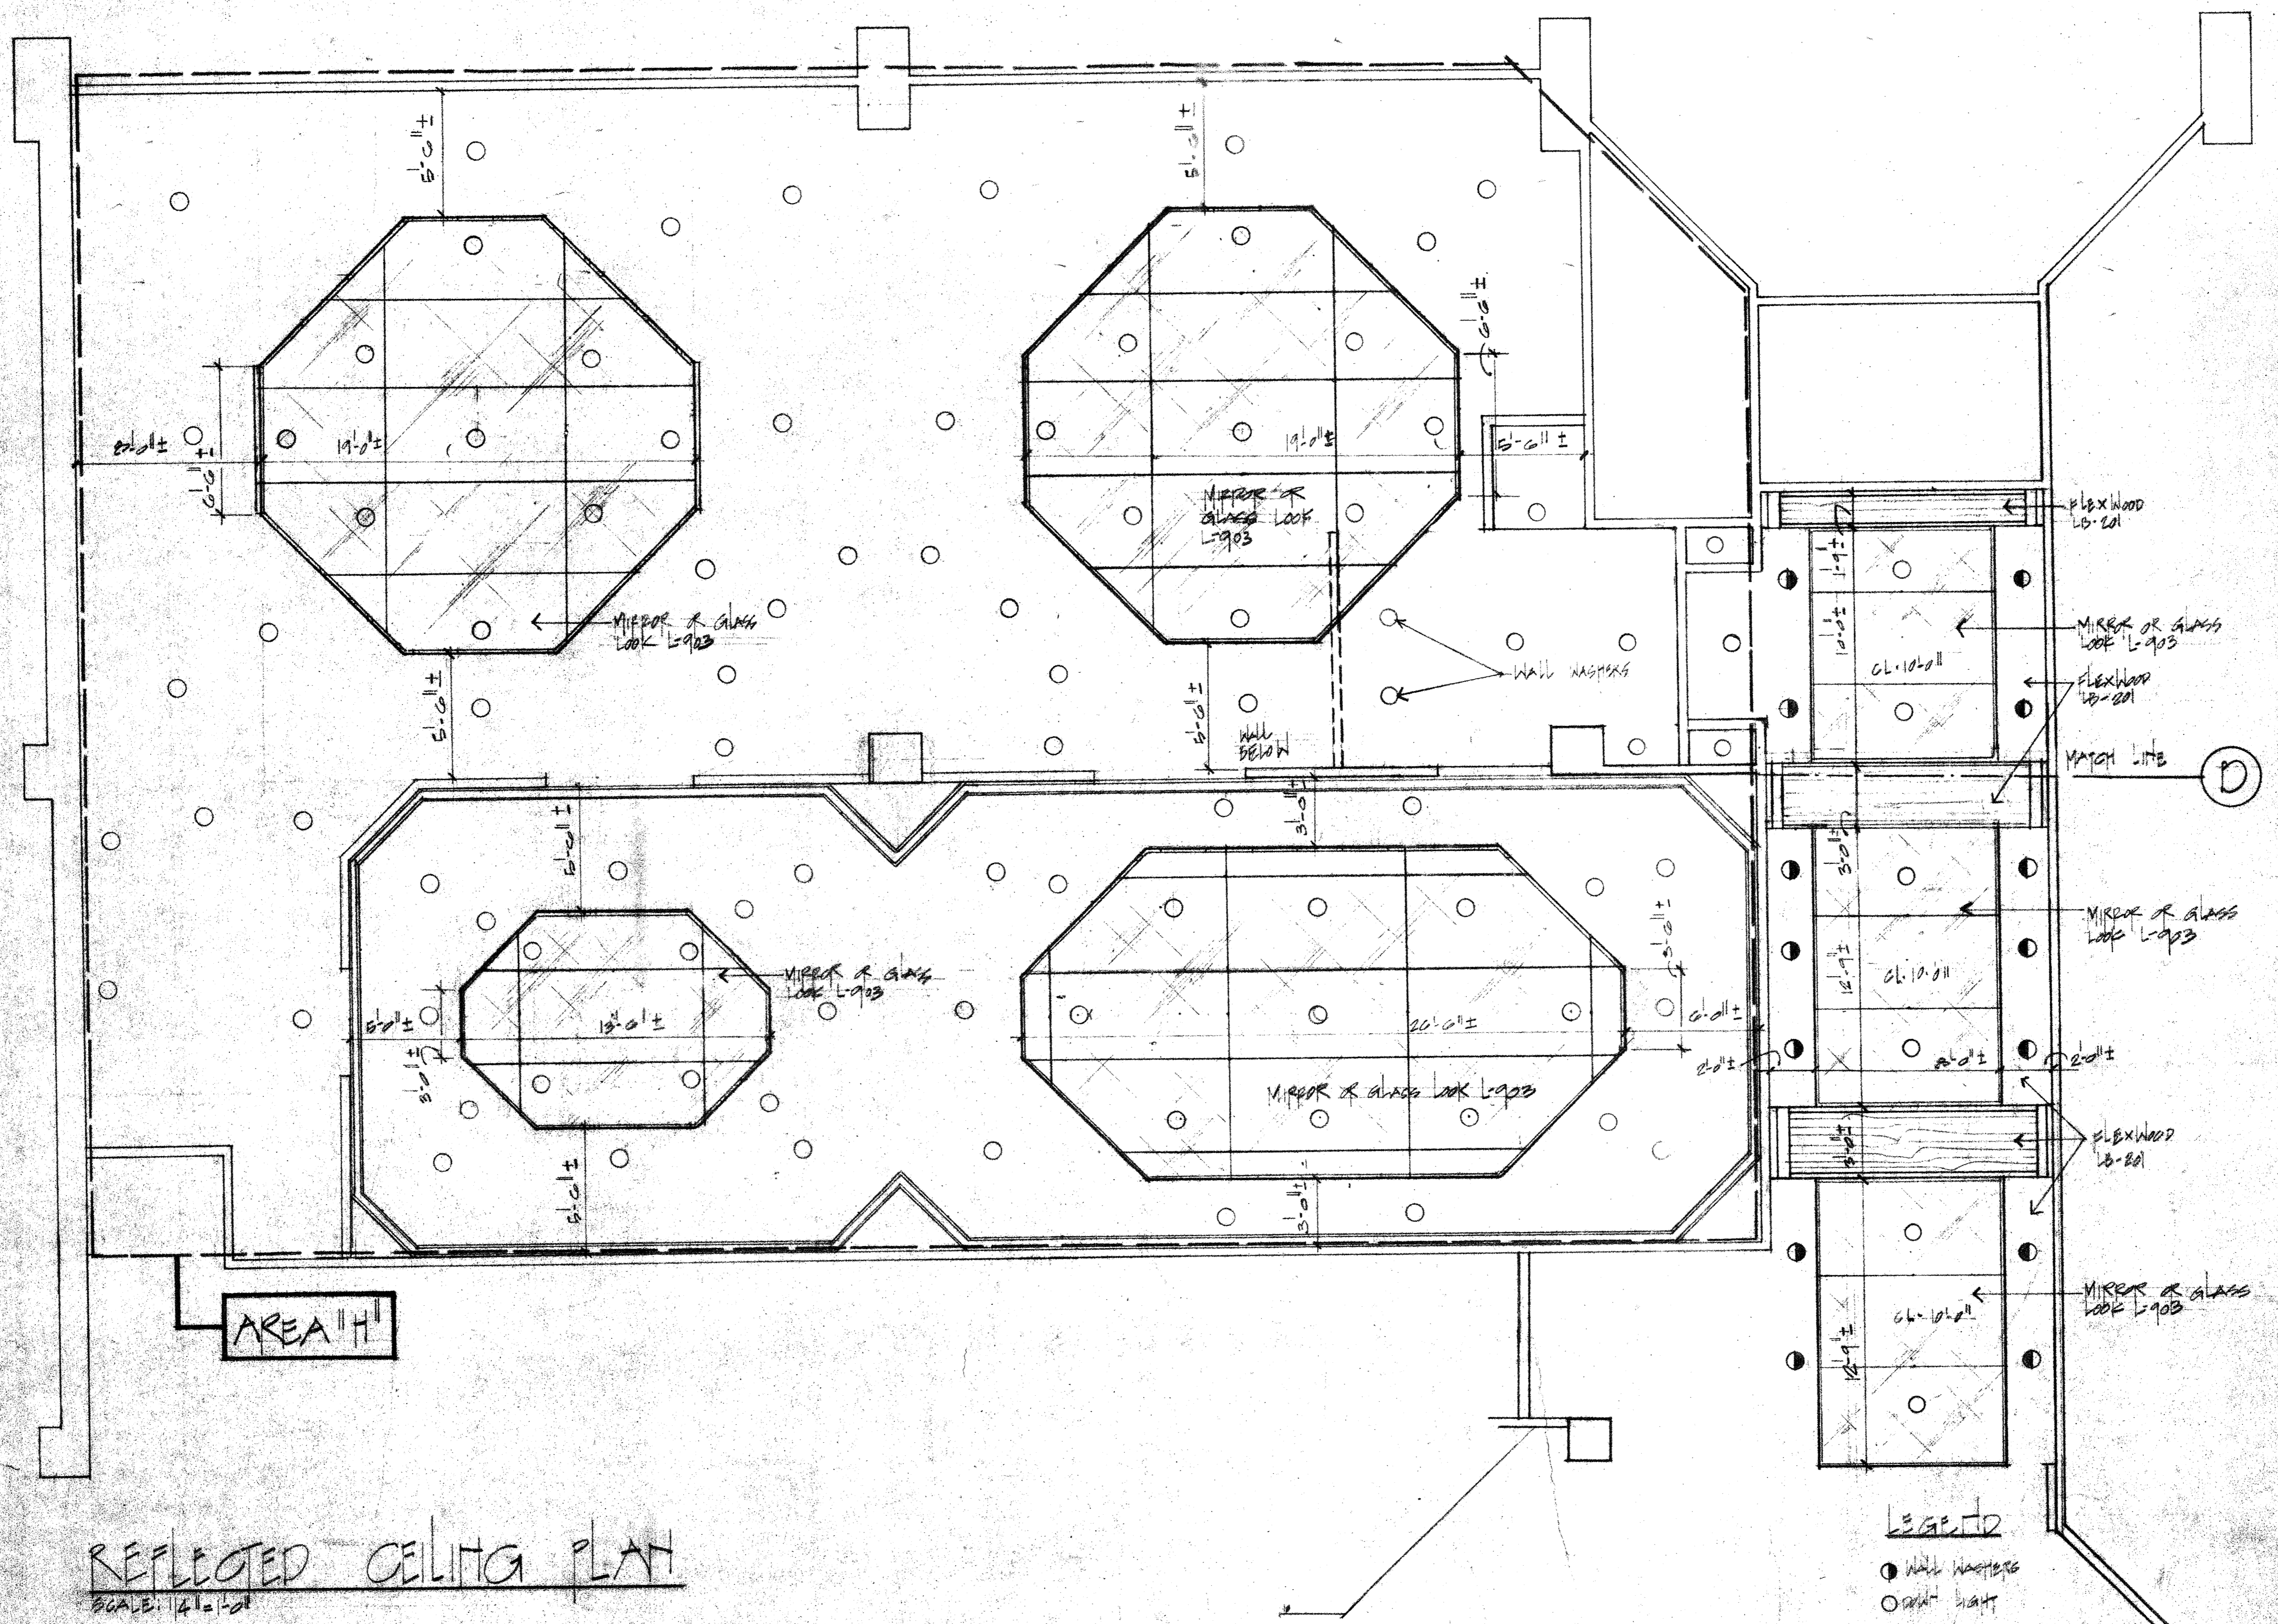

REFLECTED CEILING PLAN
SCALE: 1/4" = 1'-0"

LEGEND


- WALL WASHERS
- GRID LIGHT

project no.
revisions

- (1) 4-15-83
- (2) 4-25-83
- (3) 5-1-83
- (4) 5-1-83

MORRIS-POWELL ASSOCIATES, INC.
interior designers consultants

4500 biscayne boulevard suite 200
miami, florida 33137
(305) 576-6551

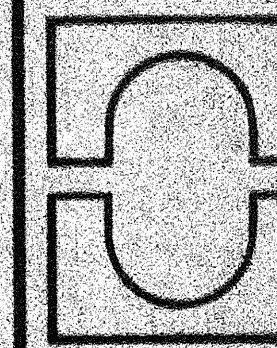


project

CAPITAL HOTEL
CENTRAL
RENOVATION

ID-E-403

sheet
scale
date

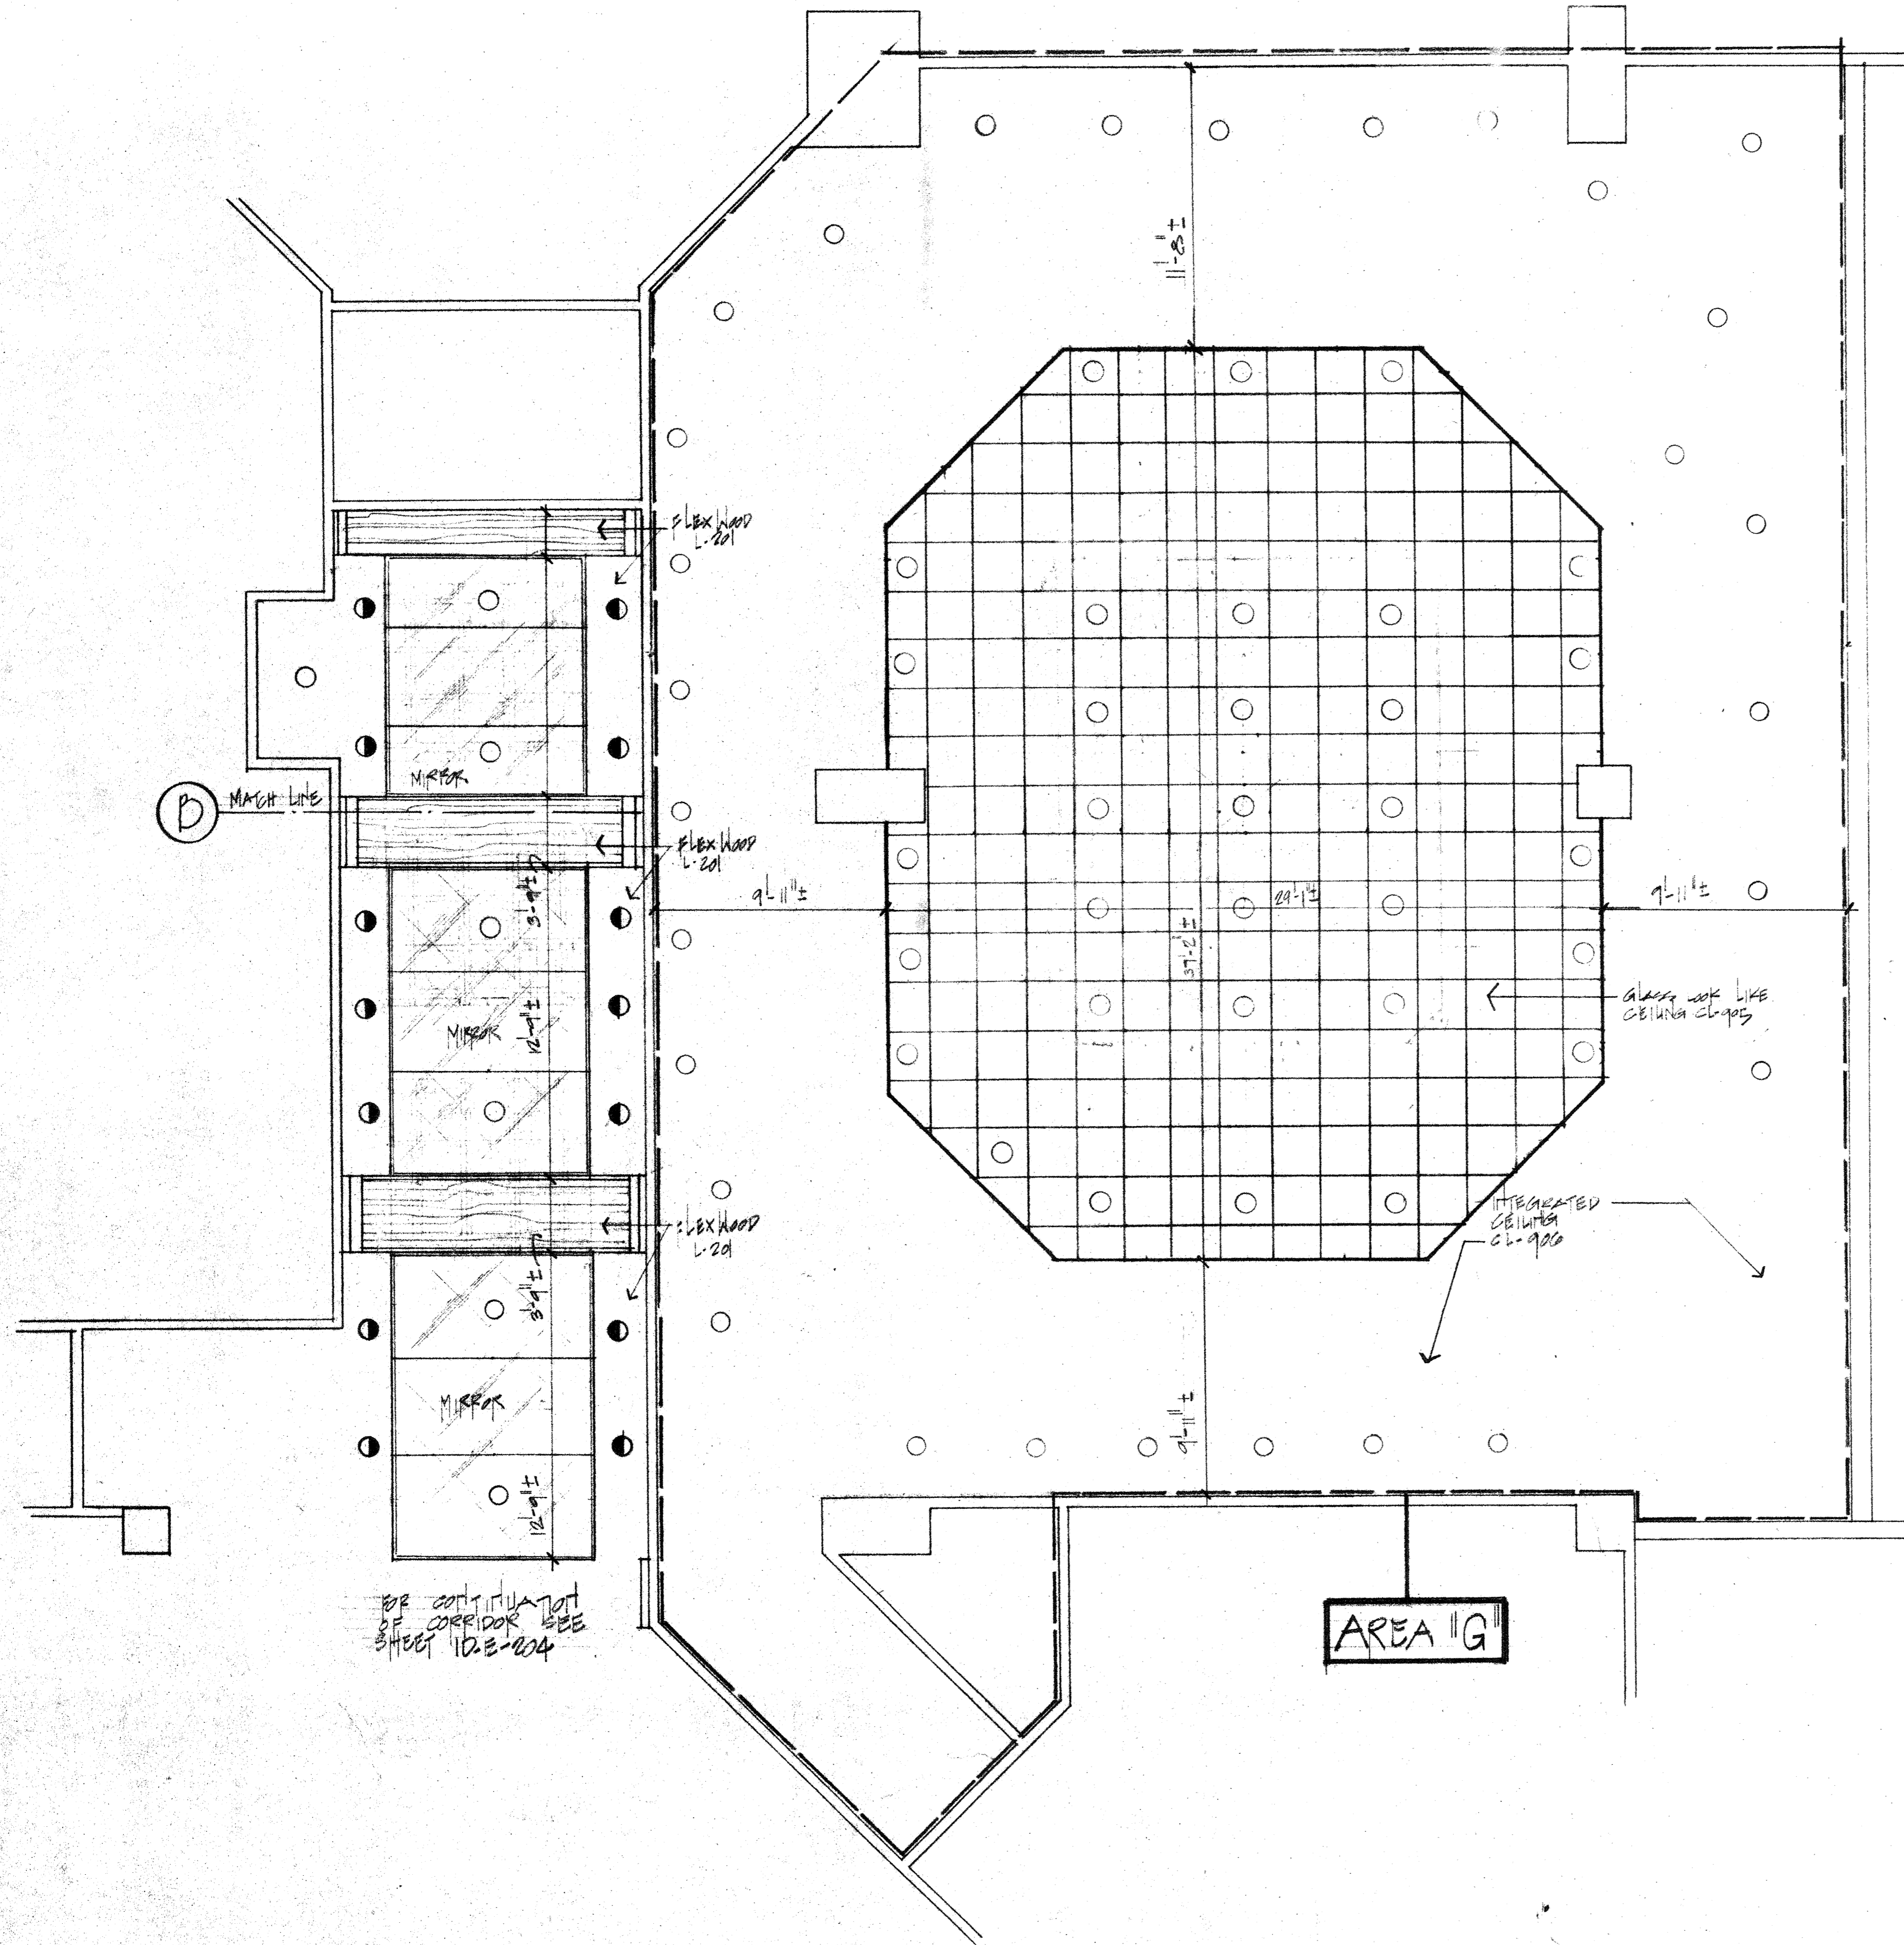


SEE CONTINUATION
OF CORRIDOR
SHEET 10-E-504

AREA 'G'

- LEGEND
- WALL WASHERS
 - POINT LIGHT


10-E-503
sheet
scale 1/4"=1'-0"
date 3-20-03

project
CAPITOL PLAZA HOTEL
FRANKFORT, KENTUCKY
BAR - REFLECTED CEILING PLAN

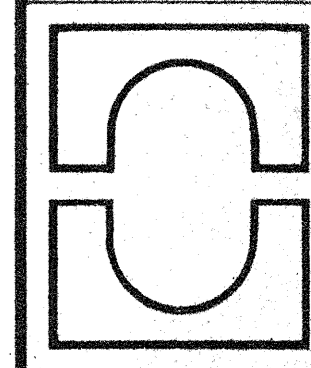


MORRIS-POWELL ASSOCIATES, INC.
interior designers consultants
4500 biscayne boulevard suite 200
miami, florida 33137
(305) 576-6551


project no.
revisions
(1) 4-25-03
(2) 7-7-03
(3) 8-22-03

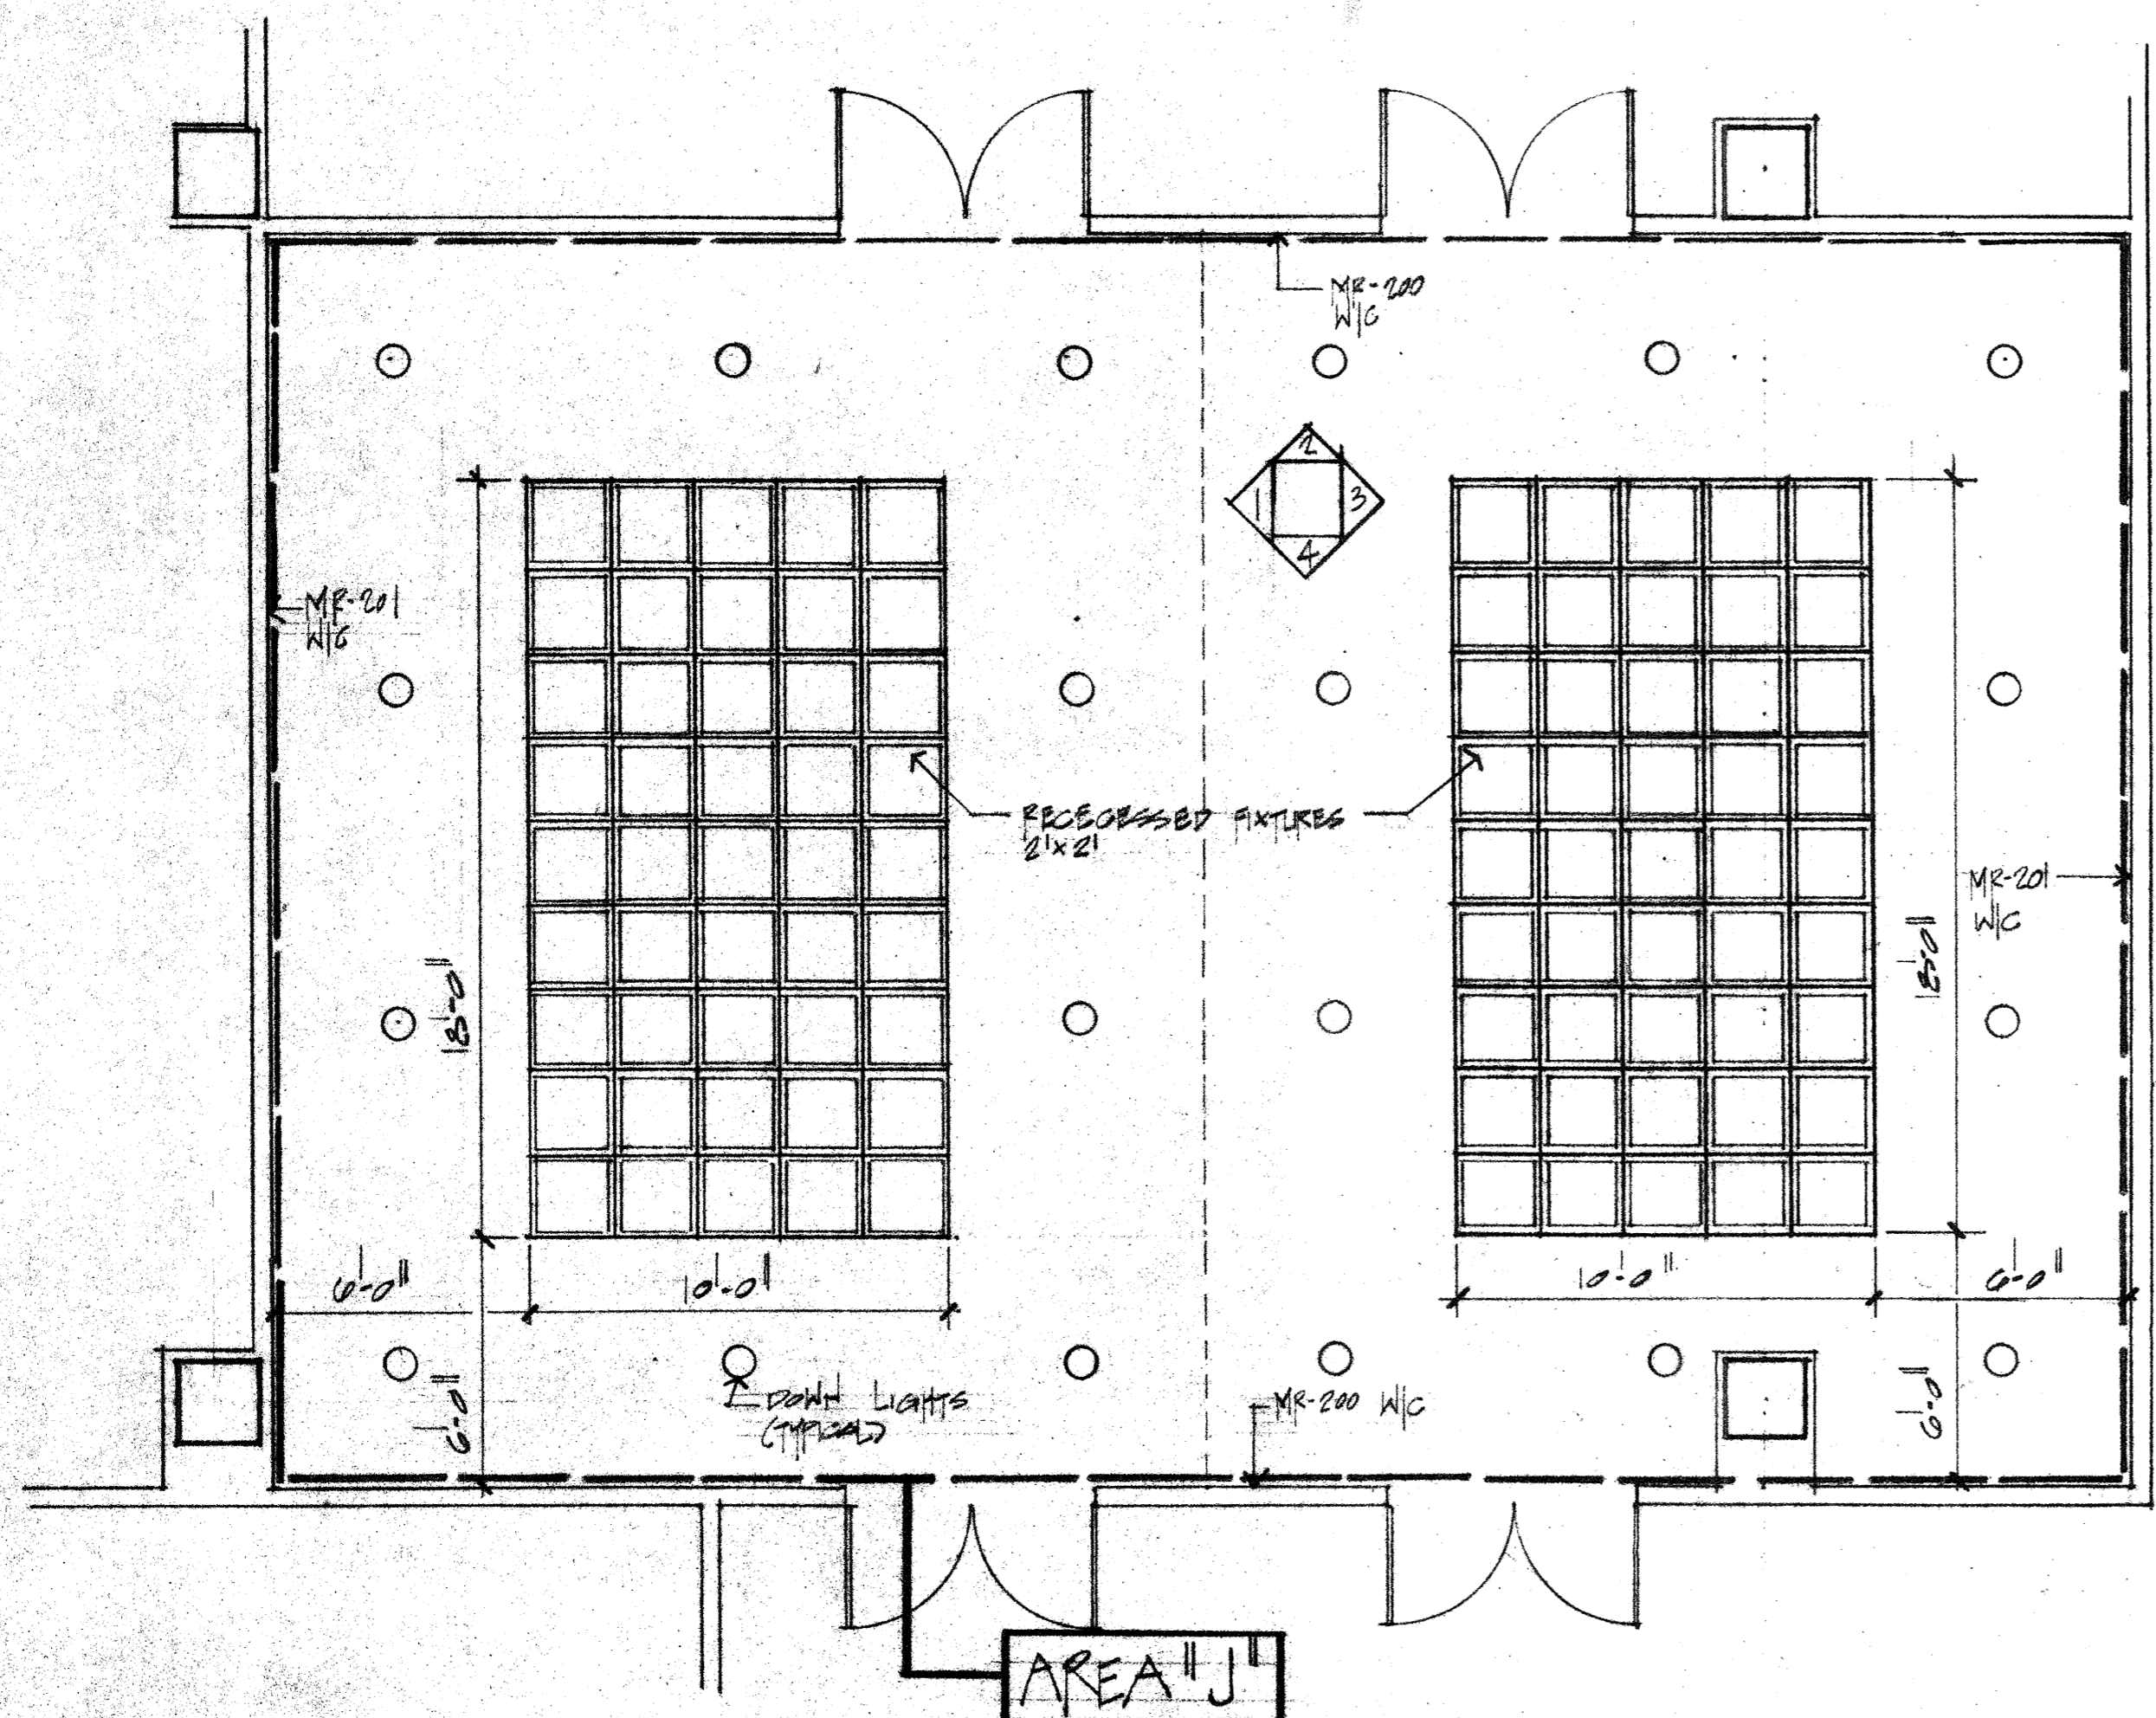

MEETING ROOMS 'A' & 'D' REFLECTED CEILING
SCALE: 1/4" = 1'-0"

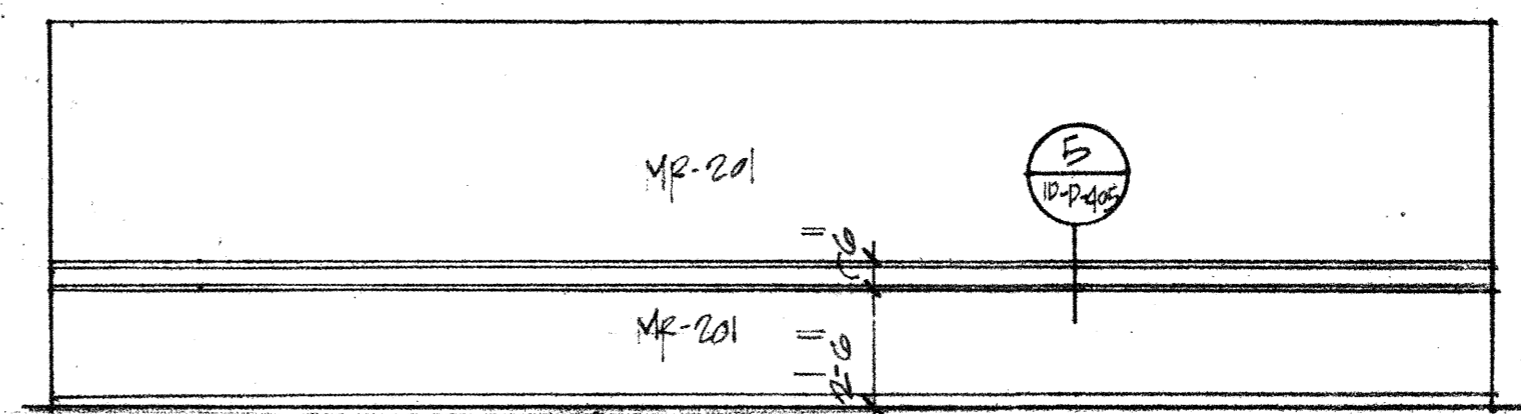


ELEVATION 1, ELEVATION 3 (SIMILAR)
SCALE: 1/4" = 1'-0"

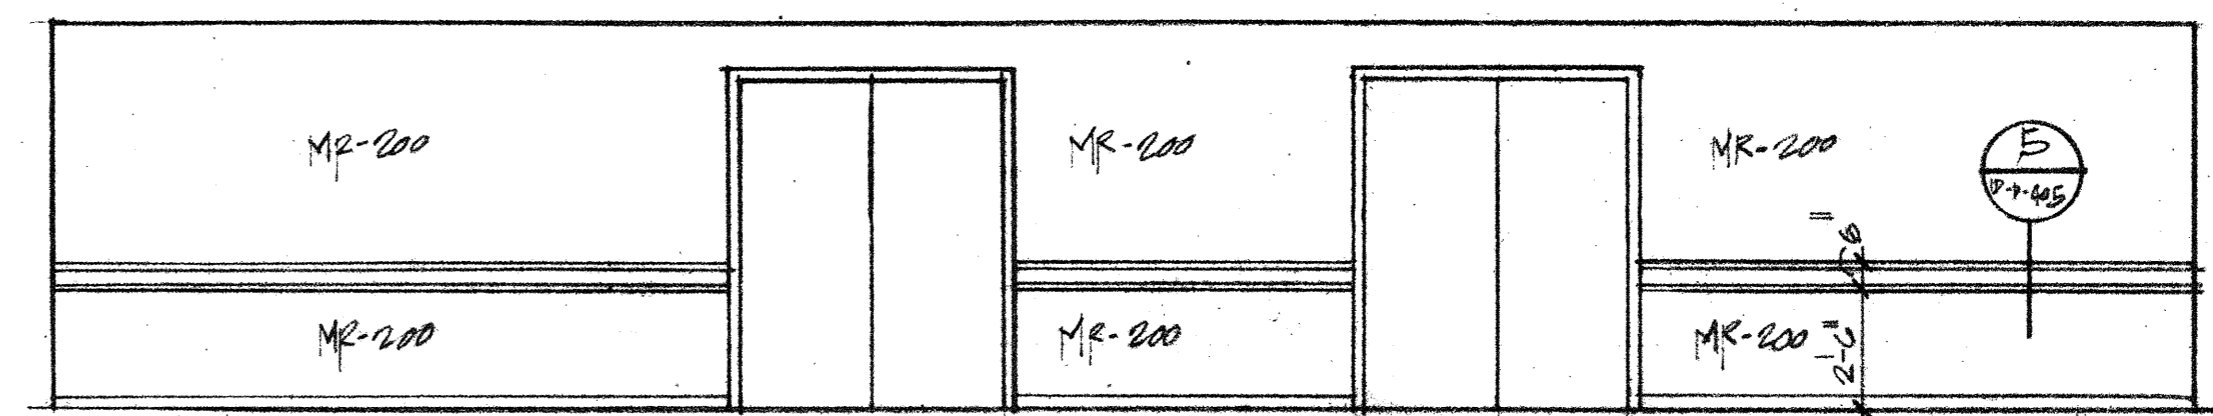

ELEVATION 2, ELEVATION 4 (SIMILAR)
SCALE: 1/4" = 1'-0"


project no.
revisions

MORRIS-POWELL ASSOCIATES, INC.
interior designers—consultants
4500 biscayne boulevard—suite 200
miami, florida 33137
(305) 576-6551

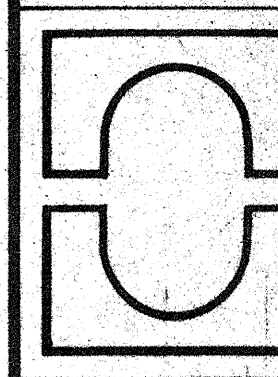

project
CAPITOL PLAZA HOTEL
FRANKFORT, KENTUCKY
MEETING ROOMS REFLECTED CEILING PLAN


D-F-601
sheet
scale AS SHOWN
date 12-12-83

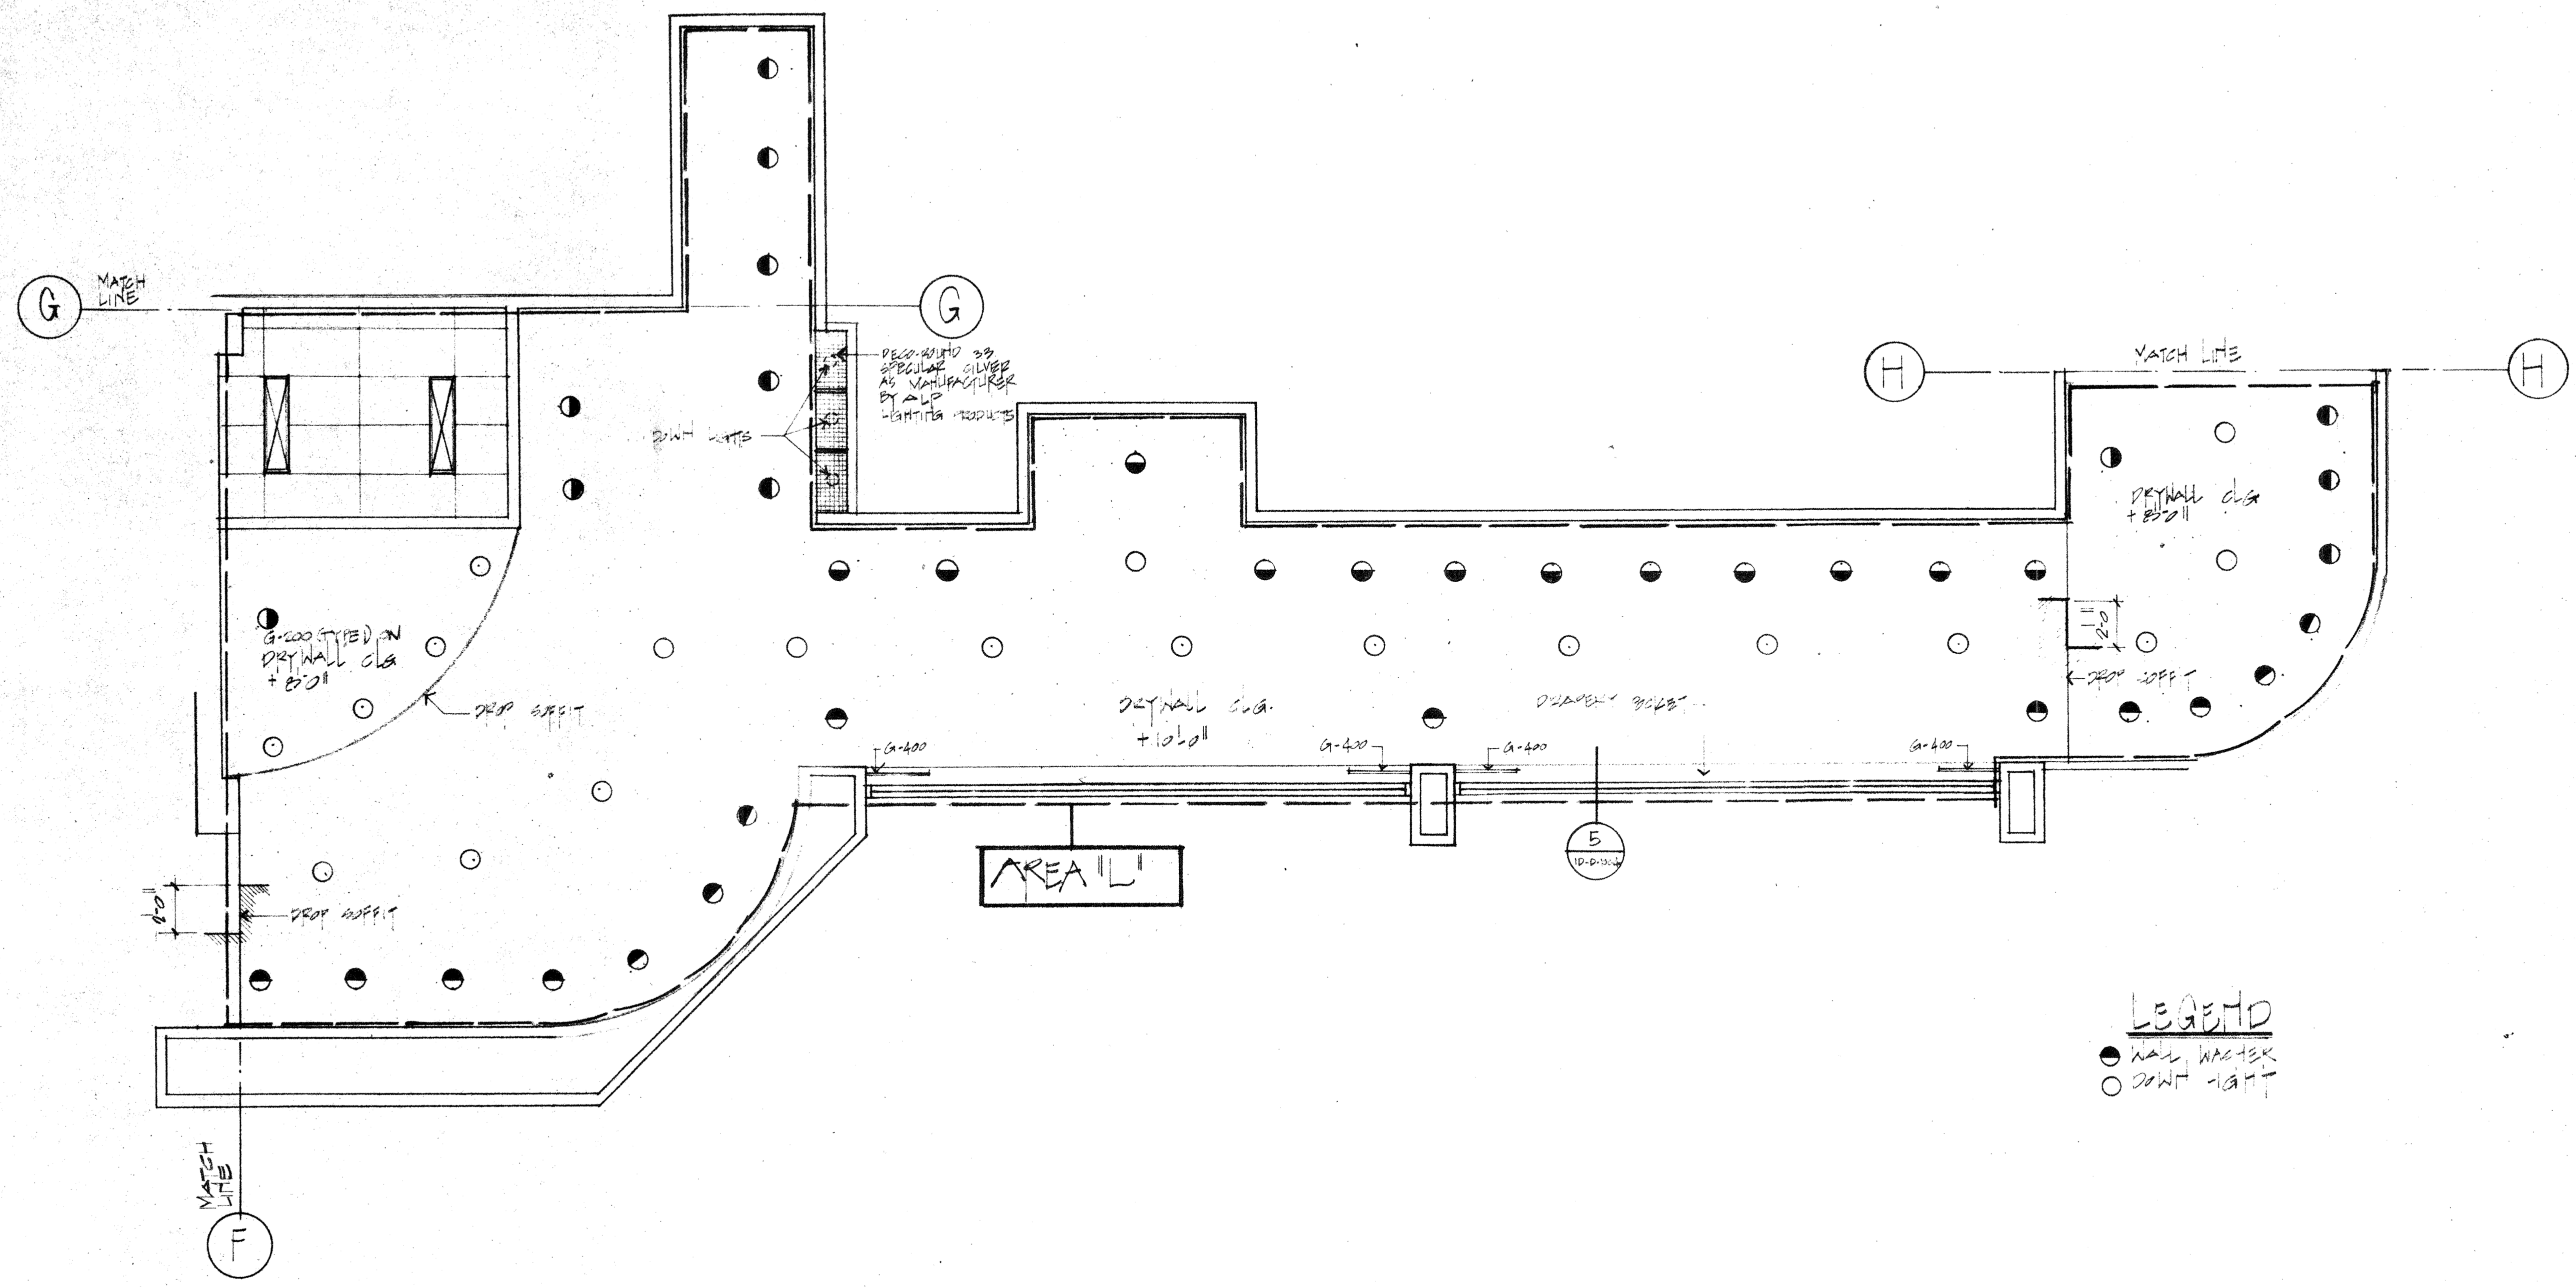

LEGEND
 ● WALL TEXTURE
 ○ DOWN LIGHT


D-E-001
 sheet
 scale: 1/4" = 1'-0"
 date: 5-15-83

project
 CAPITOL PLAZA HOTEL
 FRANKFORT, KENTUCKY
 GALLERY REFLECTED CEILING PLAN

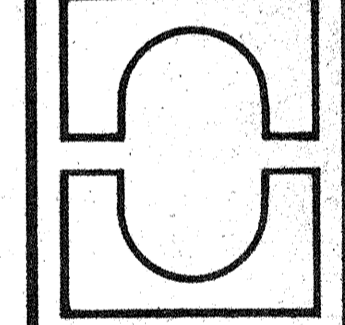

MORRIS-POWELL ASSOCIATES, INC.
 interior designers — consultants
 4500 biscayne boulevard — suite 200
 miami, florida 33137
 (305) 576-6551

project no.
 revisions

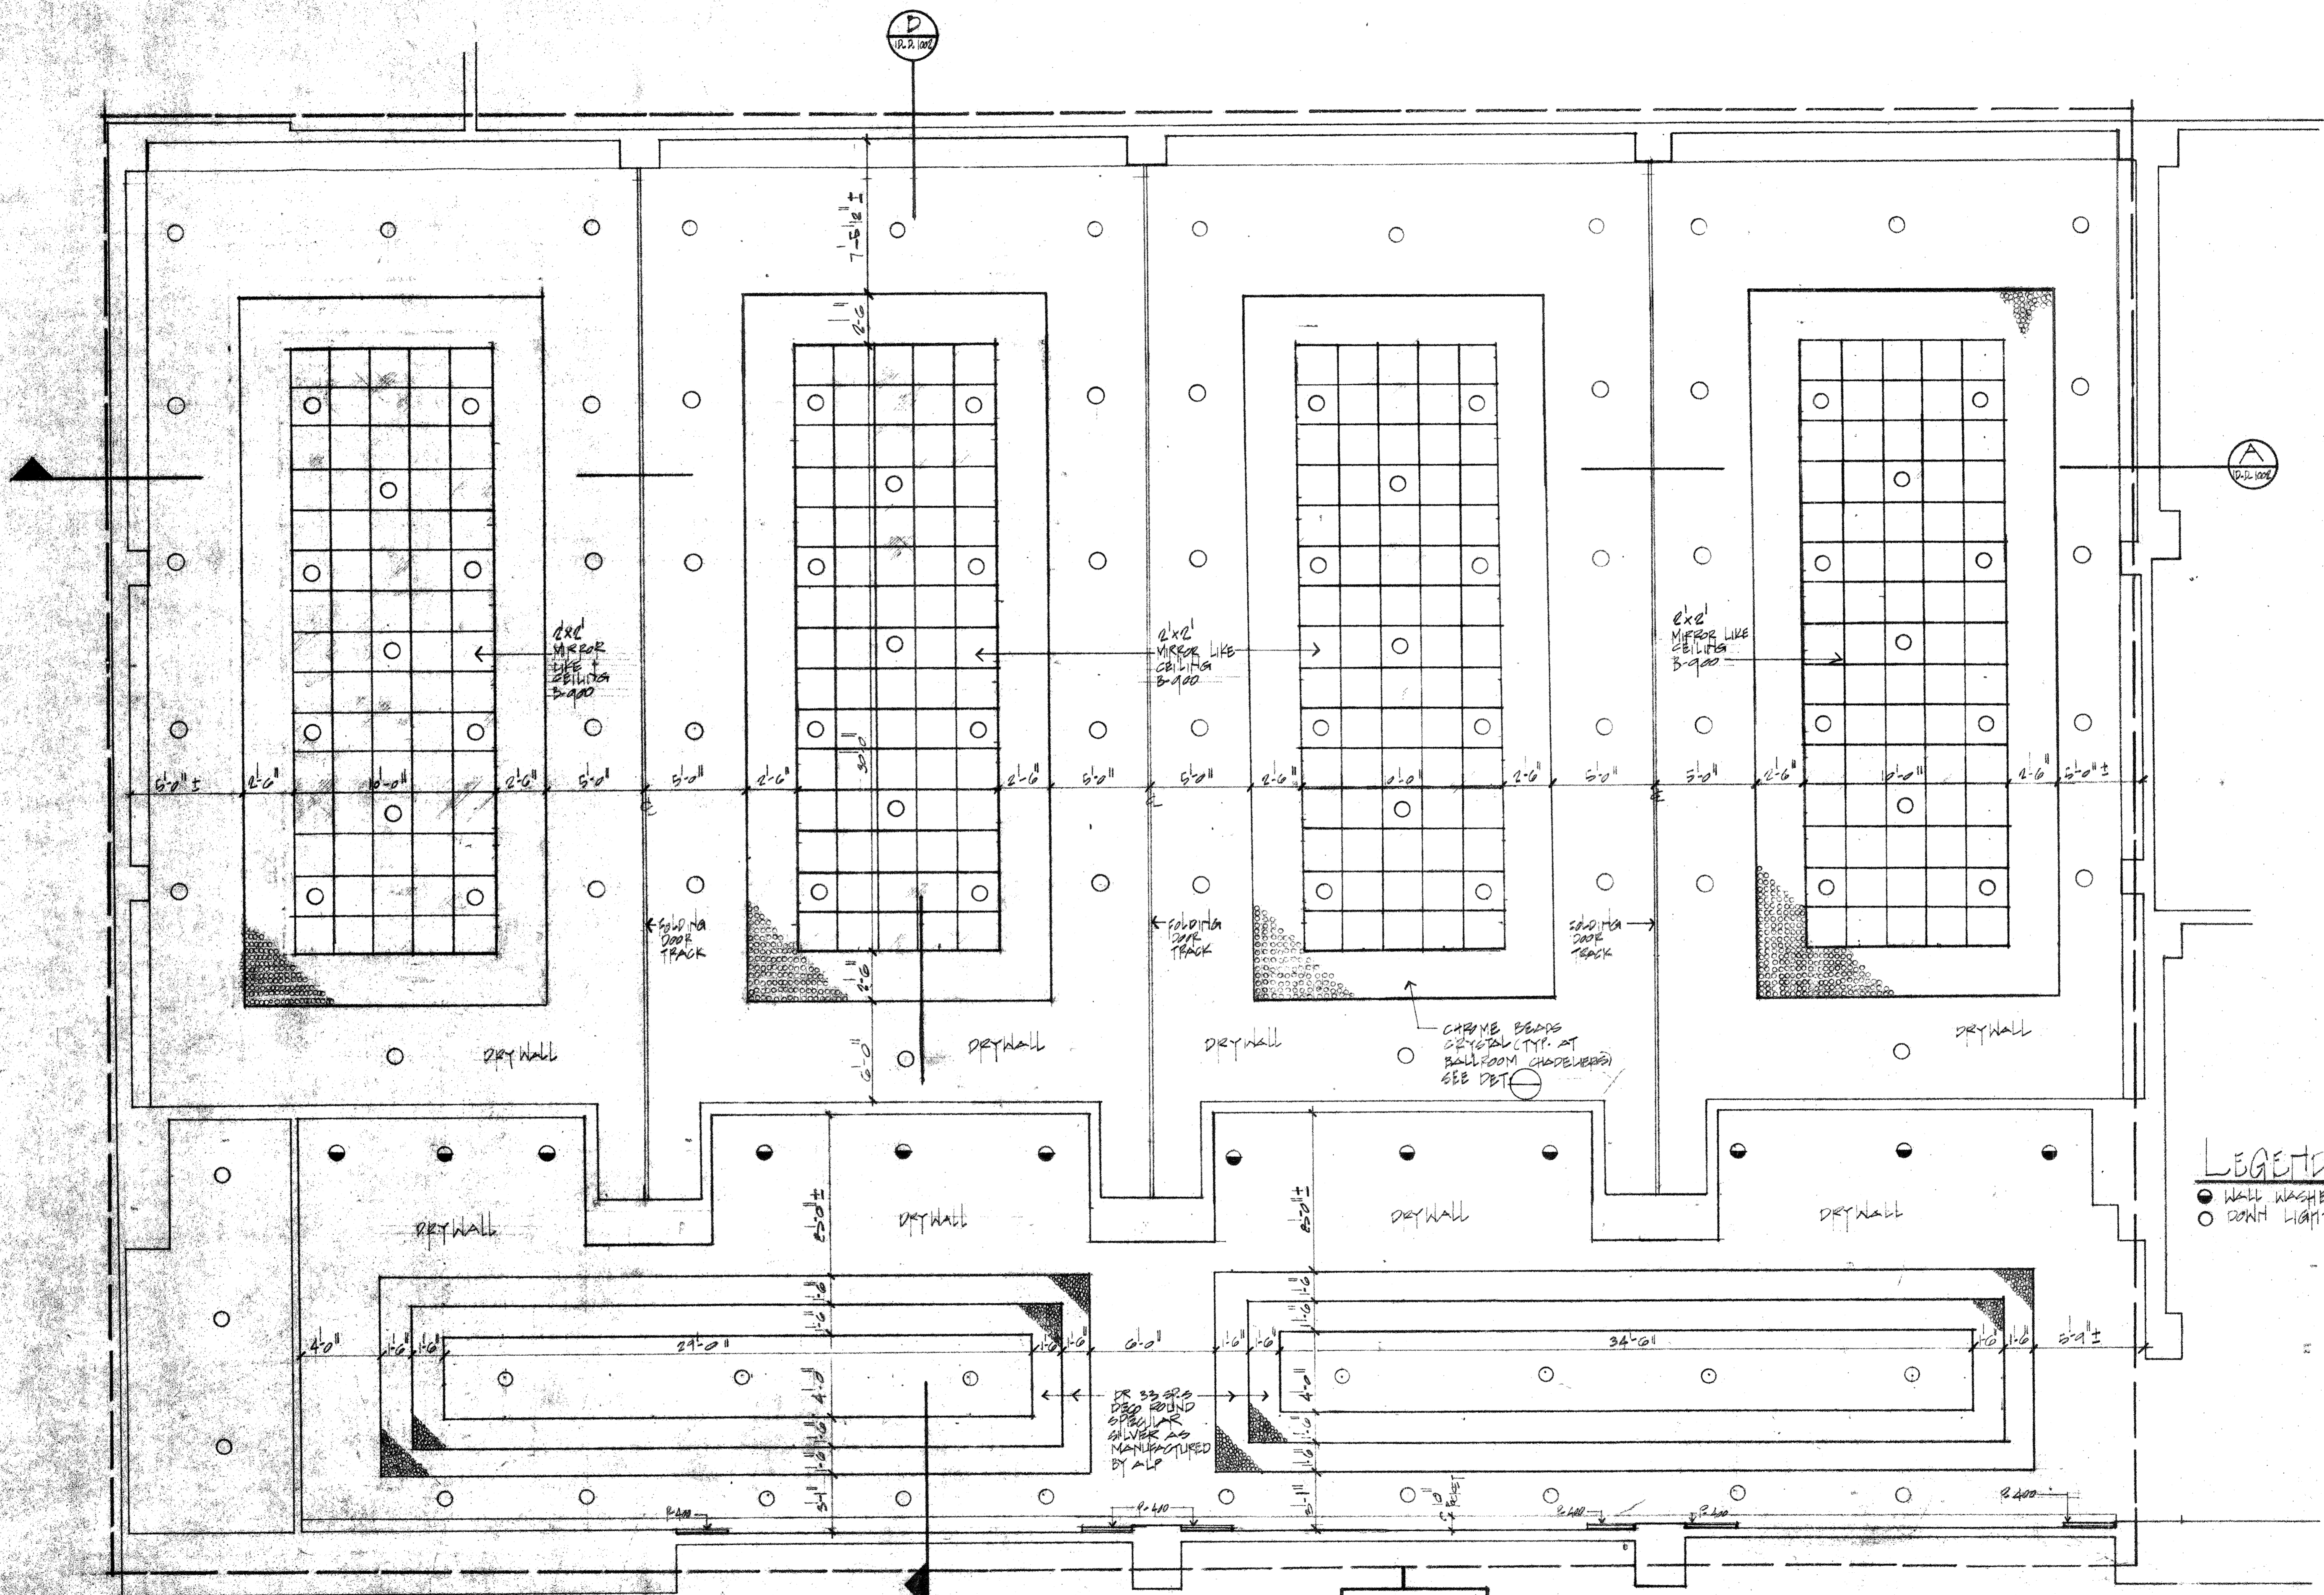


REFLECTED CEILING PLAN
SCALE: 1/4" = 1'-0"

AREA 111

LEGEND
 ● WALL WASHERS
 ○ DOWN LIGHTS

project no.
 revisions
 (1) 4-25-83
 (2) 8-2-83

MORRIS-POWELL ASSOCIATES, INC.
 interior designers — consultants
 4500 biscayne boulevard — suite 200
 miami, florida 33137
 (305) 576-6551

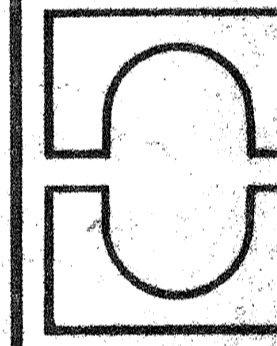

project
 CAPITAL PLAZA HOTEL
 FRANKER - KENTUCKY
 BALLROOM - REFLECTED CEILING PLAN

ID-E-1003
 sheet 14 of 16
 scale 1/4" = 1'-0"
 date 5-30-83